


INSTALL PDS CONDUIT & LOCK


ROOM 231, BUILDING 200

MARINE CORPS AIR STATION

CHERRY POINT, NORTH CAROLINA

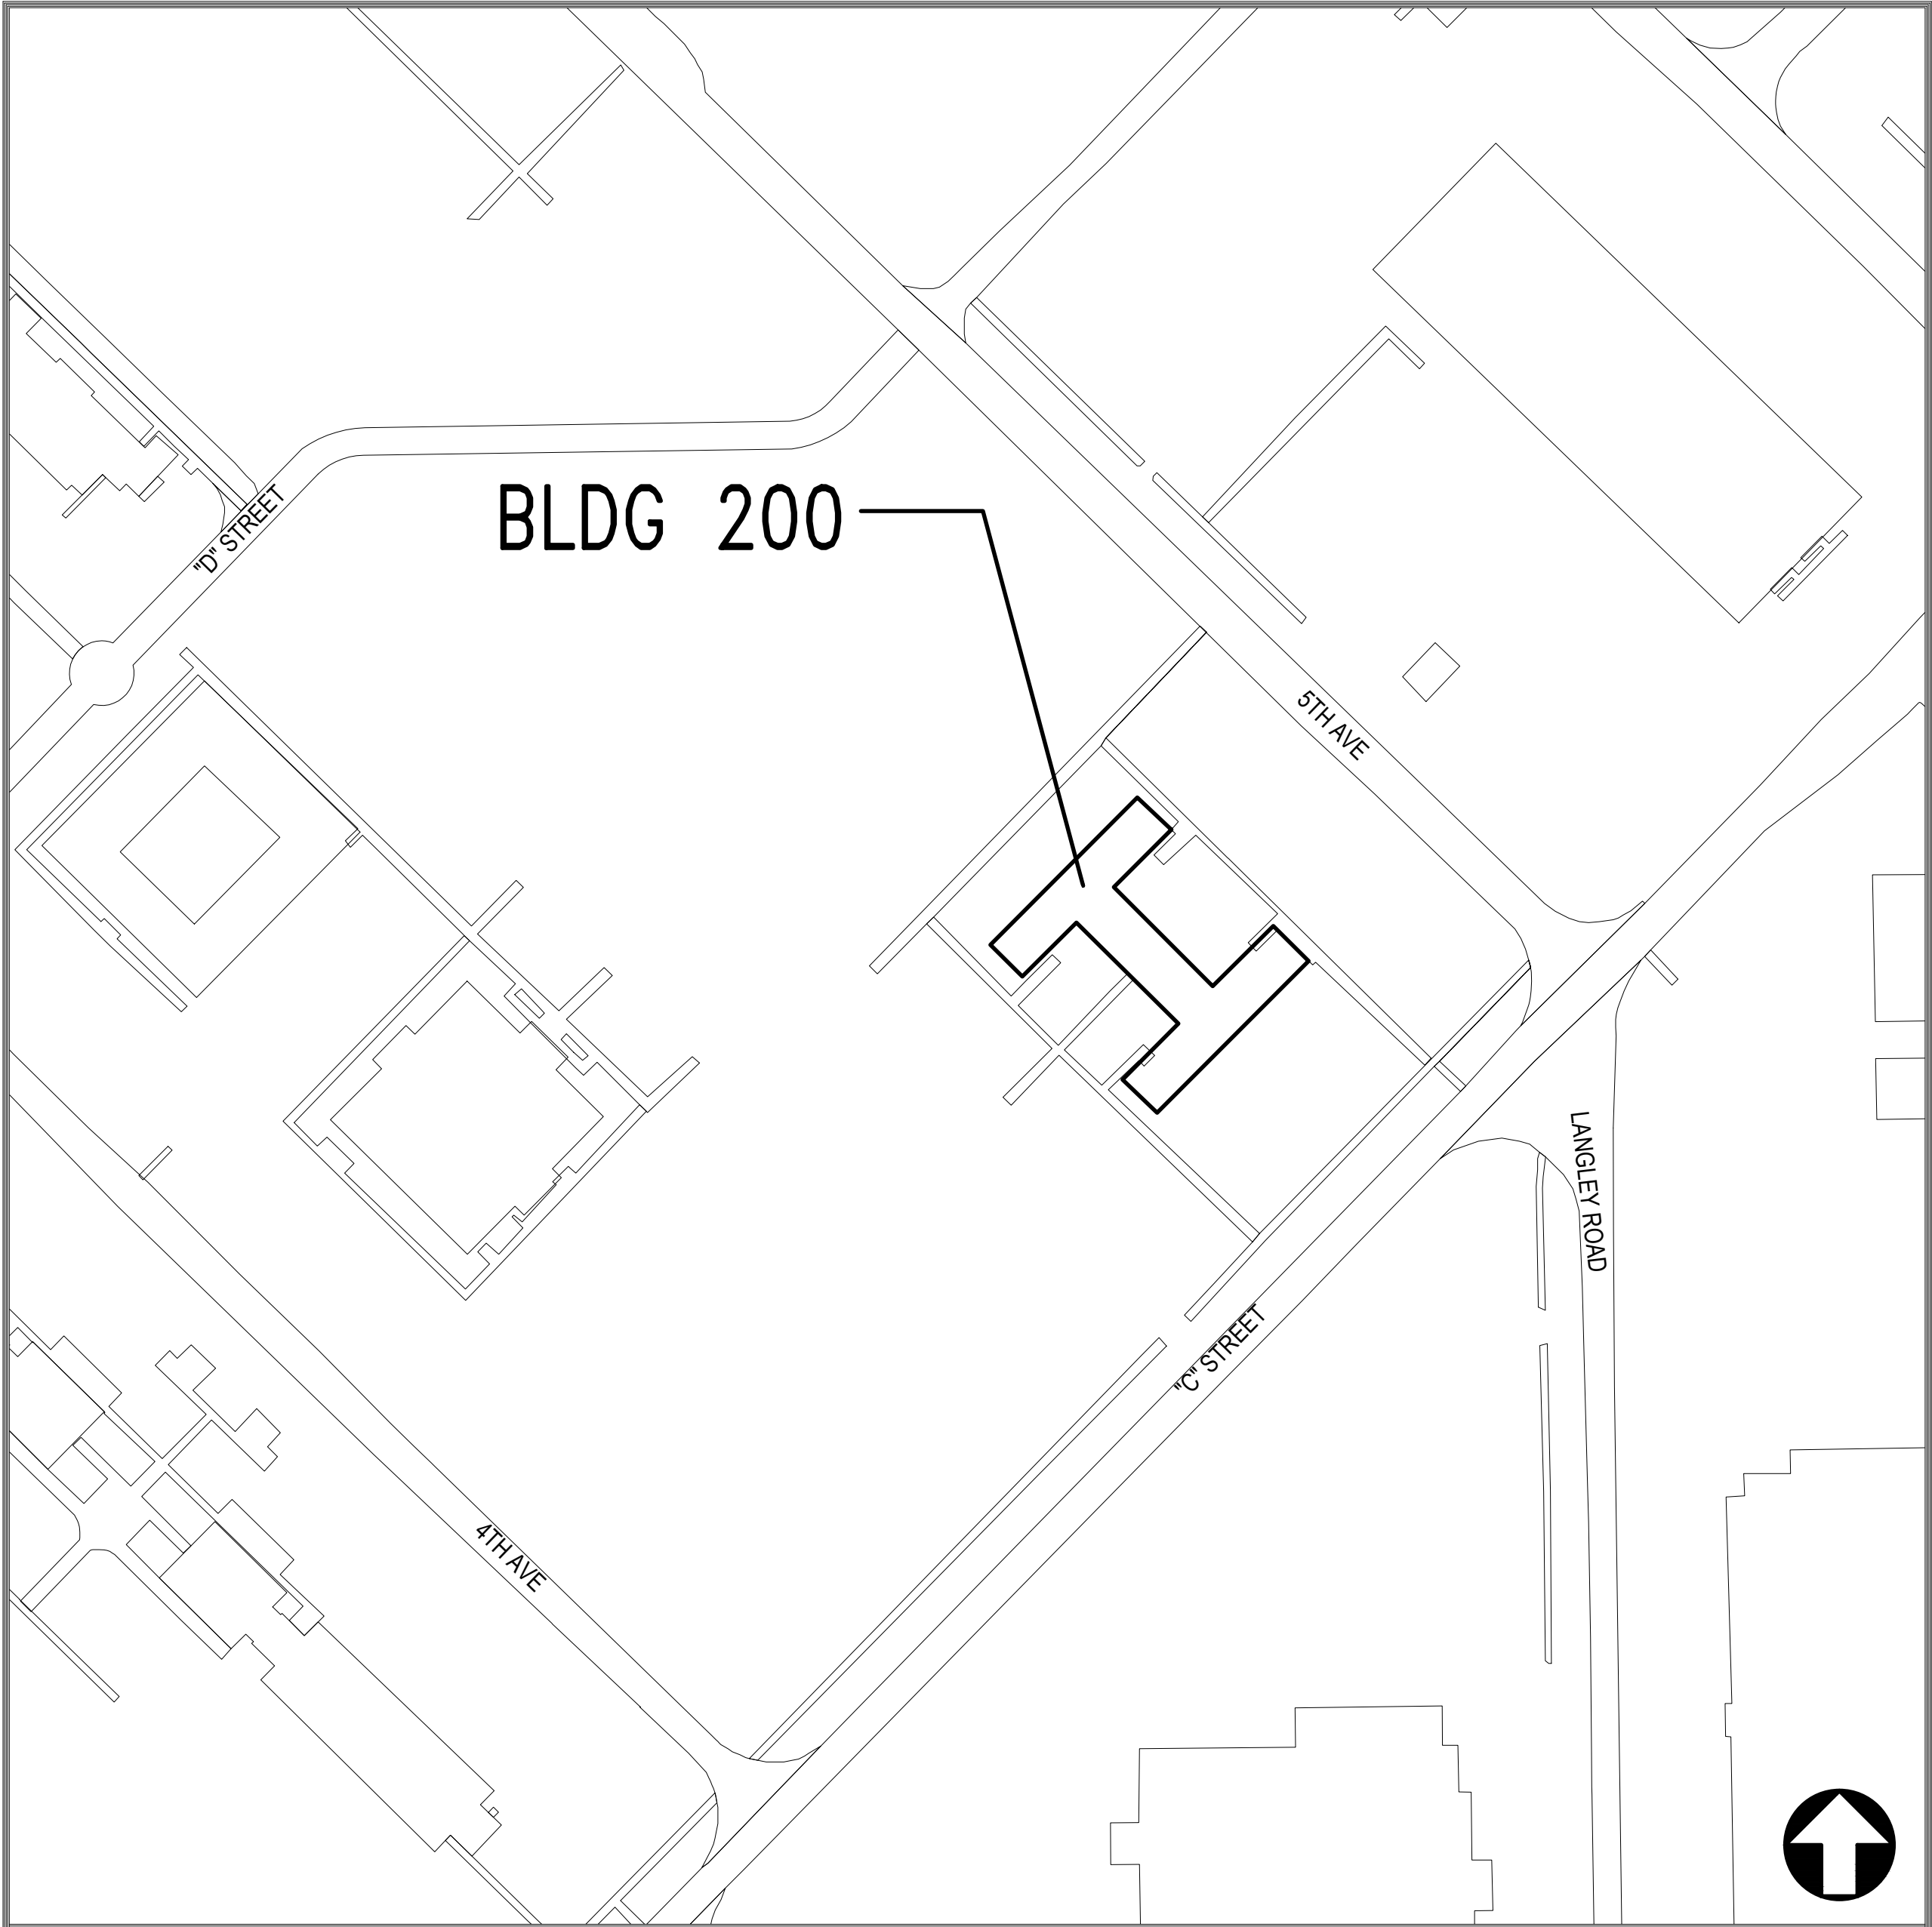

LOCATION MAP

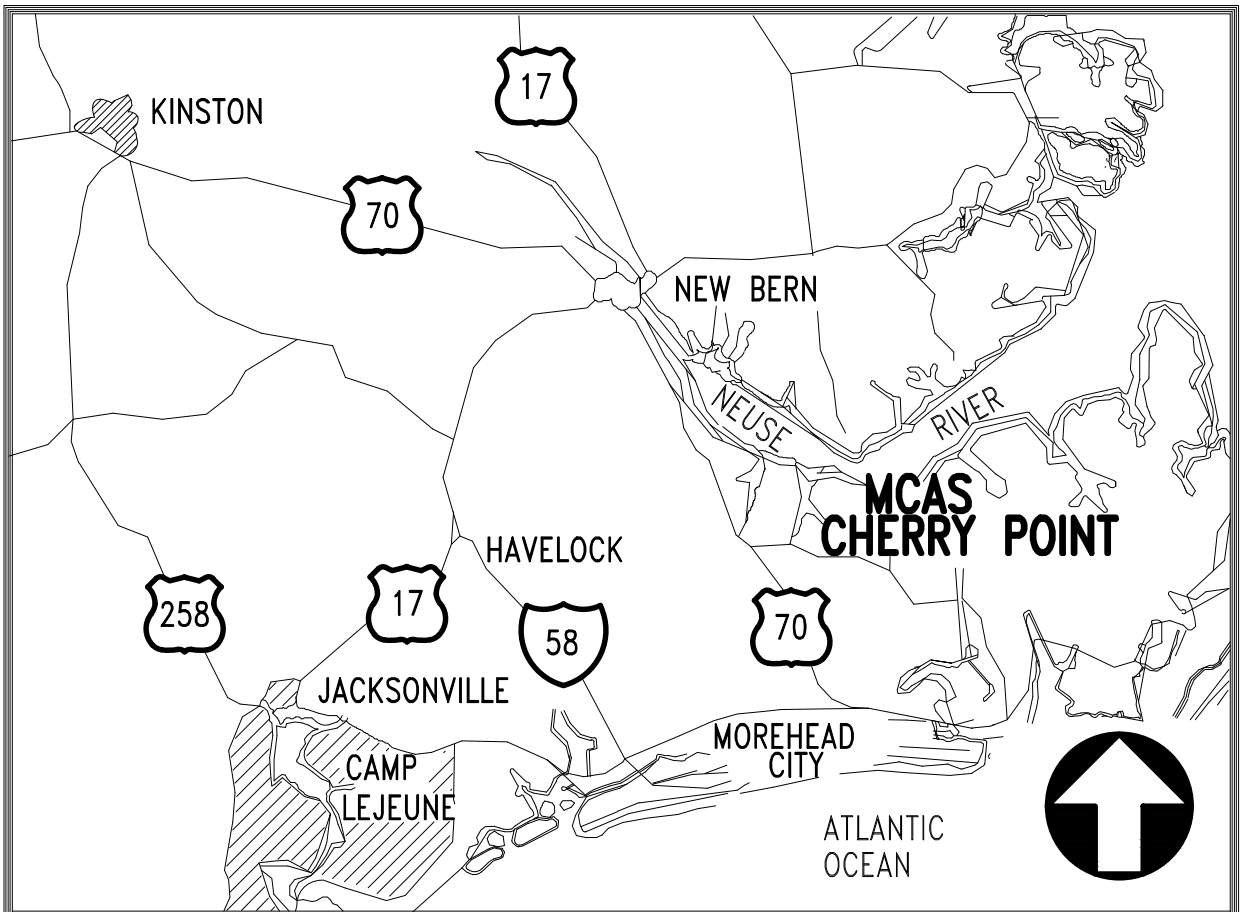

VICINITY MAP

INDEX OF DRAWINGS			
NAVFAC NO.	SHT. NO.	DWG NO.	TITLE
12866828	1	G-001	TITLE SHEET
12866829	2	T-001	TELECOMMUNICATIONS – GENERAL NOTES, LEGEND, AND ABBREVIATIONS
12866830	3	T-101	TELECOMMUNICATIONS SECOND FLOOR CONSTRUCTION PLAN



APPROVED	<i>Pete Ford</i>
FOR COMMANDER NAVFAC	
ACTIVITY	2/24/2023
SATISFACTORY TO	
BES	CRW
DRW	CAR
CHK	MHF

U.S. MARINE CORPS AIR STATION

CHERRY POINT, NORTH CAROLINA

INSTALL PDS CONDUIT & LOCK ROOM 231,

BUILDING 200

TITLE SHEET


SCALE:	AS NOTED
PROJECT NO.:	7253050
MAXIMO WORK ORDER NO.	7253050
NAVFAC DRAWING NO.	12866828
SHEET	1 OF 3
G-001	

D


UNCLASSIFIED//FOR OFFICIAL USE ONLY

B

A

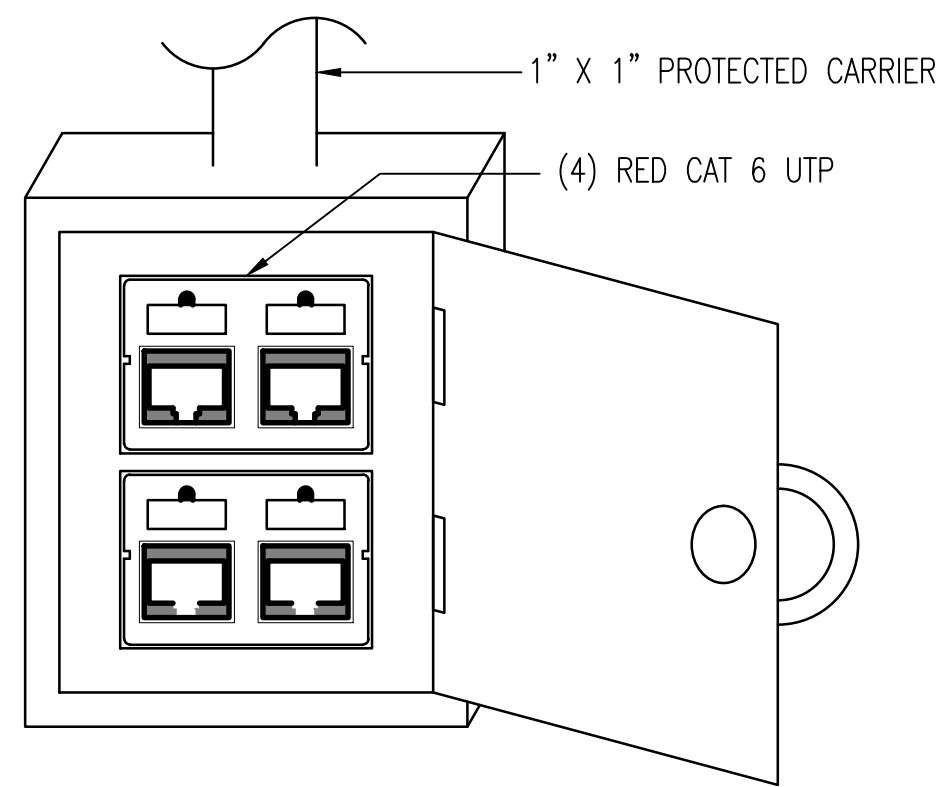



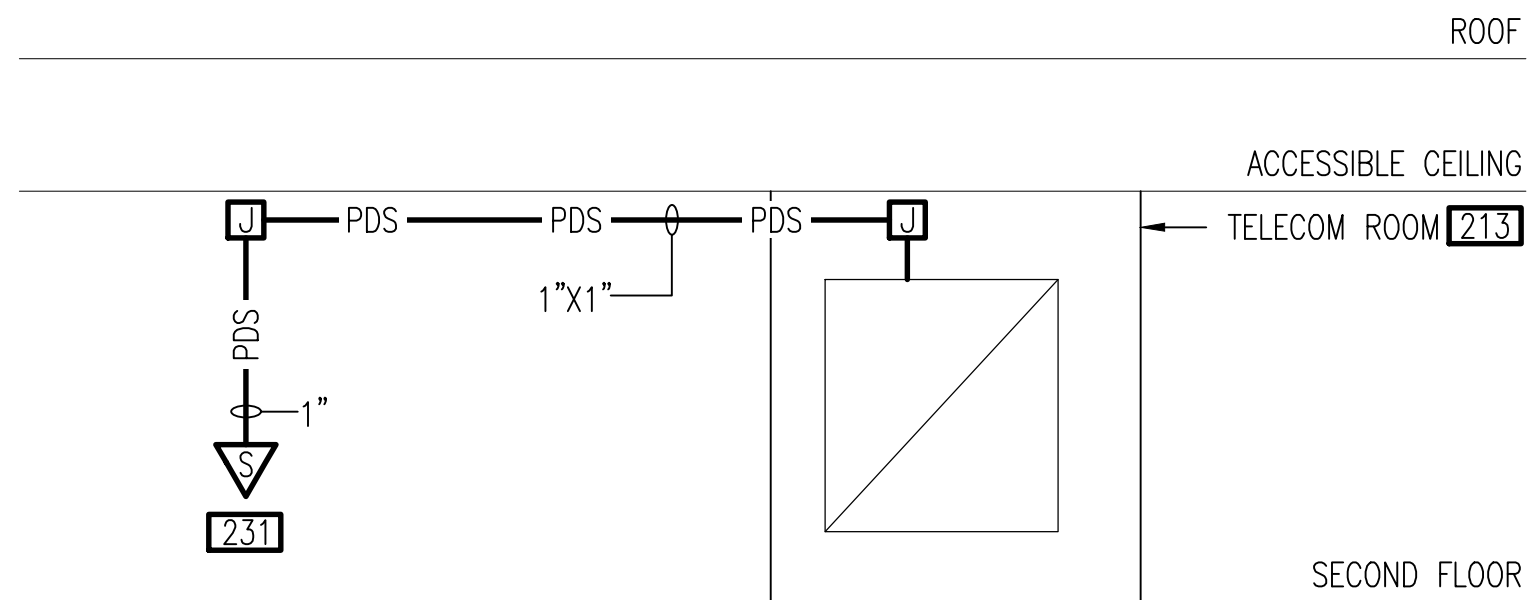

A1 SIPR DATA OUTLET W/LOCKABLE BOX
NO SCALE






A2 TELECOMMUNICATIONS RISER DIAGRAM
NO SCALE

TELECOMMUNICATIONS LEGEND

TELECOMMUNICATIONS

-  SIPR NETWORK OUTLET
-  PROTECTED DISTRIBUTION SYSTEM RACEWAY, 1"x1" UON.
-  PDS LOCKABLE JUNCTION BOX
-  POWER POLE. EXISTING TO REMAIN

GENERAL

-  WORK NOTE SYMBOL
-  **DETAIL**
 - DETAIL NUMBER
 - NAME
 - SCALE
 - SCALE: XXX
 - X-XXX
 - SHEET REFERENCED FROM
-  **PLAN**
 - DETAIL NUMBER
 - SCALE
 - SCALE: XXX
 - X-XXX
 - TITLE
 - SCALE
 - TRUE NORTH
 - SHEET REFERENCED FROM

ABBREVIATIONS

- PDS PROTECTED DISTRIBUTION SYSTEM
- UTP UNSHIELDED TWISTED PAIR
- SIPR SECURE INTERNET PROTOCOL ROUTER



APPROVED

FOR COMMANDER NAVFAC

ACTIVITY

SATISFACTORY TO

BES CRW DRW CAR CHK MHF

U.S. MARINE CORPS AIR STATION
CHERRY POINT, NORTH CAROLINA
INSTALL PDS CONDUIT & LOCK ROOM 231,
BUILDING 200
TELECOMMUNICATIONS - GENERAL NOTES, LEGEND, AND ABBREVIATIONS

SCALE: AS NOTED

PROJECT NO.: 7253050

MAXIMO WORK ORDER NO. 7253050

NAVFAC DRAWING NO. 12866829

SHEET 2 OF 3

T-001


UNCLASSIFIED//FOR OFFICIAL USE ONLY

A

D


C

B

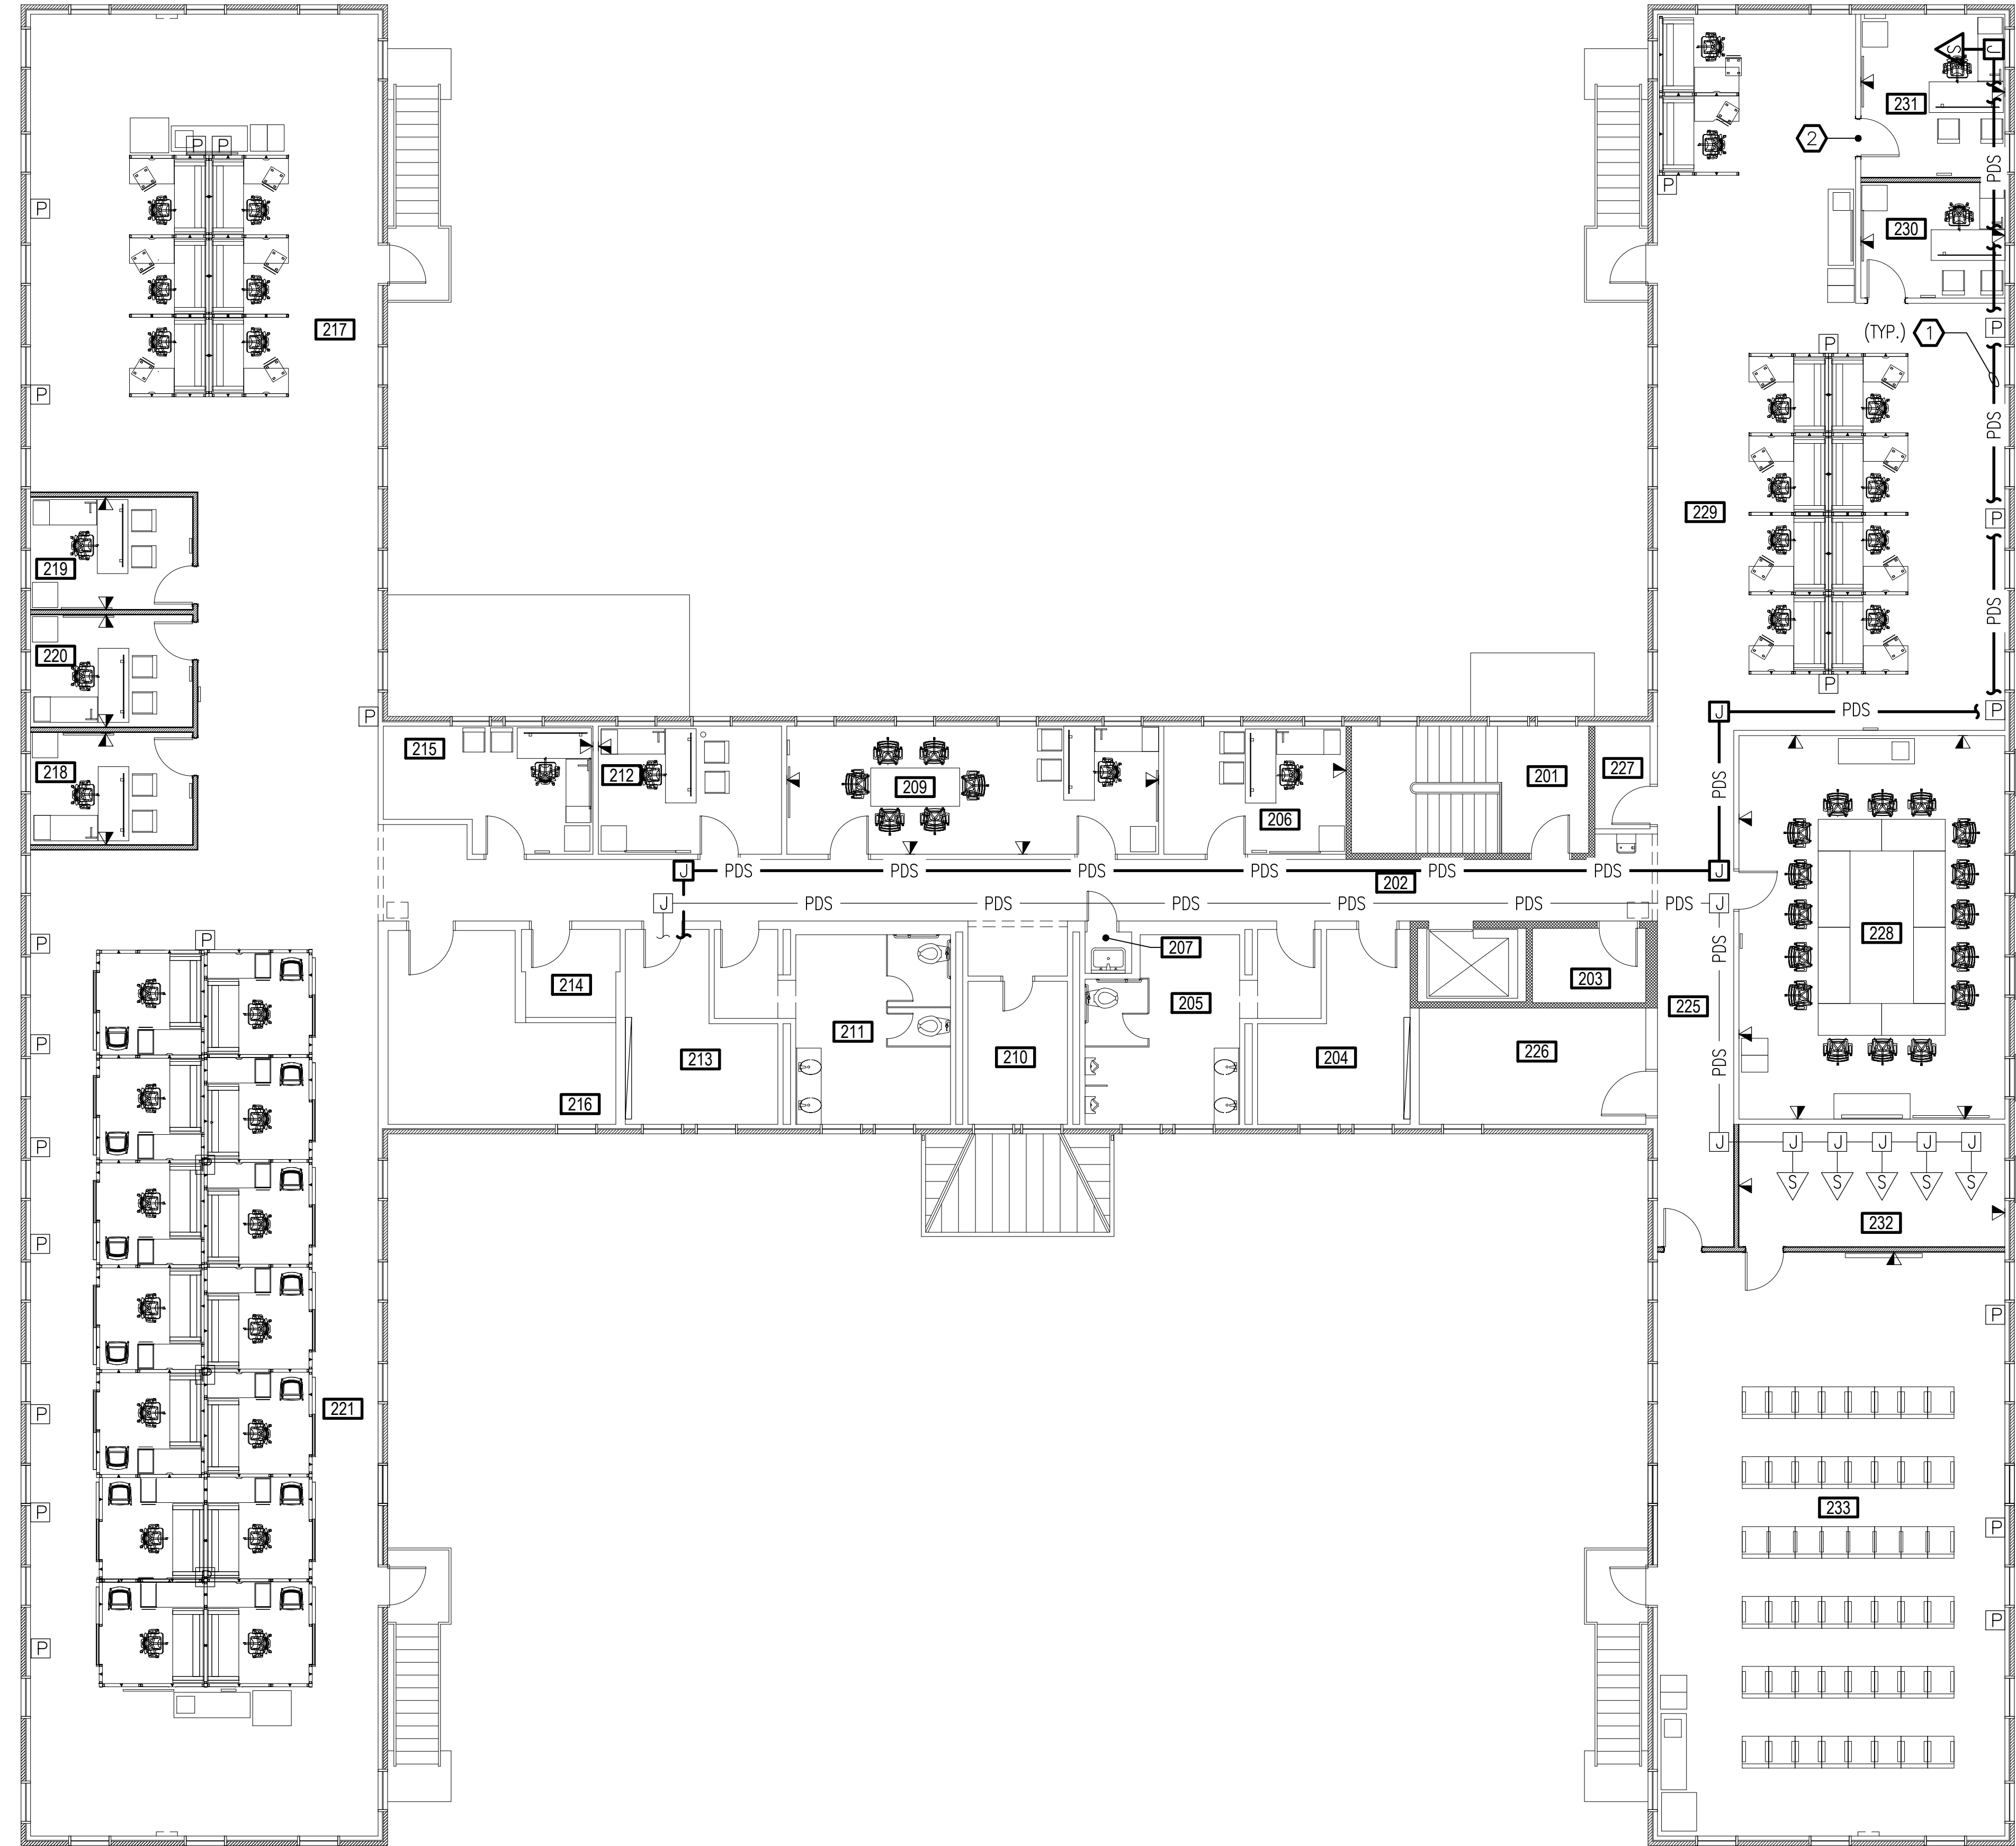

TELECOMMUNICATIONS SECOND FLOOR CONSTRUCTION PLAN

SCALE: 1/8" = 1'-0"

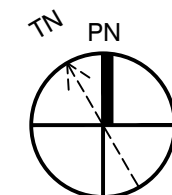


NOTES THIS SHEET

- 1 CONTRACTOR MUST COORDINATE WITH OWNER FOR EXACT PDS ROUTING AND SIPR OUTLET LOCATION PRIOR TO INSTALLATION.
- 2 CONTRACTOR MUST PROVIDE A UL437 DEADBOLT LOCK ON ROOM DOOR 231. COORDINATE LOCK INSTALLATION WITH OWNER PRIOR TO INSTALLATION.

ROOM SCHEDULE
SECOND FLOOR


201	STAIRS
202	CORRIDOR
203	STORAGE
204	COMM
205	MEN HEAD
206	SGT MAJ
207	JANITOR
208	
209	CO
210	DRC
211	WOMEN HEAD
212	XO
213	COMM
214	ELECT.
215	ADJ
216	MECH
217	S-1 LEGAL
218	LEGAL OIC
219	S1 CHIEF
220	CRS
221	GROUND SAFETY
222	
223	
224	
225	CORRIDOR
226	MECH
227	STORAGE
228	SECRET CONFERENCE
229	S-3 OPEN OFFICE
230	OPS CHIEF
231	OPS OIC
232	MAGTF PLANS
233	READY ROOM

 GRAPHIC SCALE:



U.S. MARINE CORPS AIR STATION
CHERRY POINT, NORTH CAROLINA
INSTALL PDS CONDUIT & LOCK ROOM 231,
BUILDING 200
TELECOMMUNICATIONS SECOND FLOOR CONSTRUCTION PLAN

SCALE: AS NOTED
PROJECT NO.: 7253050
MAXIMO WORK ORDER NO. 7253050
NAVFAC DRAWING NO. 12866830
SHEET 3 OF 3
T-101

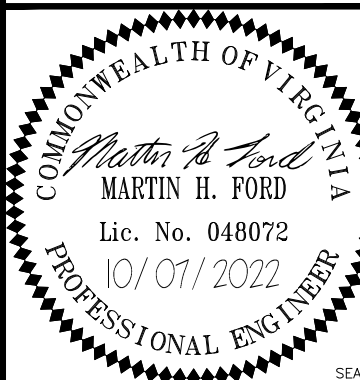

APPROVED

FOR COMMANDER NAVFAC

SATISFACTORY TO

DES CRW DRW CAR CHK MHF

ACTIVITY

DATE

SYN

DESCRIPTION

APPR

DATE

SYN

DESCRIPTION

APPR

DATE

SYN

DESCRIPTION