


SPRINKLER PIPING PLAN
SCALE: 1/8"=1'-0"

"FOR FIELD USE ONLY"

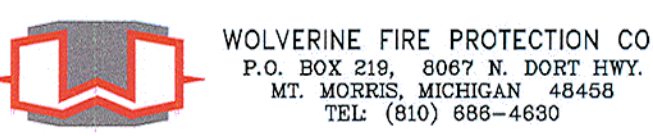

WOLVERINE FIRE PROTECTION CO.
P.O. BOX 219, 8067 N. DORT HWY.
MT. MORRIS, MICHIGAN 48458
TEL: (810) 688-4630

BILOXI VA ADMINISTRATION BLDG
BILOXI VA MEDICAL CENTER
BILOXI, MS
INSTALLATION IN LUMBERTON, NC
WET PIPE SYSTEM

Drawn: Date: Job No. Sheet No.
Scale: 3/16"=1'-0" UND. 2006-0645B/C 1 of 1

LOCATION:		SPRINKLERS											Rev	Date	Int	Description	Scope: XXXXX
SYSTEM DESIGN	SYN TOTAL	Make Model	Size Response	Finish Orientation	Temp. Description	SIN # Nominal K											
	⊕ 186	WVKG#	1/2" SR	ESD	150° RECESSED	54											
	○ 192	WVKG #	1/2" SR	BRASS UPRIGHT	150° N/A	54											
SYSTEM TYPE		"C" FACTOR		DESIGN AREA		SQ. FT.											
DENSITY		ASPRINKLERS		CALC.													
AREA PER SPRINKLER		OTHER															
HOSE ALLOWANCE																	
CALCULATION SUMMARY		SYSTEM DEMAND AT		GPM @		PSI											
WATER SUPPLY		STATIC		RESIDUAL		AT	GPM										