

PARTIAL MEZZANINE HAZARDOUS
MATERIALS REMOVALS PLAN

SCALE: 1/8"=1'-0"

PLAN
NORTH



GENERAL SHEET NOTES

- 1. SEE SHEET HD101 FOR ADDITIONAL NOTES.
- 2. ALL ITEMS ON THIS SHEET ARE EXISTING UNLESS NOTED OTHERWISE.

HAZARDOUS MATERIALS
ABATEMENT KEYNOTES

- 1 ABATE AND REMOVE ASBESTOS CONTAINING PIPE INSULATION. ASBESTOS-INSULATED SECTION OF STEAM PIPE (8 FEET LONG, WITH OVERALL DIAMETER (PIPE + INSULATION) OF 0.75 FEET) LOCATED ABOVE THE HARD CEILING OF THE SERVER ROOM. THE PIPE CAN BE ACCESSED VIA AN EXISTING STRAIGHT LADDER IN THE FIRE PUMP MECHANICAL ROOM UP TO THE PLYWOOD DECK OVER THE SERVER ROOM. THE DECK PROVIDES A LOAD-SUPPORTING WORK SURFACE TO ALLOW ABATEMENT OF THE INSULATION.

KEY PLAN

NOT TO SCALE

PLAN
NORTH



OAK POINT
ASSOCIATES

ARCHITECTURE ■ ENGINEERING ■ PLANNING
231 Main Street, Biddeford, Maine 04005 (F) 207.283.4283
www.oakpoint.com


DESIGNED BY: WVB
DRAWN BY: CRR
CHECKED BY: WVB
PROJECT: 21603.32
ePROJECT NO: 1591147

NAVAL FACILITIES ENGINEERING
COMMAND ~ MID-ATLANTIC
B79 - 2ND & 3RD
FLOOR RENOVATIONS
PORTSMOUTH NAVAL SHIPYARD
KITTERY, MAINE

PARTIAL
MEZZANINE
HAZARDOUS
MATERIALS
REMOVALS
PLAN

SCALE: AS NOTED
DATE: 03 APRIL 2023
REV: SK-A1
AMENDMENT
SKETCH

FILE NAME: T:\C:\P\Maine\Archives Folder (X)\VE\PortsmouthNavalShipyard\Archives\Digital Library (X\Archives)\CAD\Workload\B79 - 2nd & 3rd Flr Renov Amendment 0002_1591147_1591147_1591147_1591147_1591147.dwg LAYOUT NAME: ESK2 PLOTTED: Tuesday, April 04, 2023 - 7:17am USER: christopher.tardif

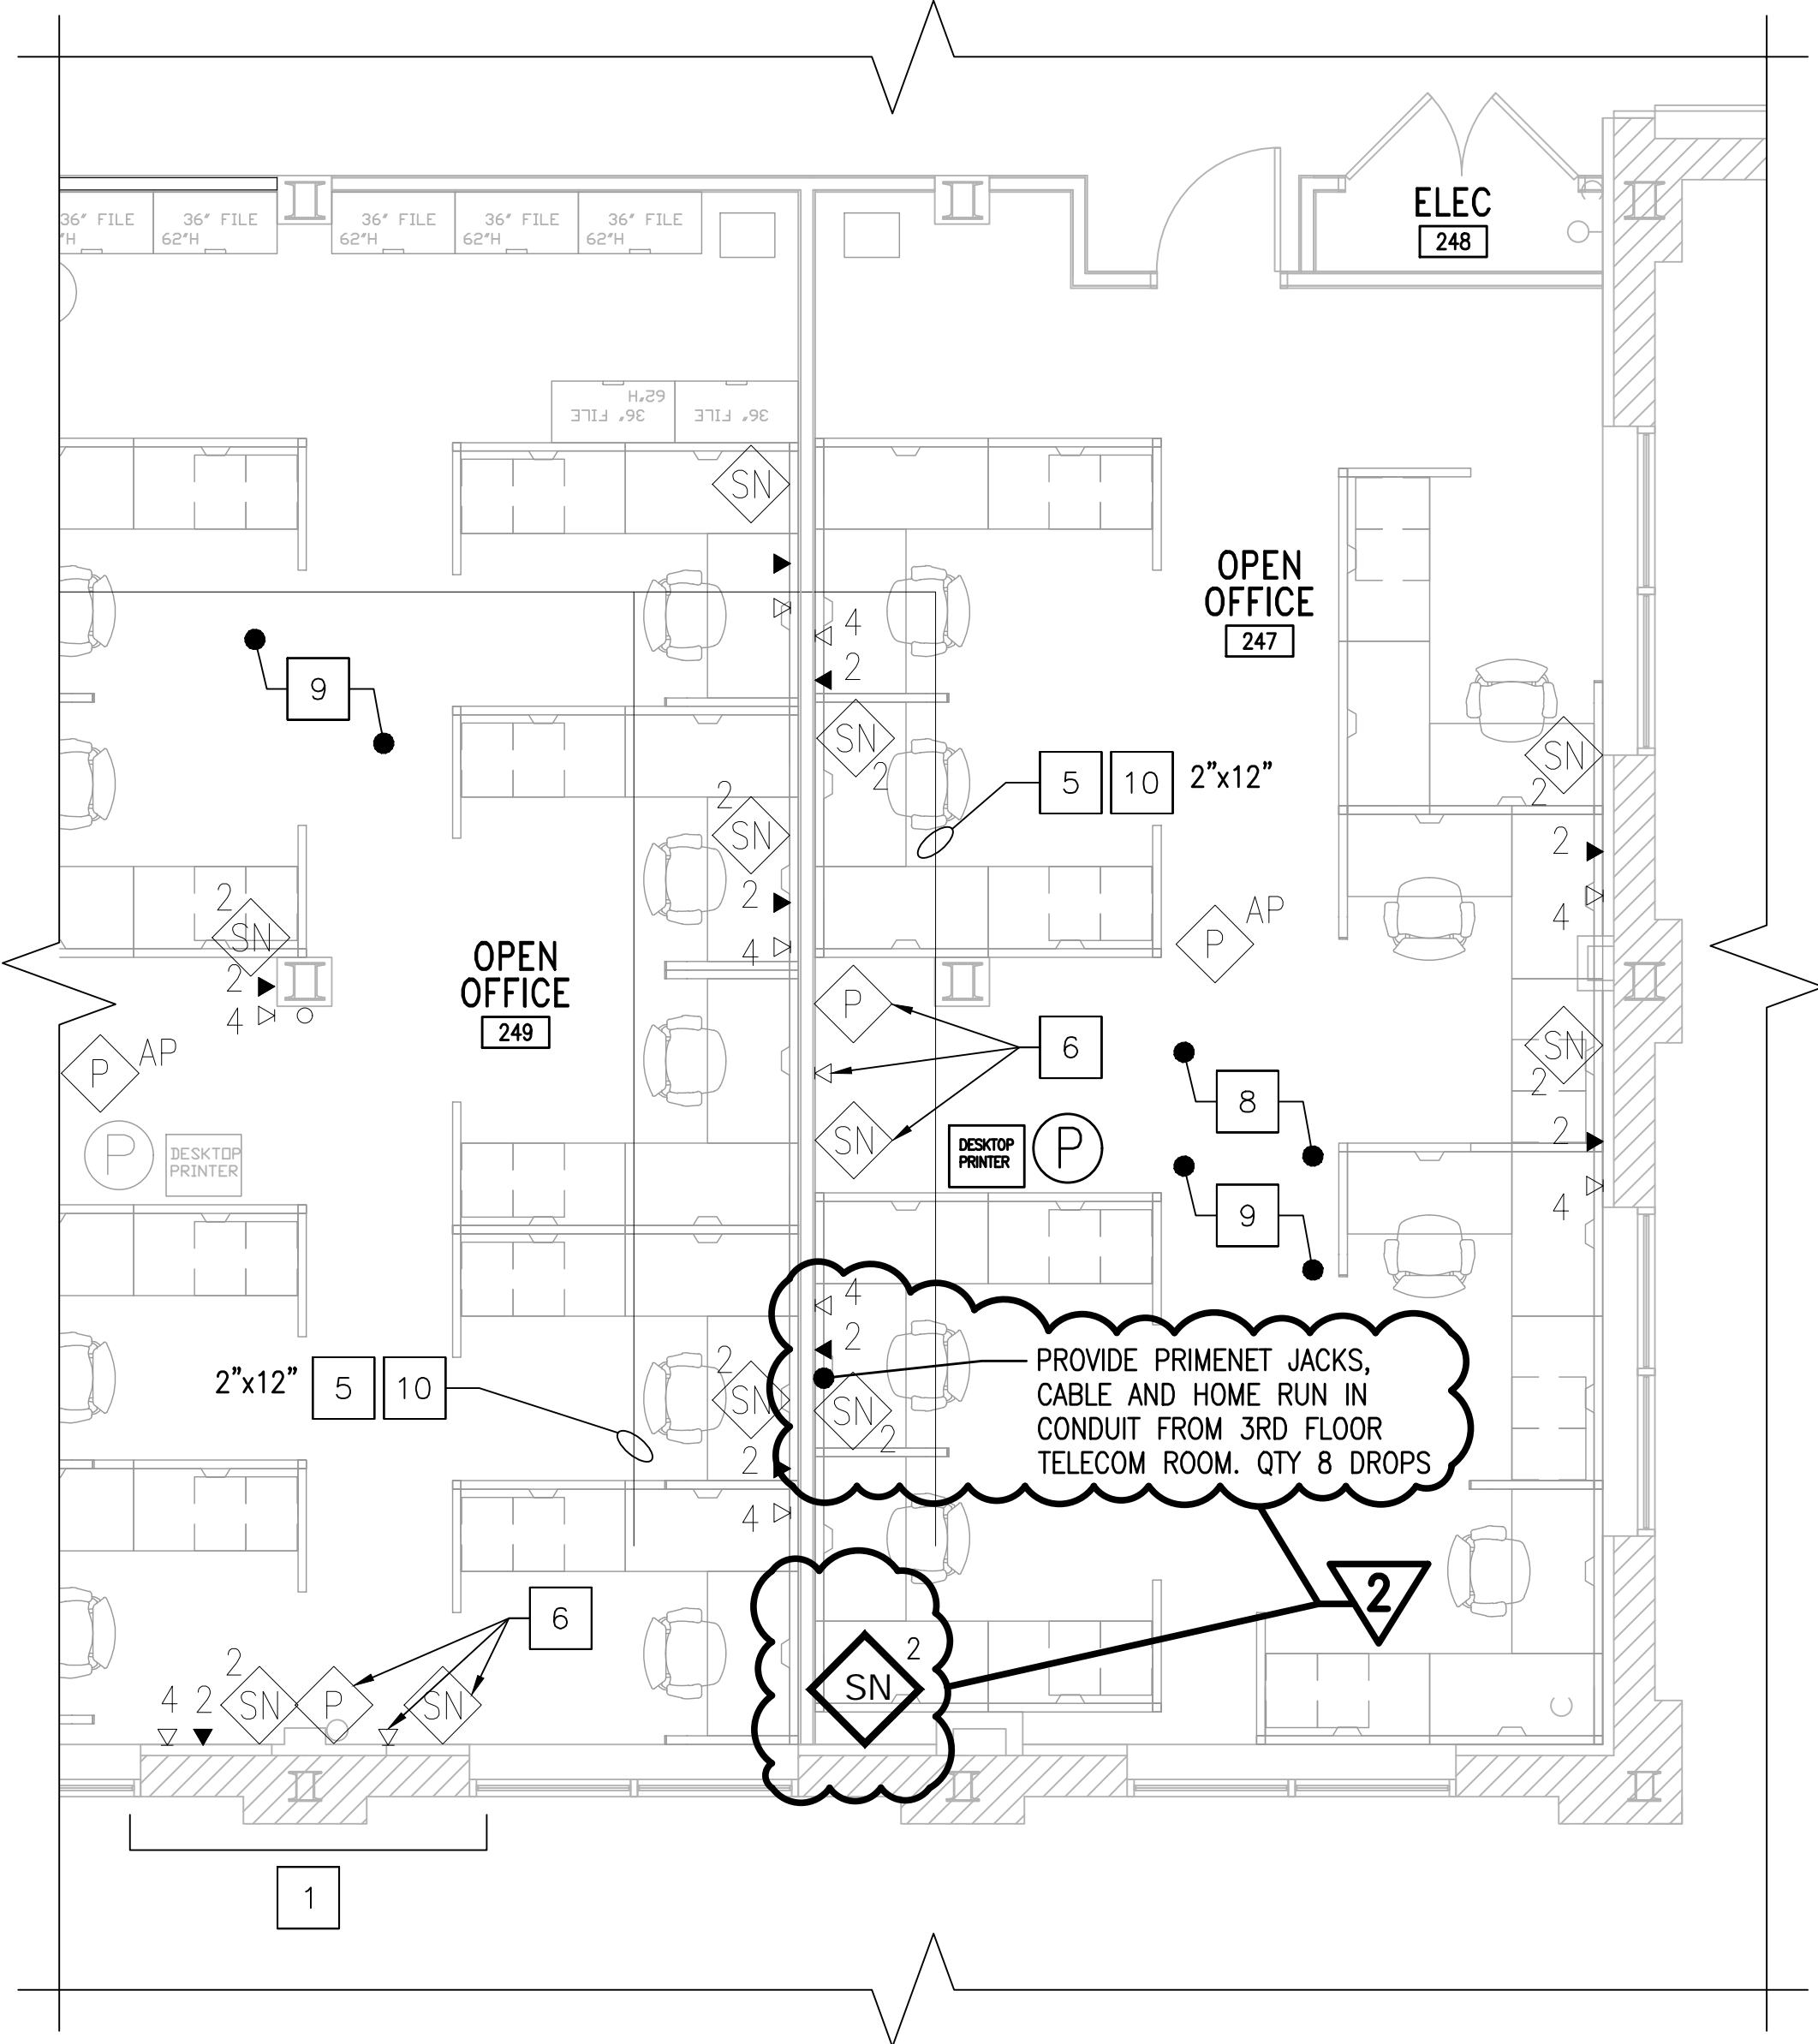

PARTIAL SECOND FLOOR TECHNOLOGY PLAN
SCALE: 1/4" = 1'-0"
PLAN NORTH
E1

GENERAL SHEET NOTES

1. THIS SHEET IDENTIFIES ADDITIONAL. SCOPE TO BE INCLUDED WITHIN PHASE 1.

KEY PLAN
SCALE: NOT TO SCALE
PLAN NORTH

GRAPHIC SCALE

1/4" = 1' scale
CHECK GRAPHIC SCALE BEFORE USING

NAVFAC

SEAL

PWD-MAINE
IN HOUSE DESIGN

APPROVED
FOR COMMANDER NAVFAC
ACTIVITY
SATISFACTORY TO
DESIGNER: ROB BRINK
DRAWN BY: CHRIS TARDIF
CHECKED BY: ROB BRINK
DESIGN MANAGER: ROB BRINK
PROJECT MANAGER: ROBERT WESTHELLE
TEAM/PM/ME: JEFF HOYT
FIRE PROTECTION: SHELDON RUCINSKI

DEPARTMENT OF THE NAVY
NAVAL FACILITIES ENGINEERING SYSTEMS COMMAND
PUBLIC WORKS DEPARTMENT - MAINE
PORTSMOUTH NAVAL SHIPYARD
KITTEERY, MAINE
B79 - 2ND & 3RD FLOOR RENOVATIONS
PARTIAL SECOND FLOOR TECHNOLOGY PLANS

PROJECT NO.: 1591147
NAVFAC DRAWING NO.
SHEET 0F
ESK-2

AMENDMENT 0003
04/04/2023
ML
AMENDMENT 0002
03/14/2023
ML
DESCRIPTION
DATE
APP

UNCLASSIFIED