






F1 PLUMBING UNDERSLAB GRAVITY PLAN - LEVEL B
1/4" = 1'-0"

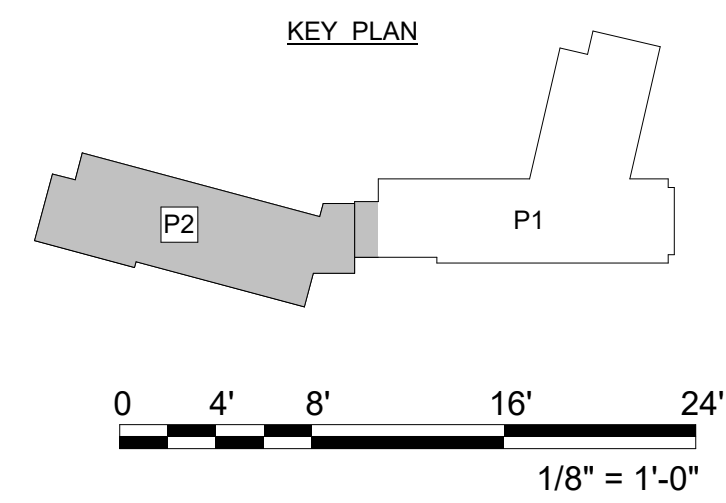


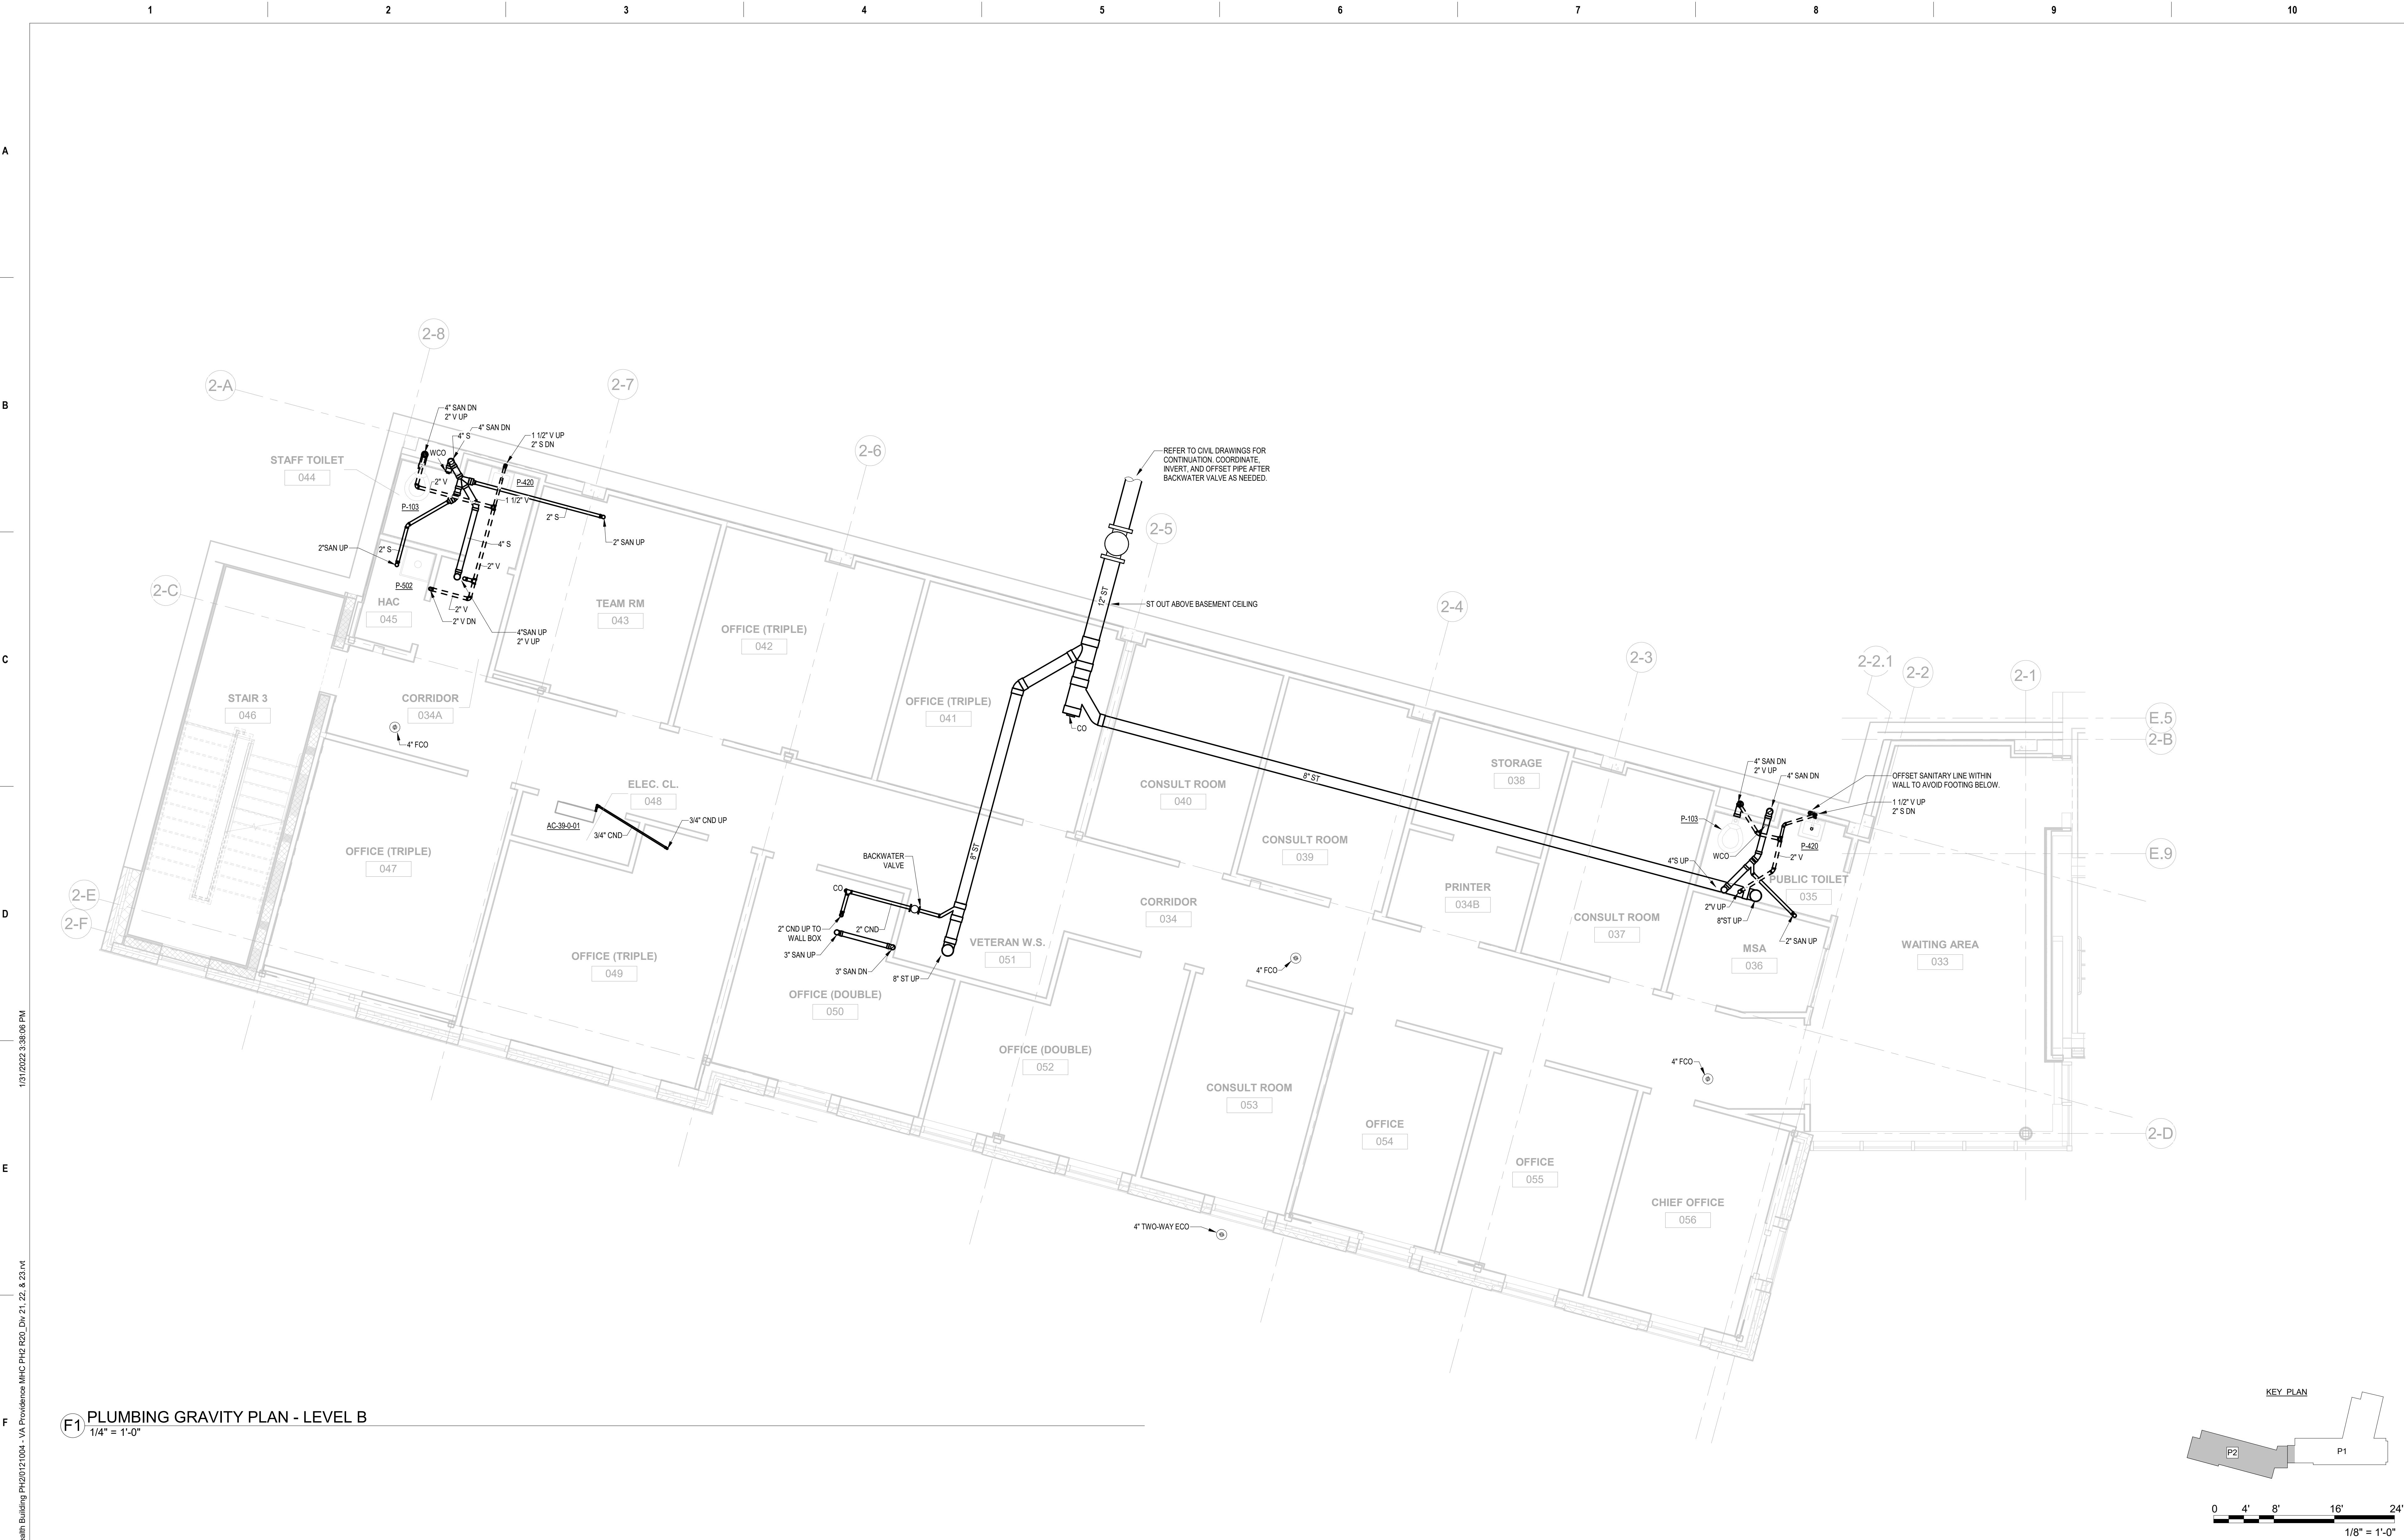



		ENGINEER ENGINEERING DESIGN CONSULTING www.abovegroupinc.com COA/CA Lic. No. 31120	ARCHITECT/ENGINEER OF RECORD ARCHITECTS • ENGINEERS www.wbrcae.com BANGOR, MAINE 207-947-4511 PORTLAND, MAINE 207-838-4511 SARASOTA, FLORIDA 941-556-0757	STAMP 	Office of Construction and Facilities Management U.S. Department of Veterans Affairs	Drawing Title PLUMBING GRAVITY - LEVEL B UNDERSLAB PLAN Approved:	Phase CONSTRUCTION DOCUMENTS FULLY SPRINKLERED	Project Title PROVIDENCE VAMC MENTAL HEALTH PHASE 2 Location PROVIDENCE, RI Issue Date FEB 04 2022	Checked ADL	Drawn AJZ	Project Number 650-347 Building Number 39 Drawing Number PS101
	Revisions:	Revision Description	Date:								

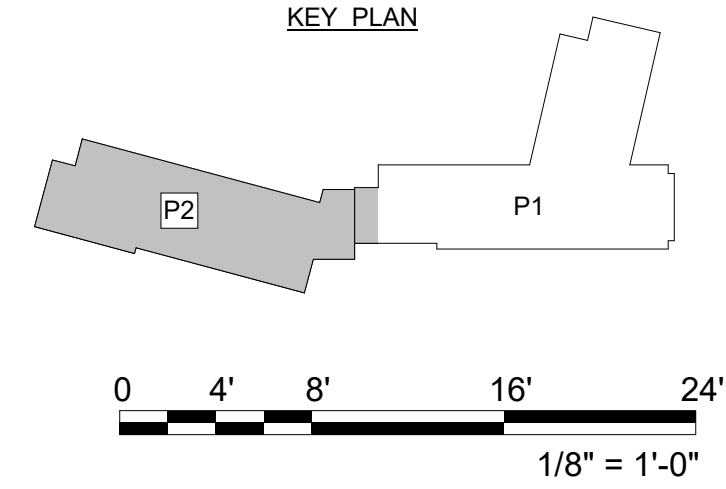


F1 PLUMBING GRAVITY PLAN - LEVEL B
1/4" = 1'-0"

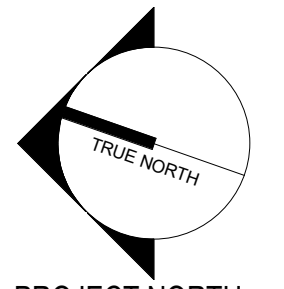


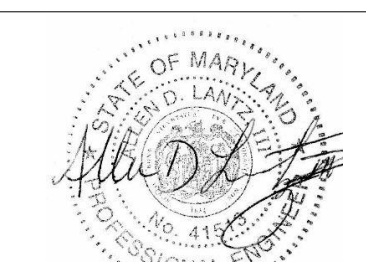 PROJECT NORTH	<table><tr><th>Revisions:</th><th>Revision Description</th><th>Date:</th></tr><tr><td> </td><td> </td><td> </td></tr><tr><td> </td><td> </td><td> </td></tr><tr><td> </td><td> </td><td> </td></tr><tr><td> </td><td> </td><td> </td></tr><tr><td> </td><td> </td><td> </td></tr></table>	Revisions:	Revision Description	Date:																ENGINEER  www.abovegroupinc.com COA/CA Lic. No. 31120 305 East Dr., Suite H, Melbourne, Florida 32904 PH: 321.345.9026	ARCHITECT/ENGINEER OF RECORD  WWW.WBRCAE.COM BANGOR, MAINE 207-947-4511 PORTLAND, MAINE 207-838-4511 SARASOTA, FLORIDA 941-556-0757	STAMP  Allen D. Lantz, P.E. MD License #41513	Office of Construction and Facilities Management  U.S. Department of Veterans Affairs	Drawing Title PLUMBING GRAVITY - LEVEL B PLAN Approved: _____	Phase CONSTRUCTION DOCUMENTS FULLY SPRINKLERED	Project Title PROVIDENCE VAMC MENTAL HEALTH PHASE 2 Location PROVIDENCE, RI Issue Date FEB 04 2022	Checked ADL Drawn AJZ	Project Number 650-347 Building Number 39 Drawing Number PS111
		Revisions:	Revision Description	Date:																								
VA FORM 08-6231																												

- CODED NOTES:
- ① 8" STO DN TO DOWNSPOUT. REFER TO DETAIL 9P-901.
- ② ROUTE 2" STORM PIPING BETWEEN STRUCTURAL BEAMS AS NECESSARY. OFFSET PIPING AS NECESSARY.

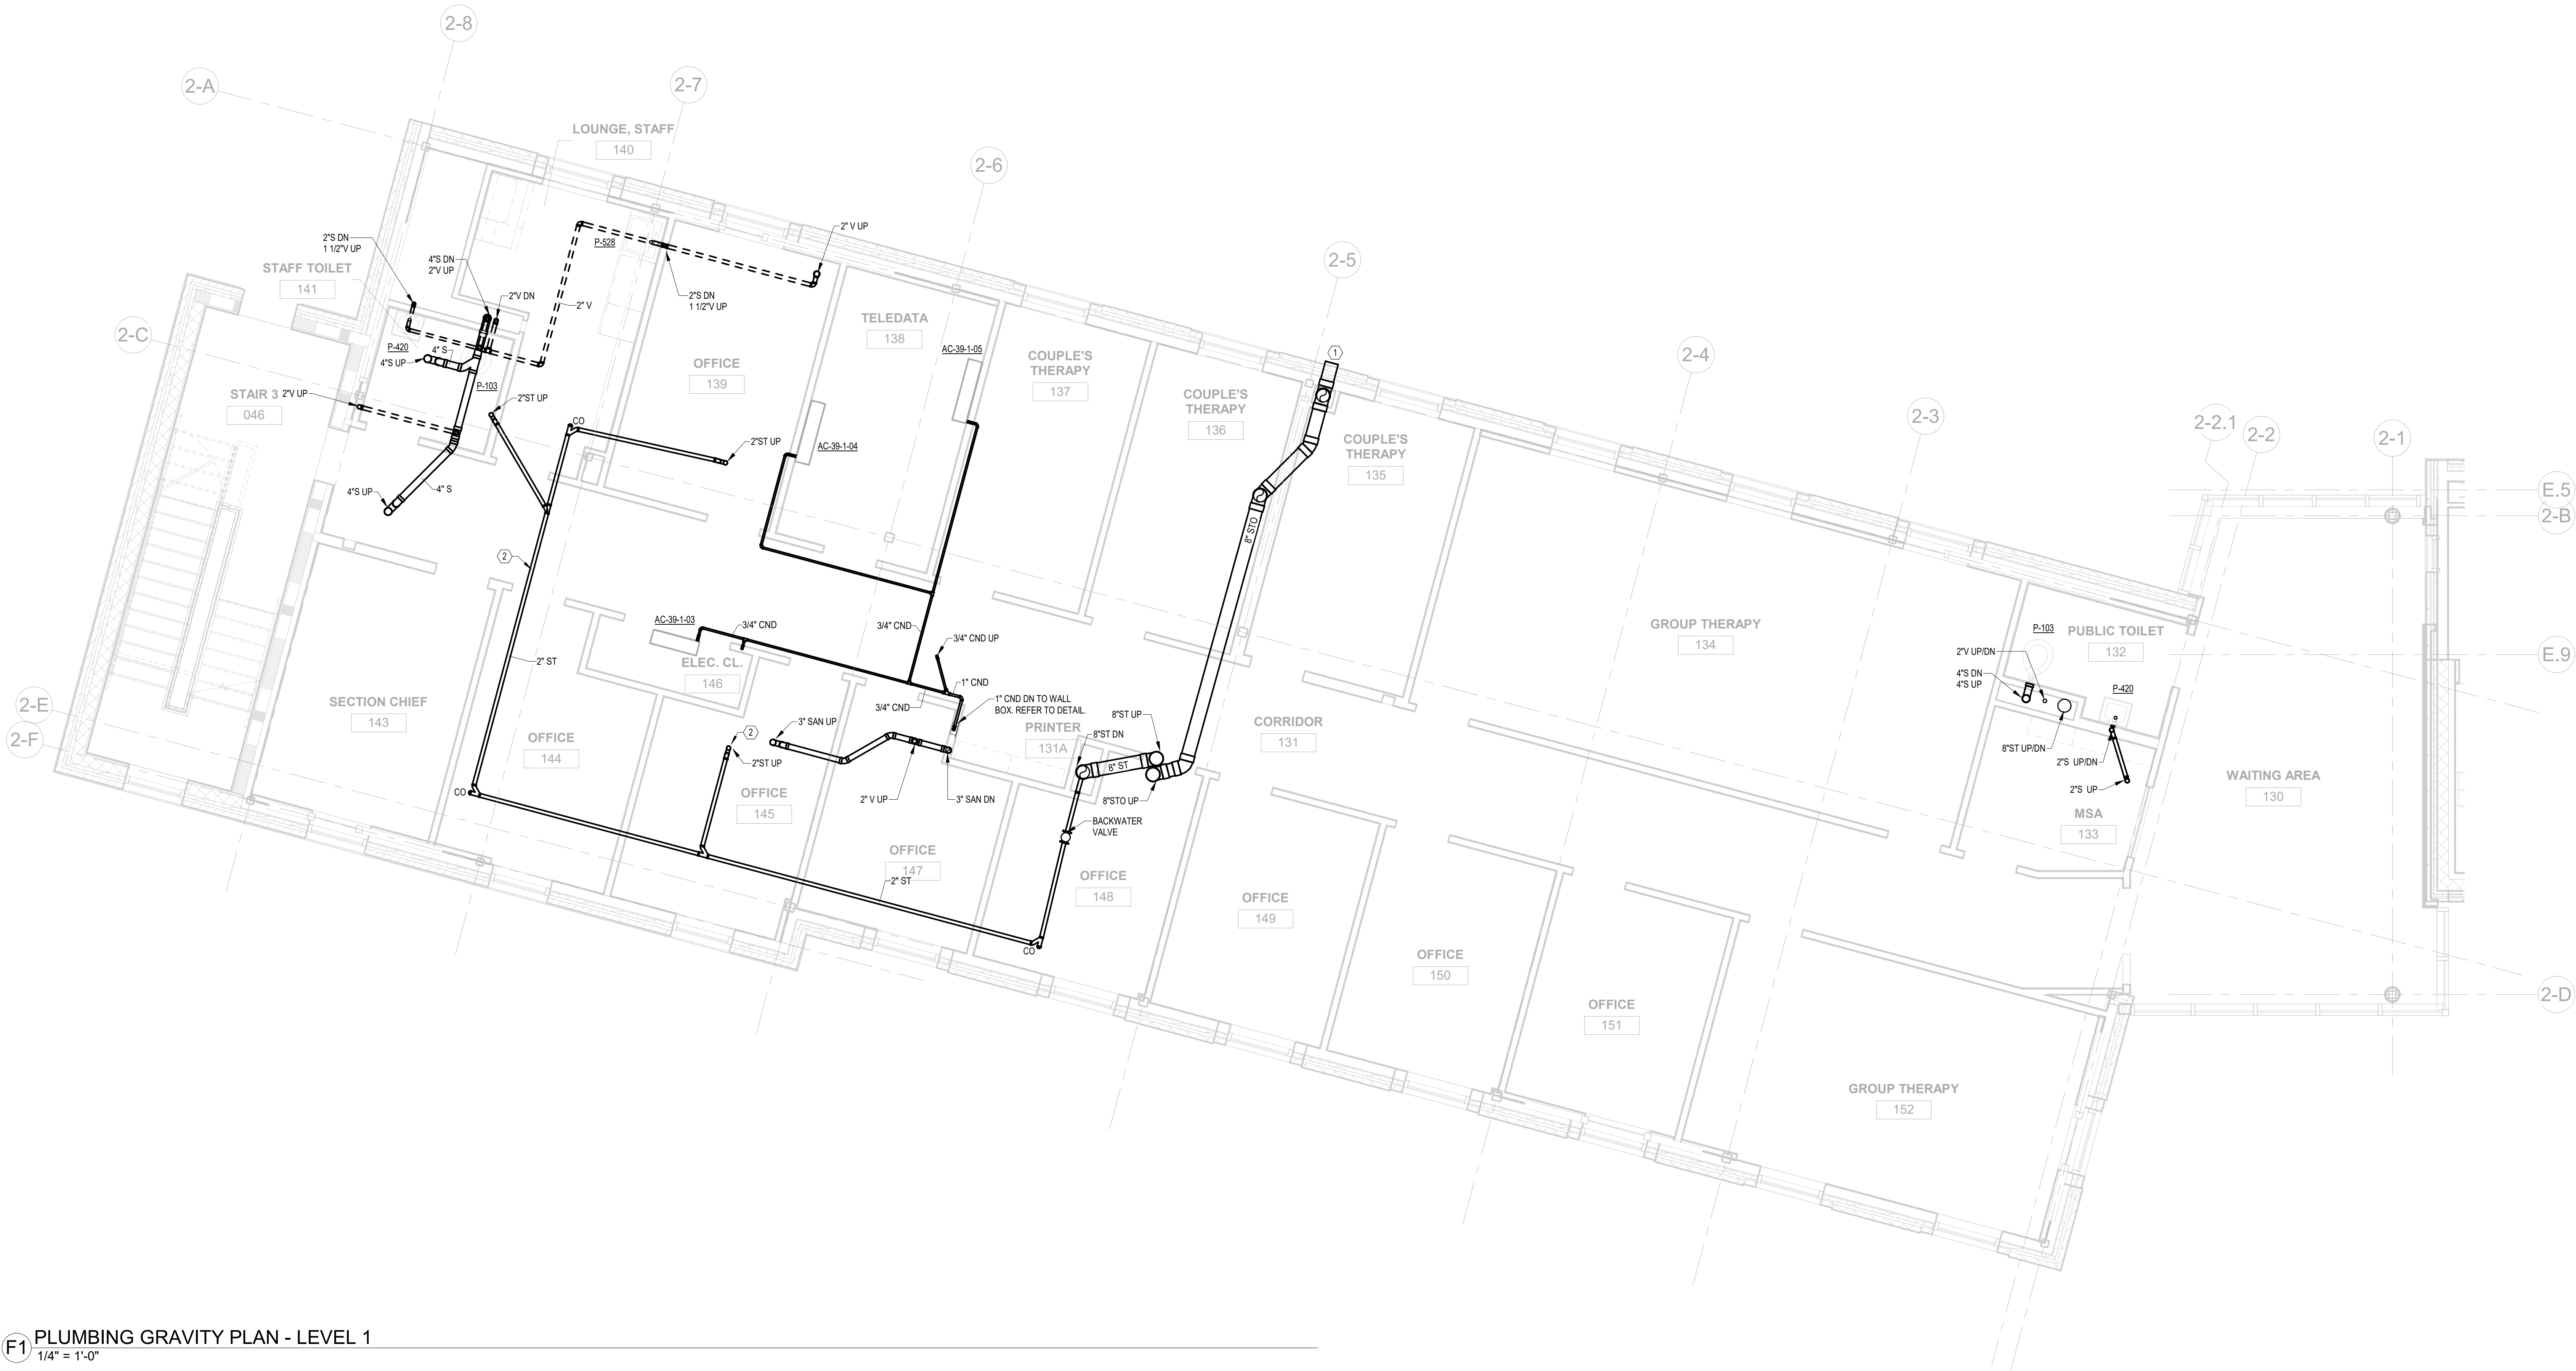


F1 PLUMBING GRAVITY PLAN - LEVEL 1
1/4" = 1'-0"

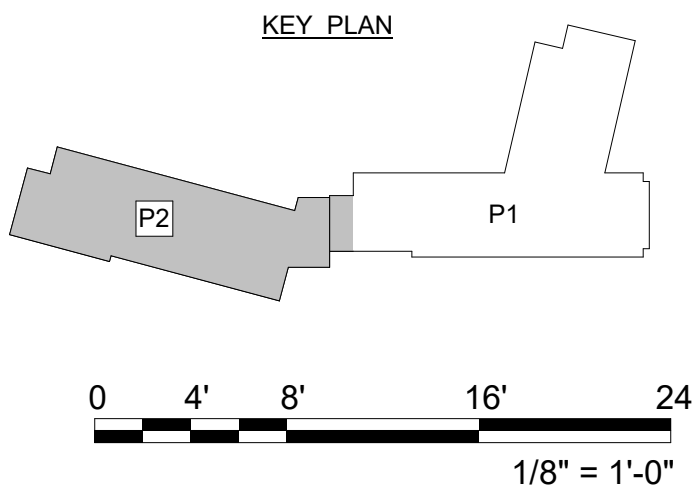

	<table><tr><th>Revisions:</th><th>Revision Description</th><th>Date:</th></tr><tr><td> </td><td> </td><td> </td></tr><tr><td> </td><td> </td><td> </td></tr><tr><td> </td><td> </td><td> </td></tr><tr><td> </td><td> </td><td> </td></tr><tr><td> </td><td> </td><td> </td></tr></table>	Revisions:	Revision Description	Date:																ENGINEER ENGINEERING DESIGN CONSULTING www.abovegroupinc.com COA/CA Lic. No. 31120 305 East Dr., Suite H, Melbourne, Florida 32904 PH: 321.345.9026	ARCHITECT/ENGINEER OF RECORD ARCHITECTS • ENGINEERS www.wbrcae.com BANGOR, MAINE 207-947-4511 PORTLAND, MAINE 207-838-4511 SARASOTA, FLORIDA 941-556-0757	STAMP Allen D. Lantz, P.E. MD License #41513	Office of Construction and Facilities Management U.S. Department of Veterans Affairs	Drawing Title PLUMBING GRAVITY - LEVEL 1 PLAN Approved: _____	Phase CONSTRUCTION DOCUMENTS FULLY SPRINKLERED	Project Title PROVIDENCE VAMC MENTAL HEALTH PHASE 2 Location PROVIDENCE, RI Issue Date FEB 04 2022	Checked ADL Drawn AJZ	Project Number 650-347 Building Number 39 Drawing Number PS121
		Revisions:	Revision Description	Date:																								
VA FORM 08 - 6231																												


- CODING NOTES:
- ① 3" VENT PIPING UP TO ROOF. REFER TO SHEET PS141 FOR CONTINUATION.
 - ② CONDENSATE PIPING DISCHARGING TO FLOOR DRAIN.

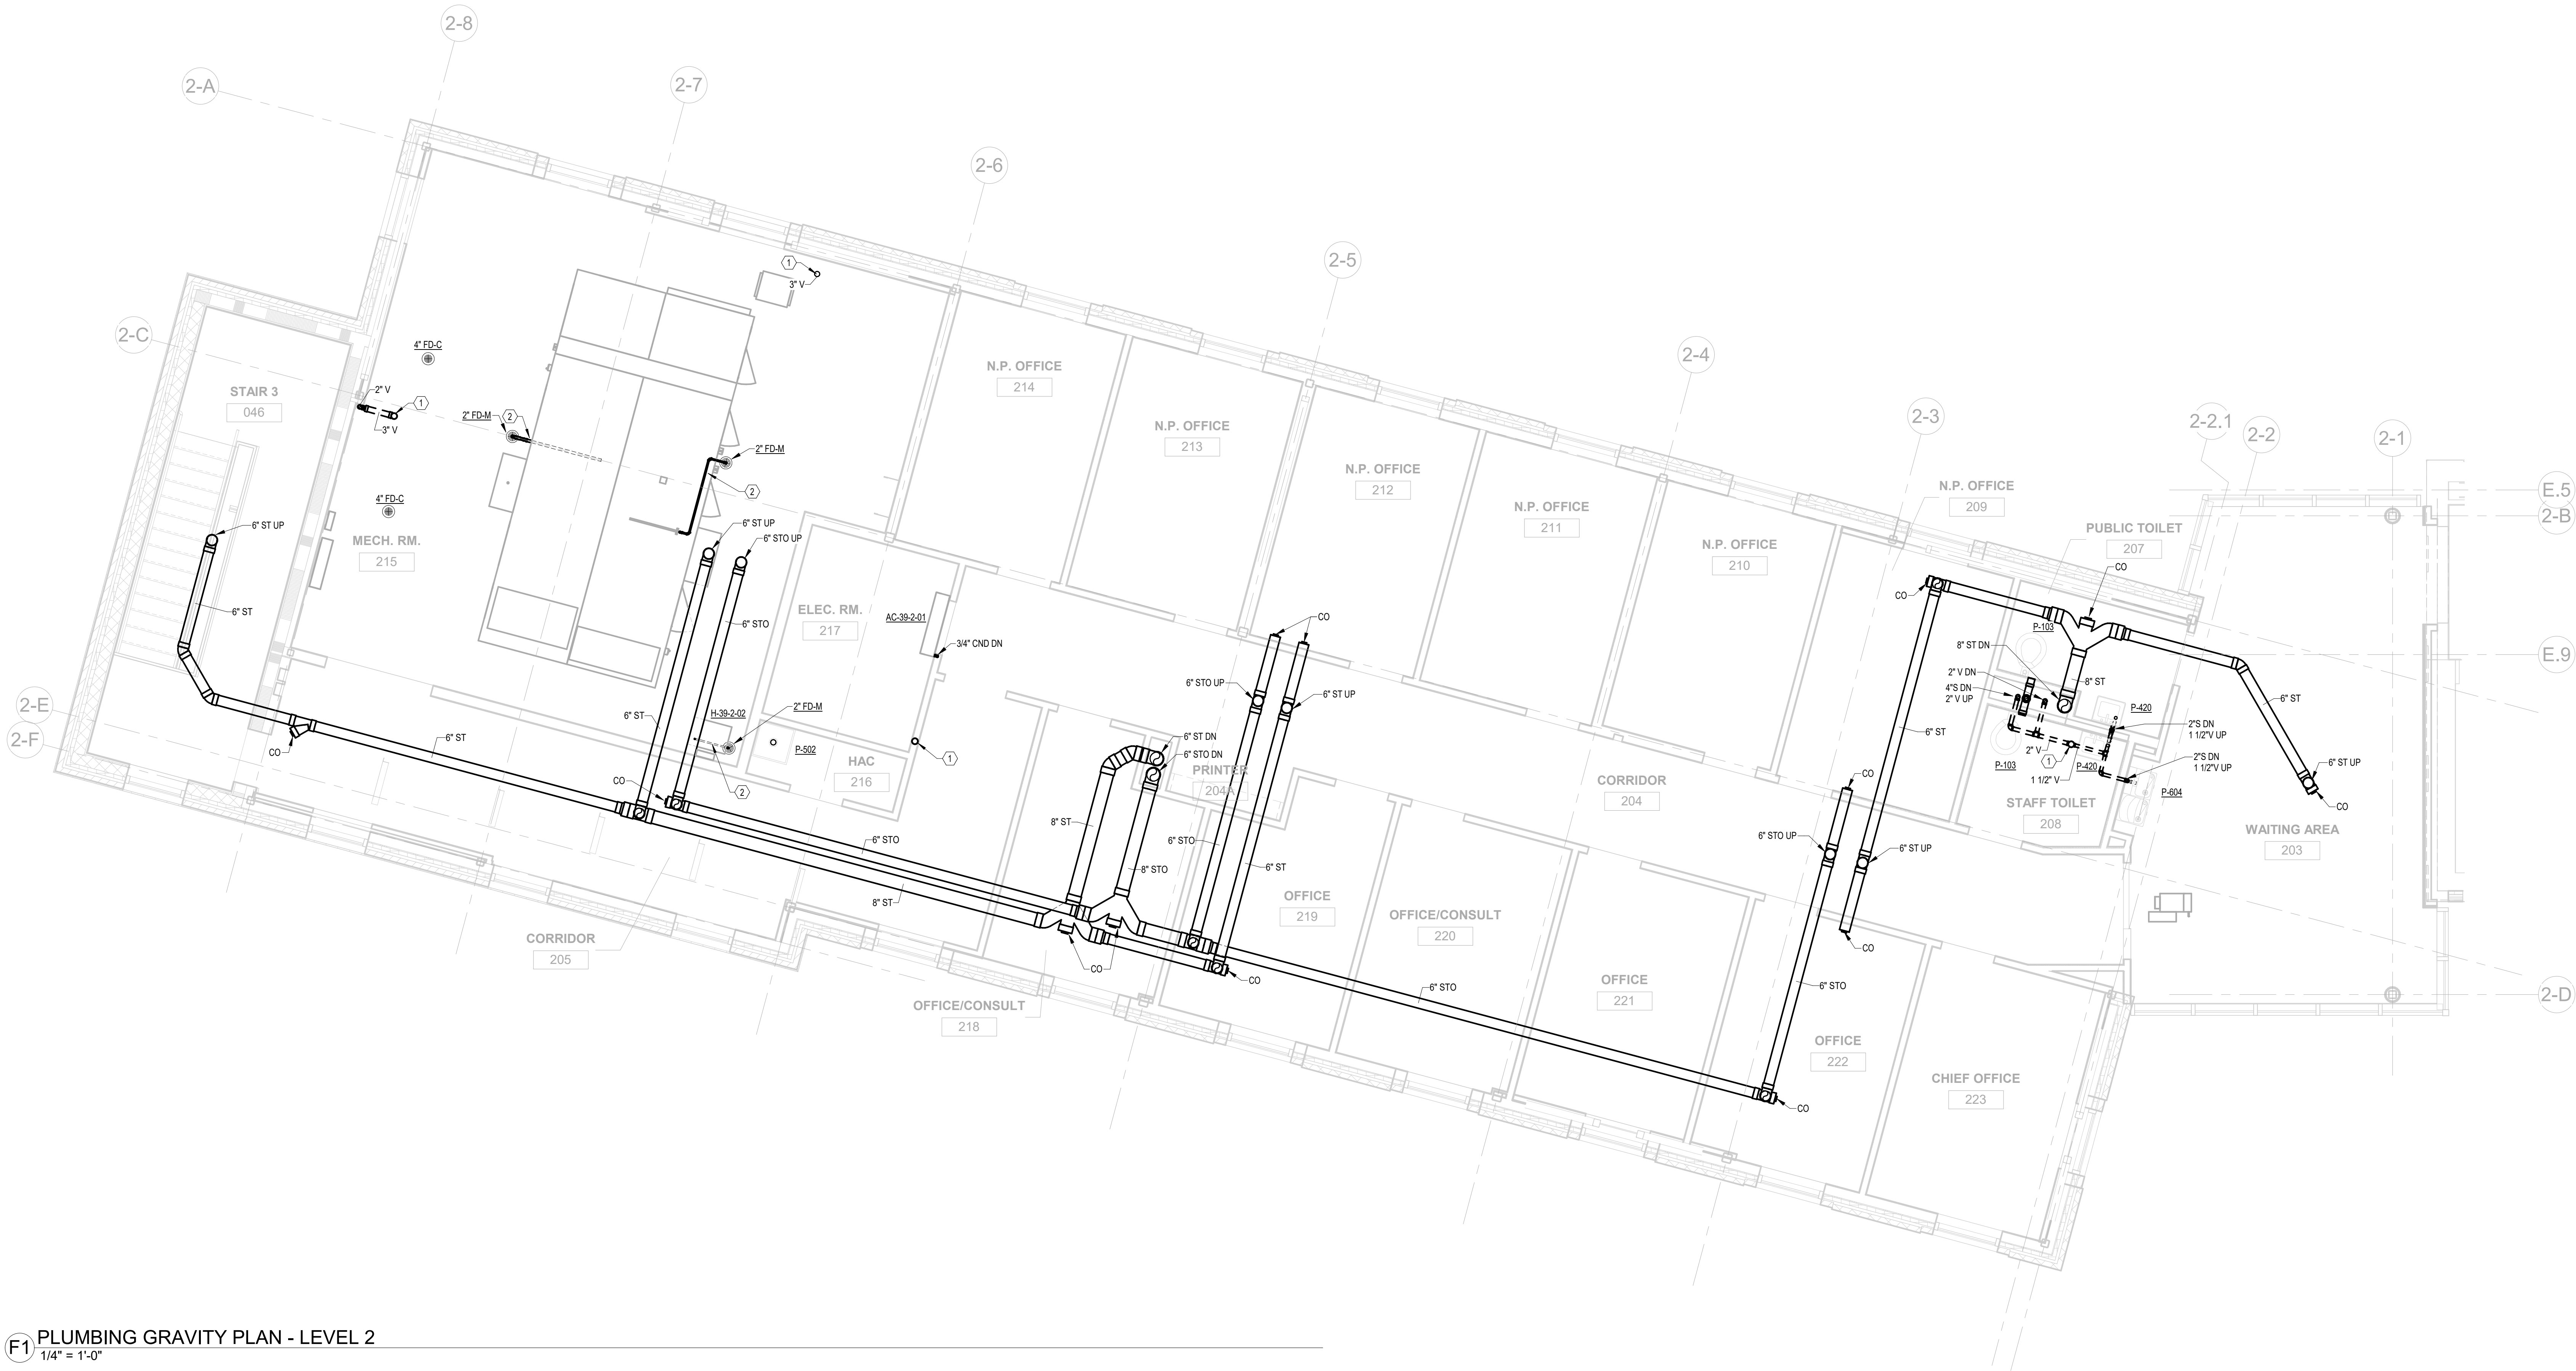

F1 PLUMBING GRAVITY PLAN - LEVEL 2
1/4" = 1'-0"

KEY PLAN

0 4' 8' 16' 24'
1/8" = 1'-0"

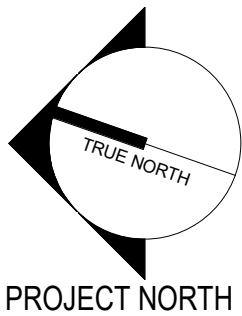

Revisions:	Revision Description	Date:

ENGINEER



www.abovegroupinc.com
COA/CA Lic. No. 31120


305 East Dr., Suite H,
Melbourne, Florida 32904
PH: 321.345.9026

ARCHITECT/ENGINEER OF RECORD



WWW.WBRCAE.COM
BANGOR, MAINE 207-947-4511
PORTLAND, MAINE 207-838-4511
SARASOTA, FLORIDA 941-556-0757

STAMP

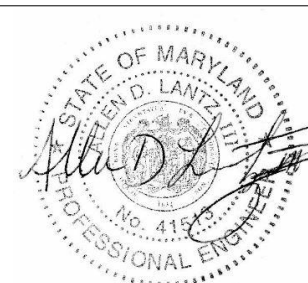

Allen D. Lantz, P.E.
MD License #41513

Office of
Construction
and Facilities
Management



U.S. Department
of Veterans Affairs

Drawing Title

PLUMBING GRAVITY - LEVEL 2
PLAN

Approved:

Phase

CONSTRUCTION
DOCUMENTS

FULLY SPRINKLERED

Project Title

PROVIDENCE VAMC MENTAL
HEALTH PHASE 2

Location
PROVIDENCE, RI

Issue Date
FEB 04 2022

Checked
ADL

Drawn
AJZ

Project Number

650-347


Building Number
39

Drawing Number

PS131

1/31/2022 3:38:09 PM

BM 36010121004 - VA Providence Mental Health Building PH120121004 - VA Providence MHC Ph2 120_Div 21_22_ & 23.rvt

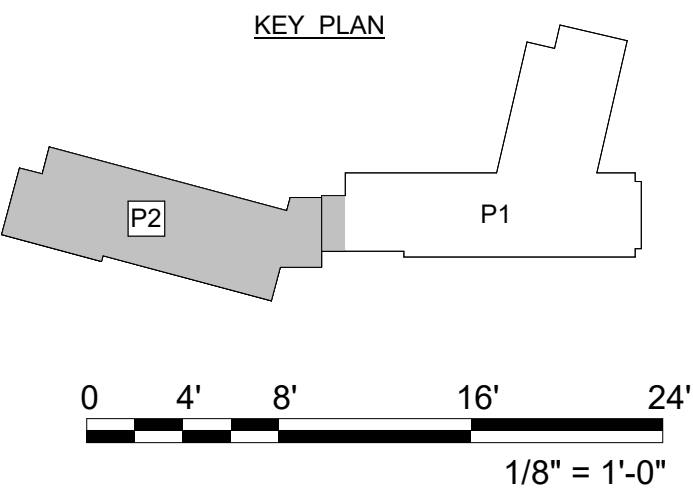

1/31/2022 3:38:10 PM


VA FORM 08-6231

**Office of
Construction
and Facilities
Management**

VA | U.S. Department
of Veterans Affairs

Phase	CONSTRUCTION DOCUMENTS
	FULLY SPRINKLERED


Project Title PROVIDENCE VAMC MENTAL HEALTH PHASE 2			Project Number 650-347	
Location PROVIDENCE, RI			Building Number 39	
Issue Date FEB 04 2022			Checked ADL	Drawn AJZ
			Drawing Number PS141	

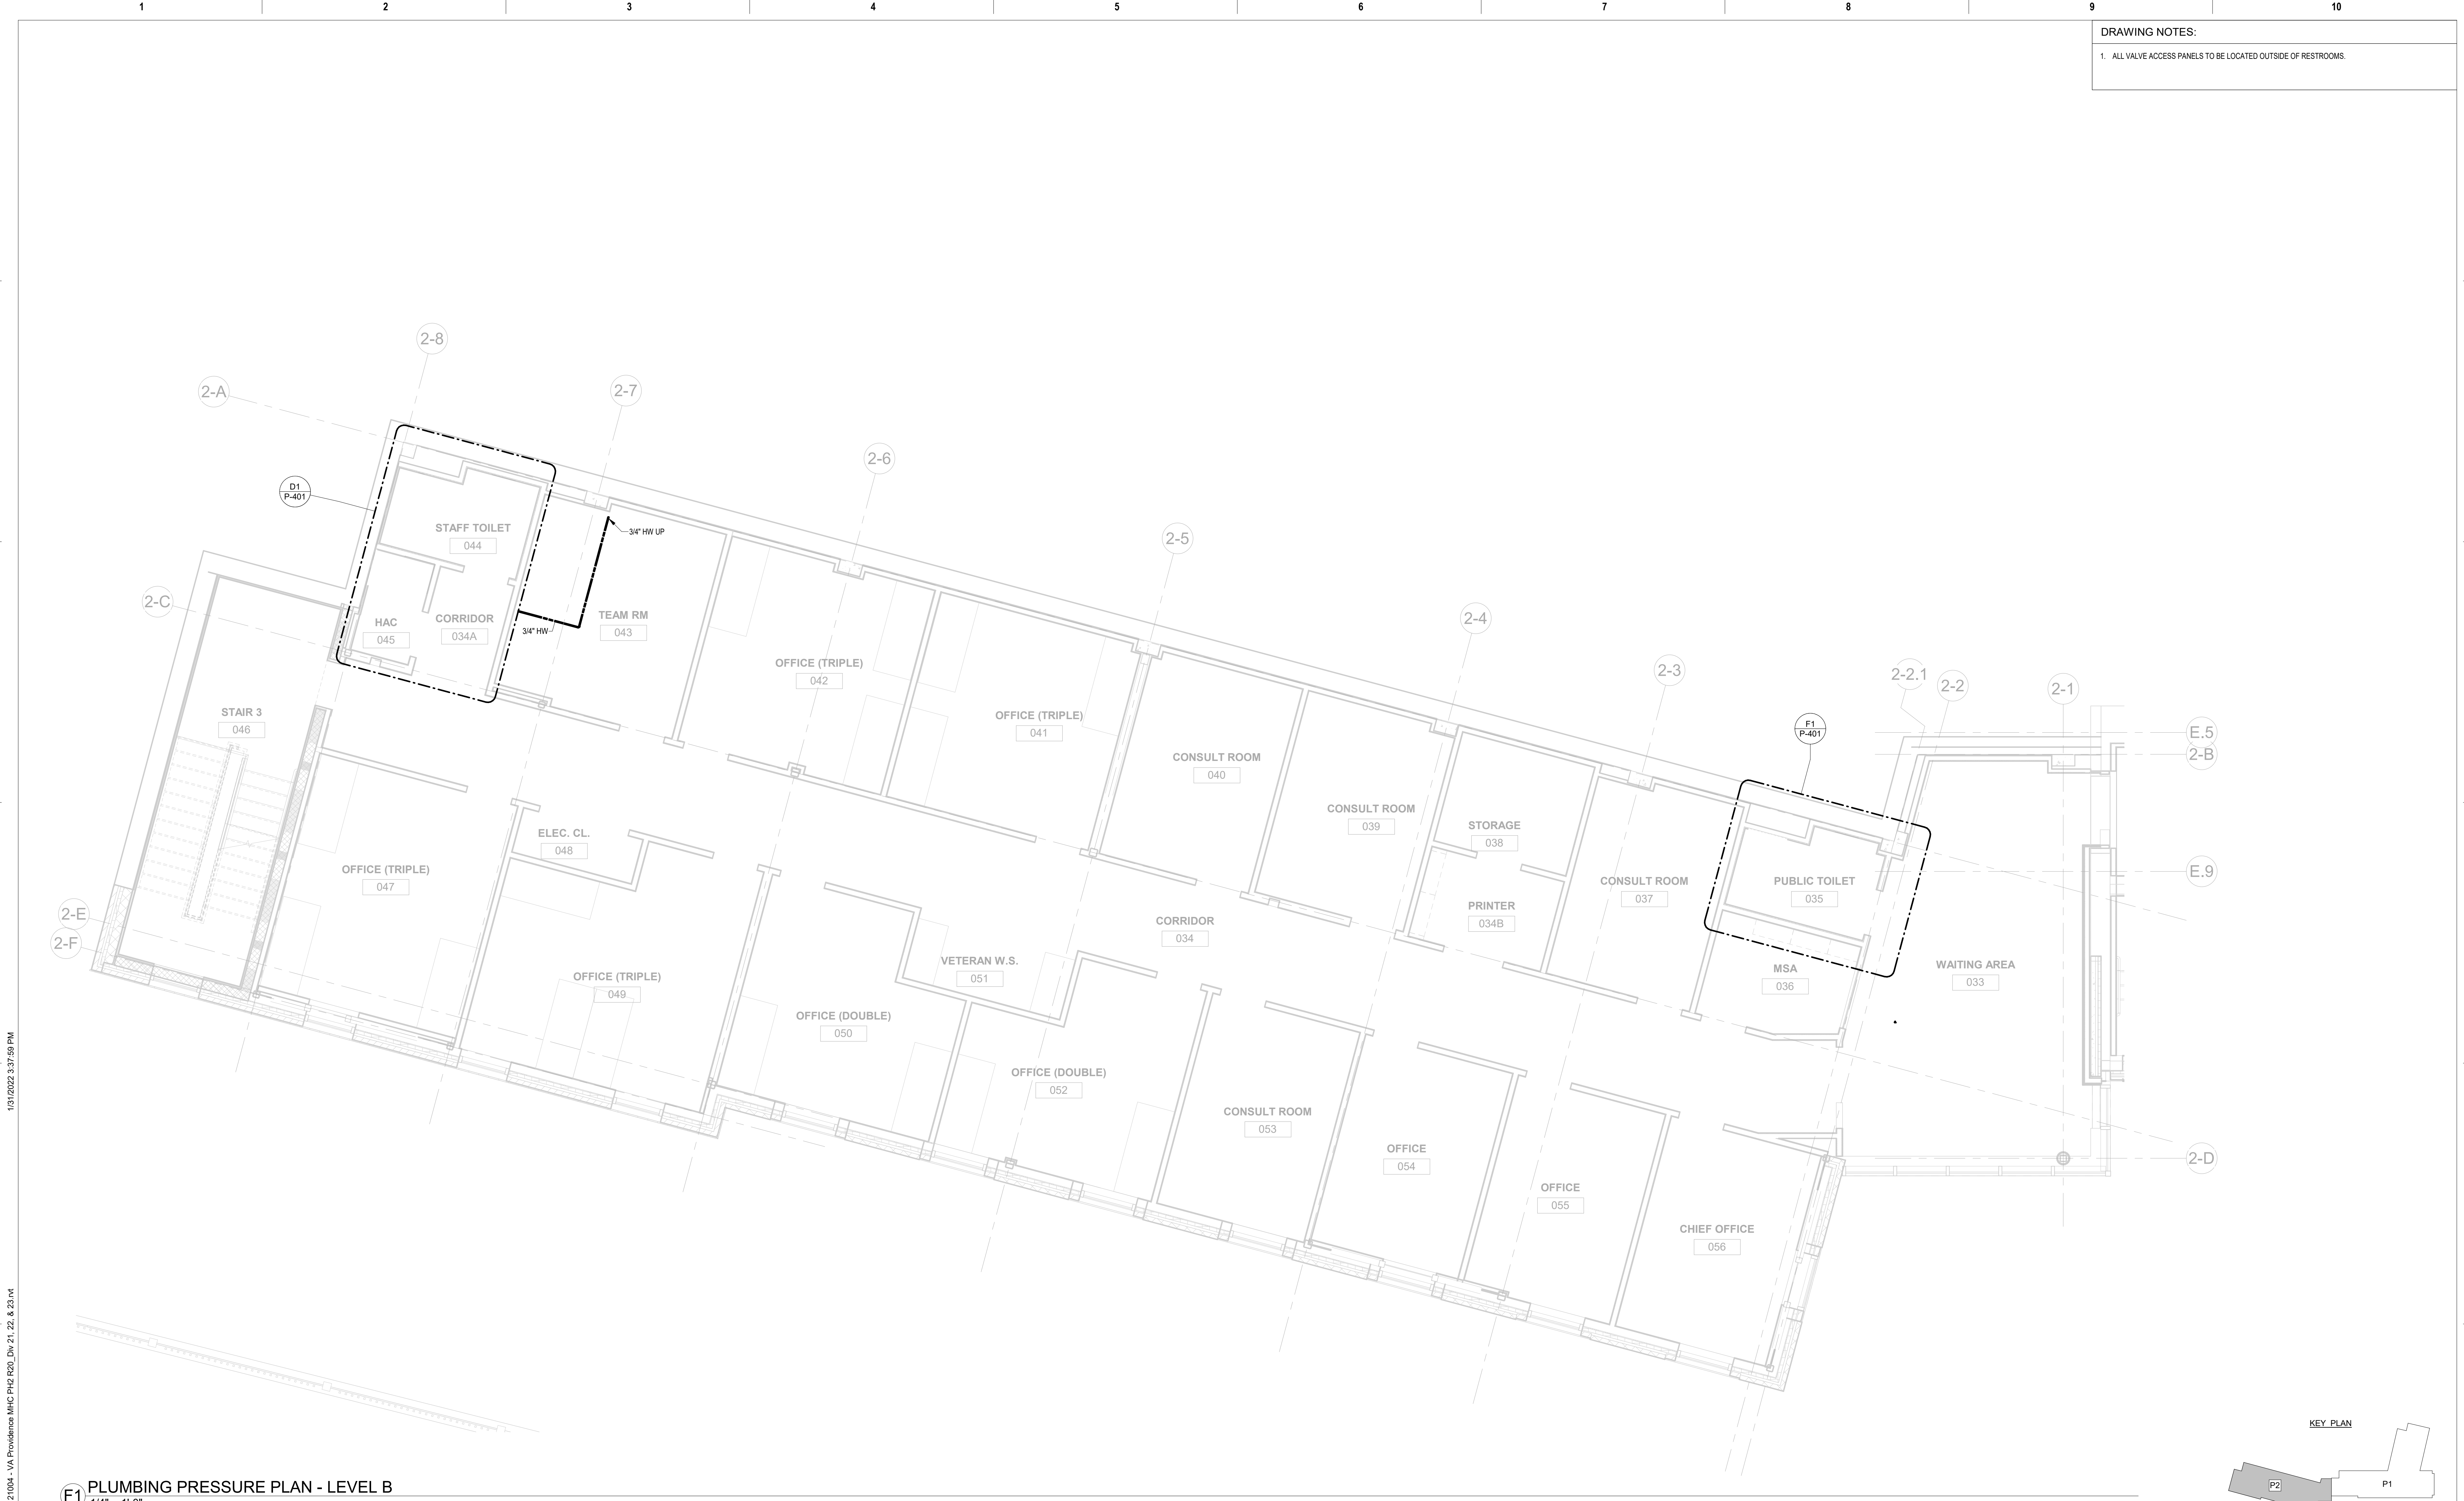

DRAWING NOTES:

1. ALL VALVE ACCESS PANELS TO BE LOCATED OUTSIDE OF RESTROOMS.

F1 PLUMBING PRESSURE PLAN - LEVEL B
1/4" = 1'-0"

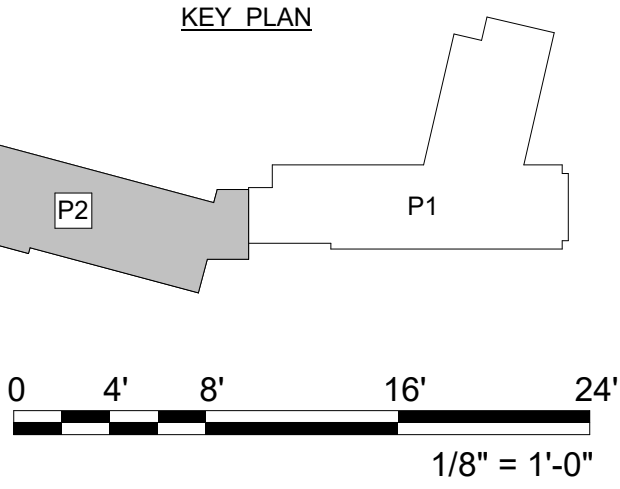

	<table><tr><td>Revisions:</td><td>Revision Description</td><td>Date:</td></tr><tr><td> </td><td> </td><td> </td></tr><tr><td> </td><td> </td><td> </td></tr><tr><td> </td><td> </td><td> </td></tr><tr><td> </td><td> </td><td> </td></tr><tr><td> </td><td> </td><td> </td></tr><tr><td> </td><td> </td><td> </td></tr><tr><td> </td><td> </td><td> </td></tr><tr><td> </td><td> </td><td> </td></tr><tr><td> </td><td> </td><td> </td></tr></table>	Revisions:	Revision Description	Date:																												ENGINEER ENGINEERING DESIGN CONSULTING www.abovegroupinc.com COA/CA Lic. No. 31120 305 East Dr., Suite H, Melbourne, Florida 32904 PH: 321.345.9026	ARCHITECT/ENGINEER OF RECORD ARCHITECTS • ENGINEERS WWW.WBRCAE.COM BANGOR, MAINE 207-947-4511 PORTLAND, MAINE 207-838-4511 SARASOTA, FLORIDA 941-556-0757	STAMP Allen D. Lantz, P.E. MD License #41513	Office of Construction and Facilities Management U.S. Department of Veterans Affairs	Drawing Title PLUMBING PRESSURE - LEVEL B PLAN Approved:	Phase CONSTRUCTION DOCUMENTS FULLY SPRINKLERED	Project Title PROVIDENCE VAMC MENTAL HEALTH PHASE 2 Location PROVIDENCE, RI Issue Date FEB 04 2022	Checked ADL Drawn AJZ	Project Number 650-347 Building Number 39 Drawing Number PP111
		Revisions:	Revision Description	Date:																																				
VA FORM 08 - 6231																																								



DRAWING NOTES:

1. ALL VALVE ACCESS PANELS TO BE LOCATED OUTSIDE OF RESTROOMS.

VA FORM 08 - 6231

PROJECT NORTH

Revisions:	Revision Description	Date:

ENGINEER

bove Group

ENGINEERING | DESIGN | CONSULTING

www.abovegroupinc.com
COA/CA Lic. No. 31120

305 East Dr., Suite H,
Melbourne, Florida 32904
PH: 321.345.9026

ARCHITECT/ENGINEER OF RECORD

WBRC

ARCHITECTS • ENGINEERS

WWW.WBRCAE.COM
BANGOR, MAINE 207-947-4511
PORTLAND, MAINE 207-838-4511
SARASOTA, FLORIDA 941-556-0757

STAMP

ALLEN D. LANTZ, P.E.
MD LICENSE #41513

Office of Construction and Facilities Management

VA U.S. Department of Veterans Affairs

Drawing Title
PLUMBING PRESSURE - LEVEL 1 PLAN

Approved:

Phase
CONSTRUCTION DOCUMENTS

FULLY SPRINKLERED

Project Title
PROVIDENCE VAMC MENTAL HEALTH PHASE 2

Location
PROVIDENCE, RI

Issue Date
FEB 04 2022

Checked
ADL


Drawn
AJZ

Project Number
650-347


Building Number
39

Drawing Number
PP121


- DRAWING NOTES:
1. ALL VALVE ACCESS PANELS TO BE LOCATED OUTSIDE OF RESTROOMS.
 2. PROVIDE THERMOSTATIC MIXING VALVES AT ALL LAVATORIES.

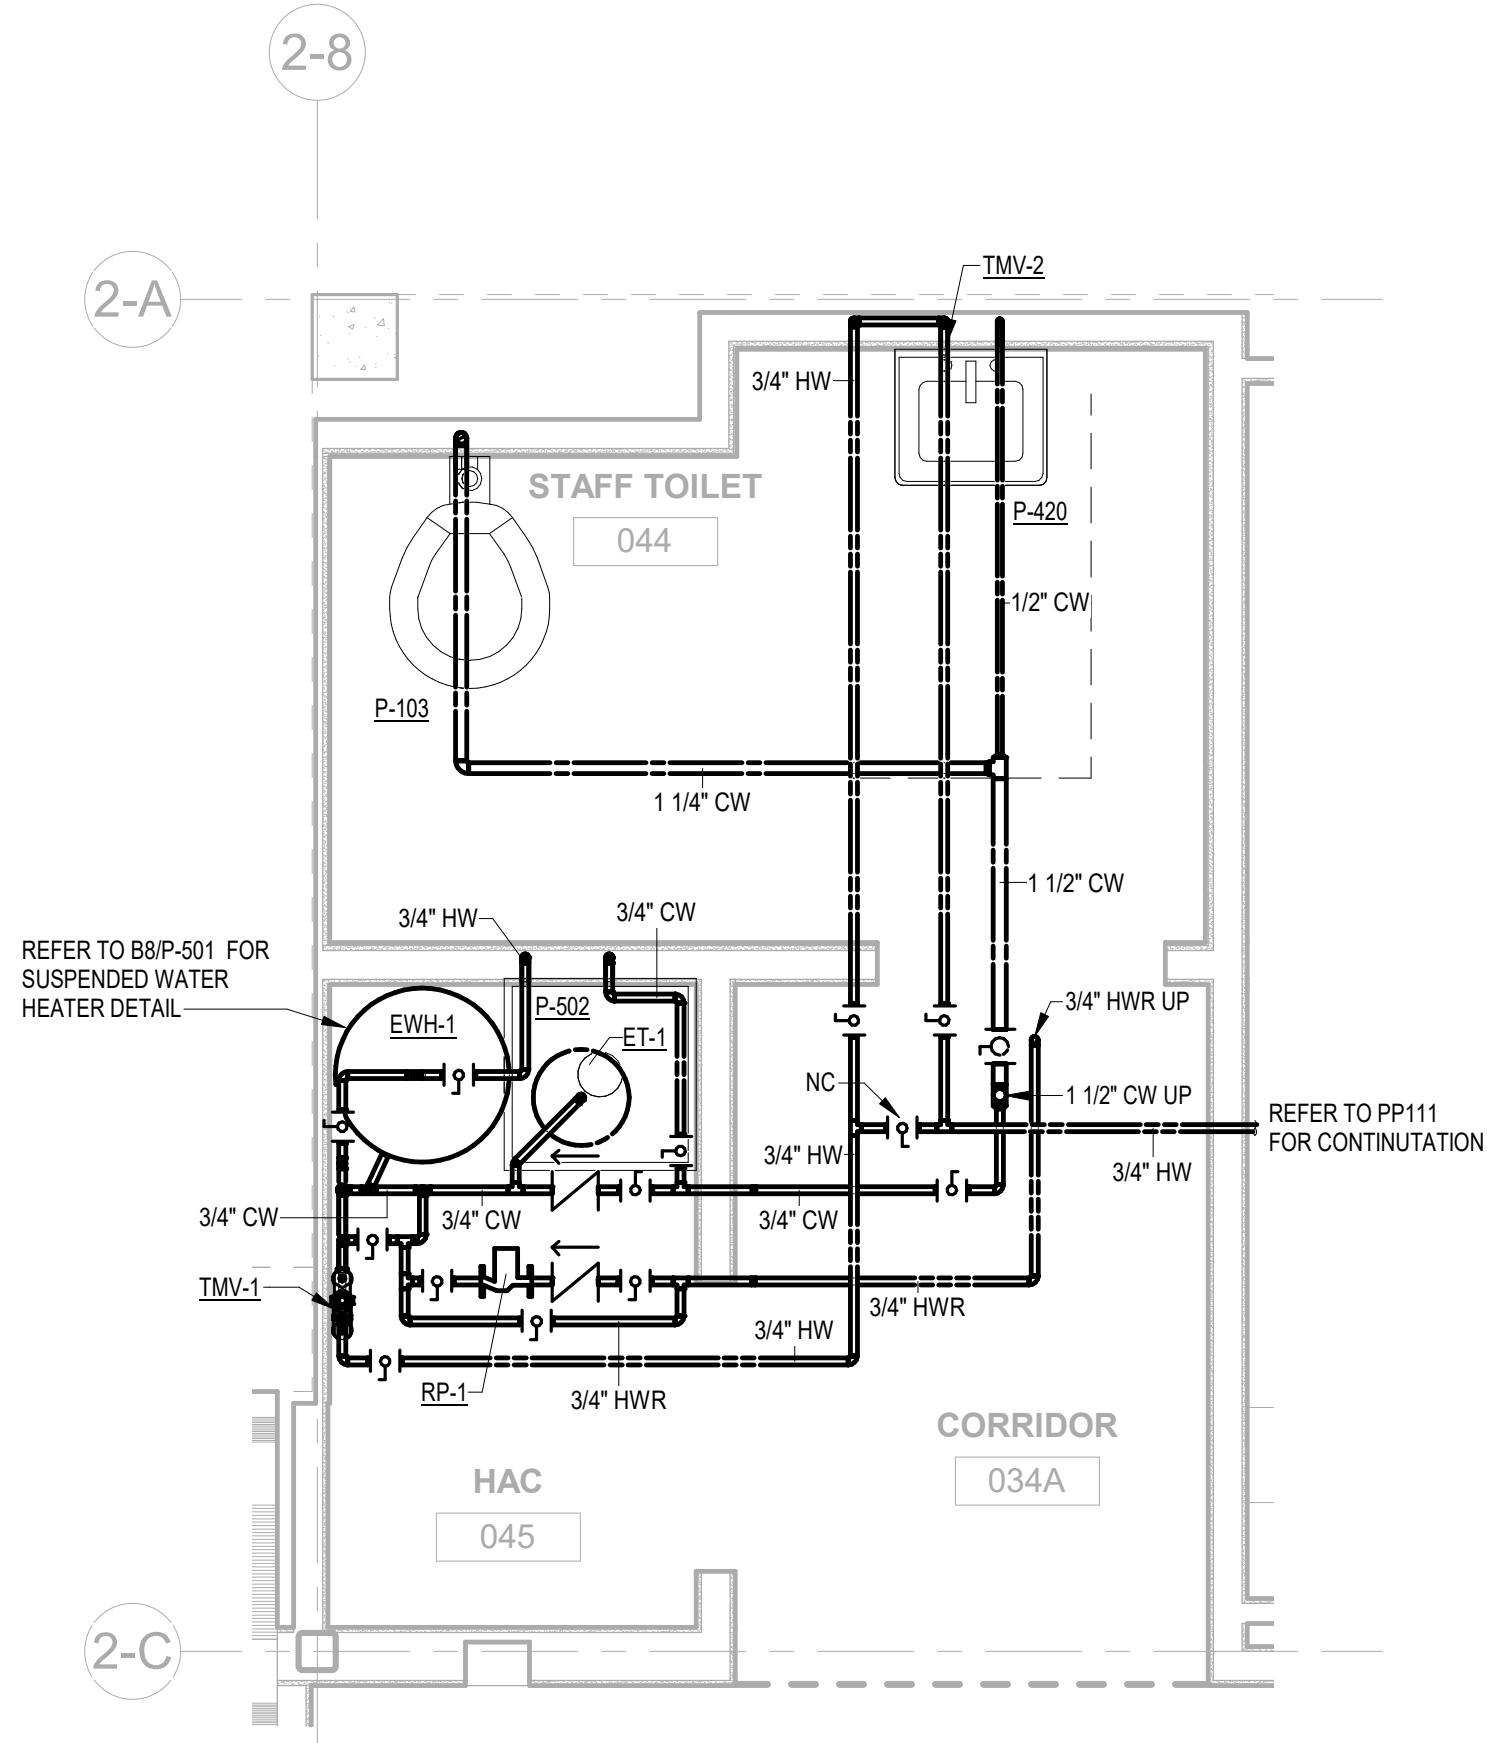


D1 LEVEL B ENLARGED STAFF TOILET 044 & HAC 045 PLAN
1/2" = 1'-0"

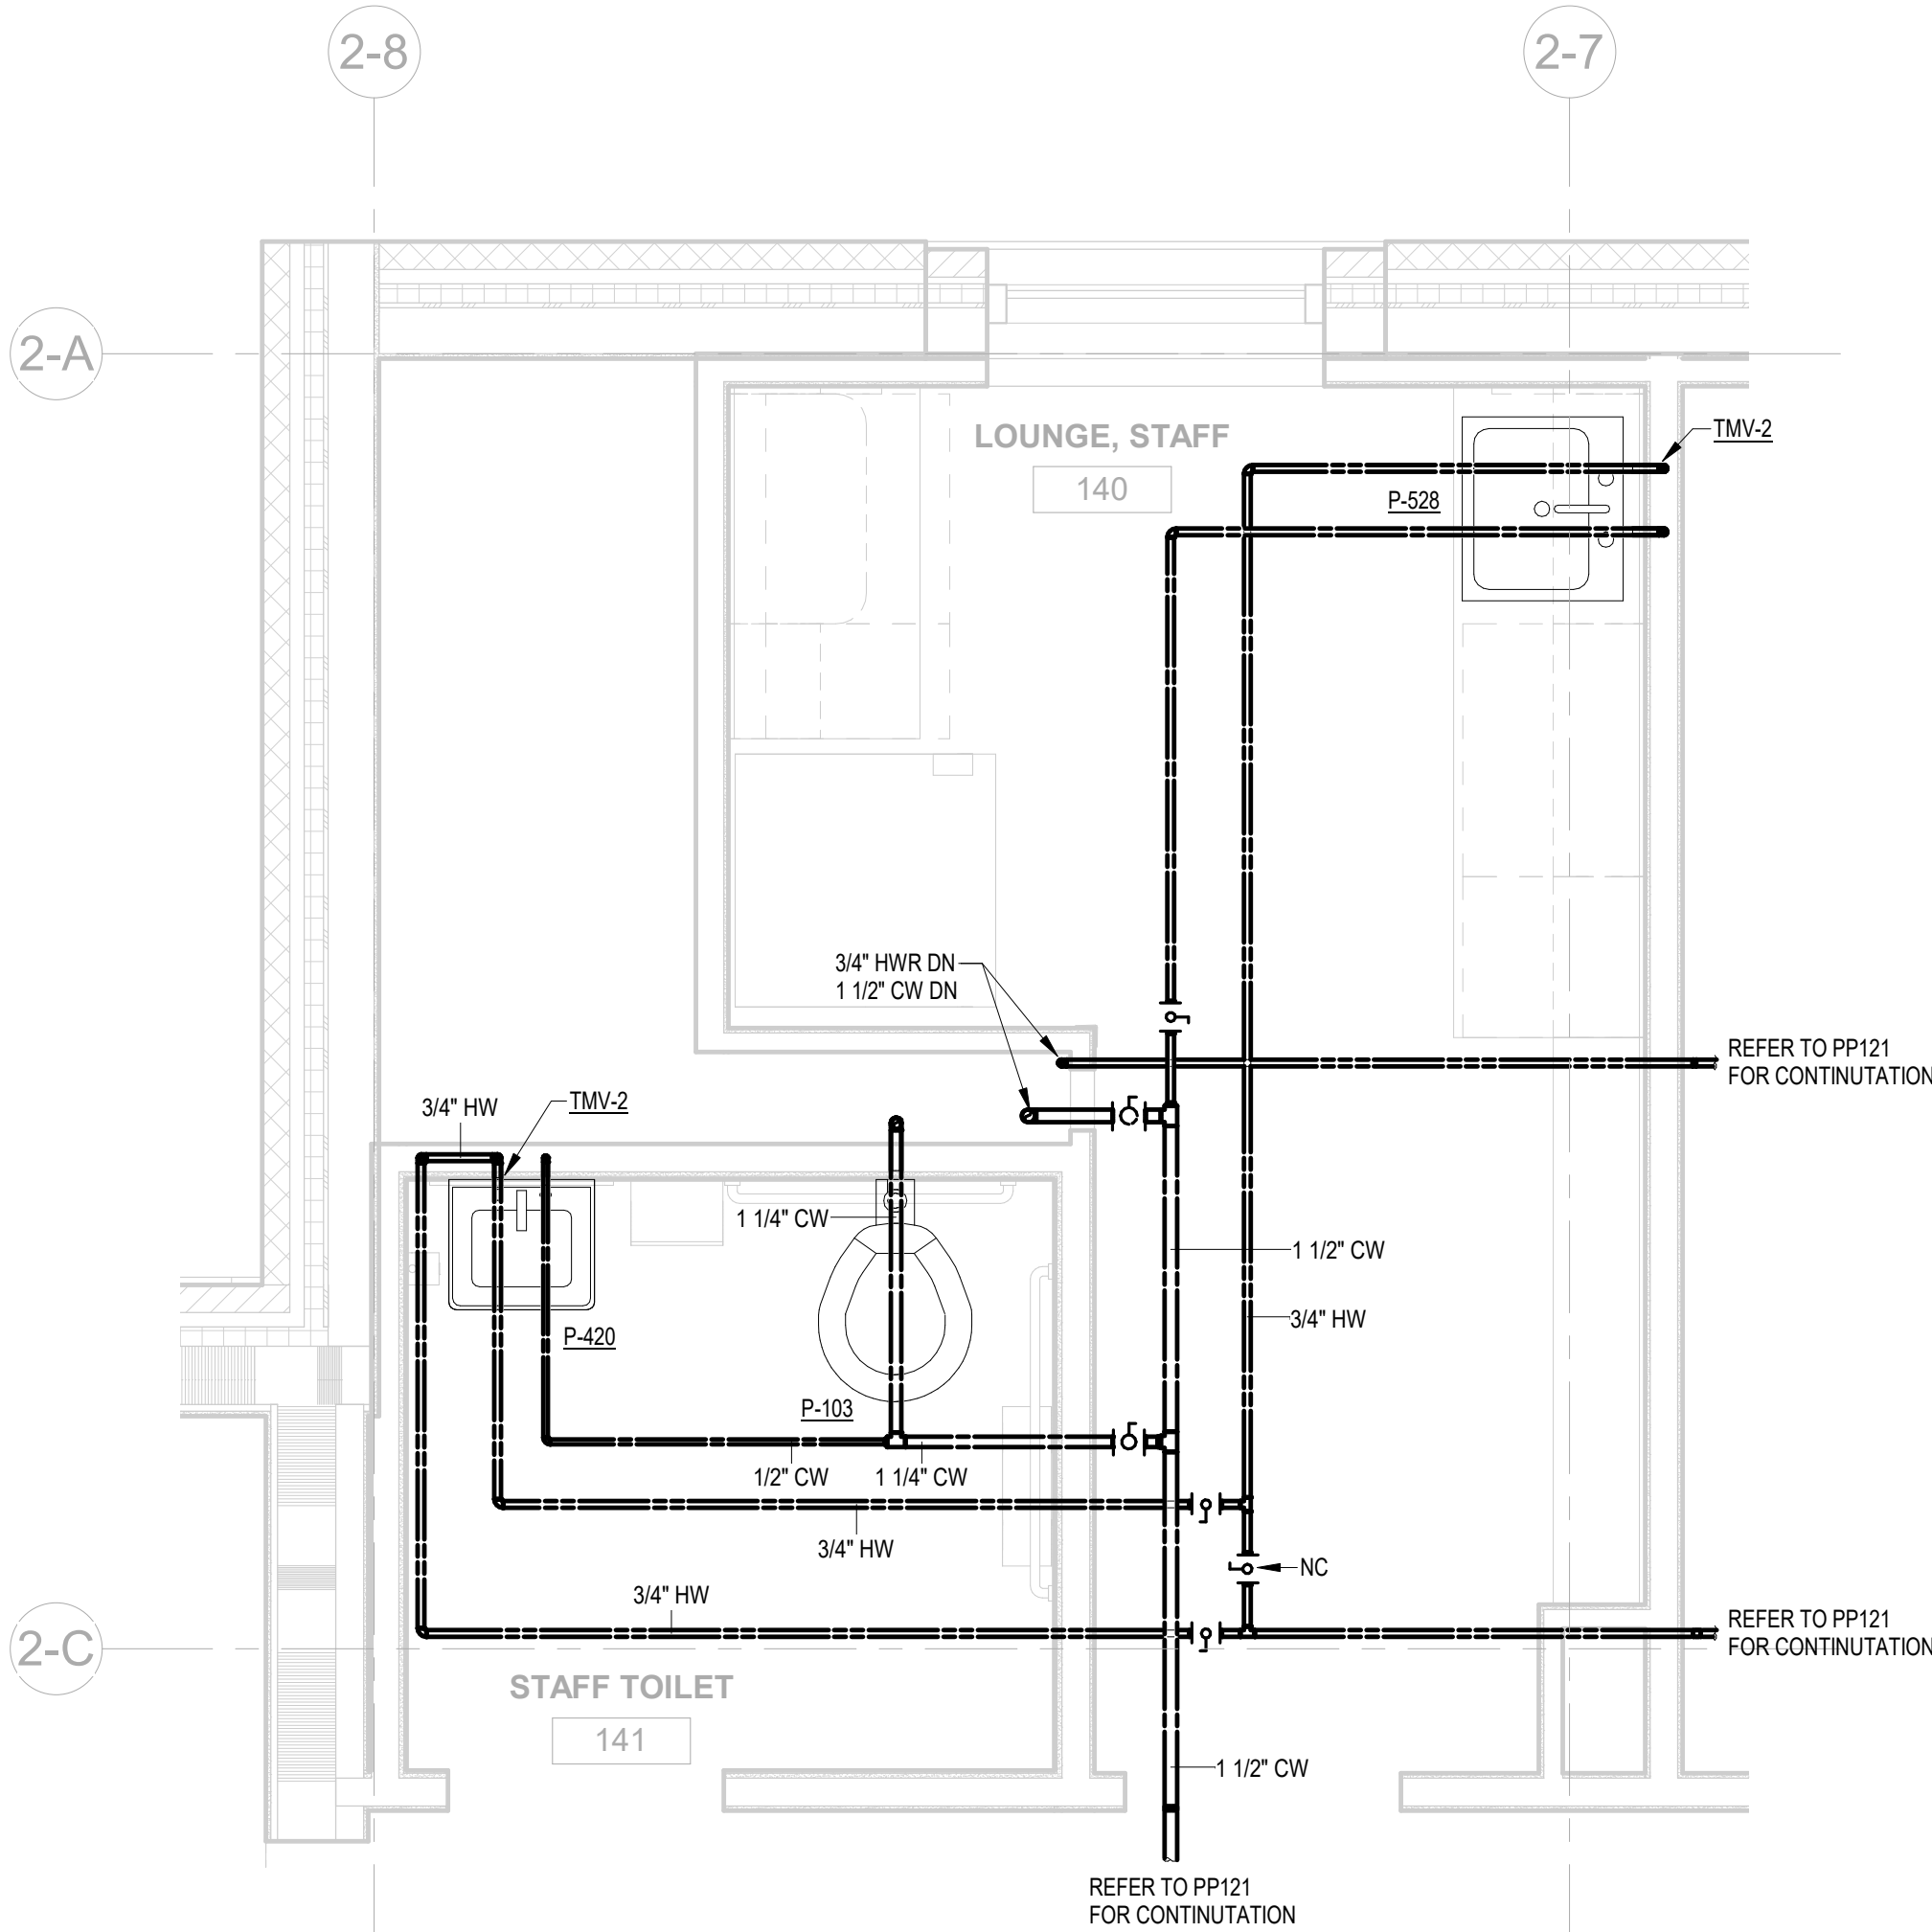


D4 LEVEL 1 ENLARGED STAFF TOILET 141 & STAFF LOUNGE
1/2" = 1'-0"

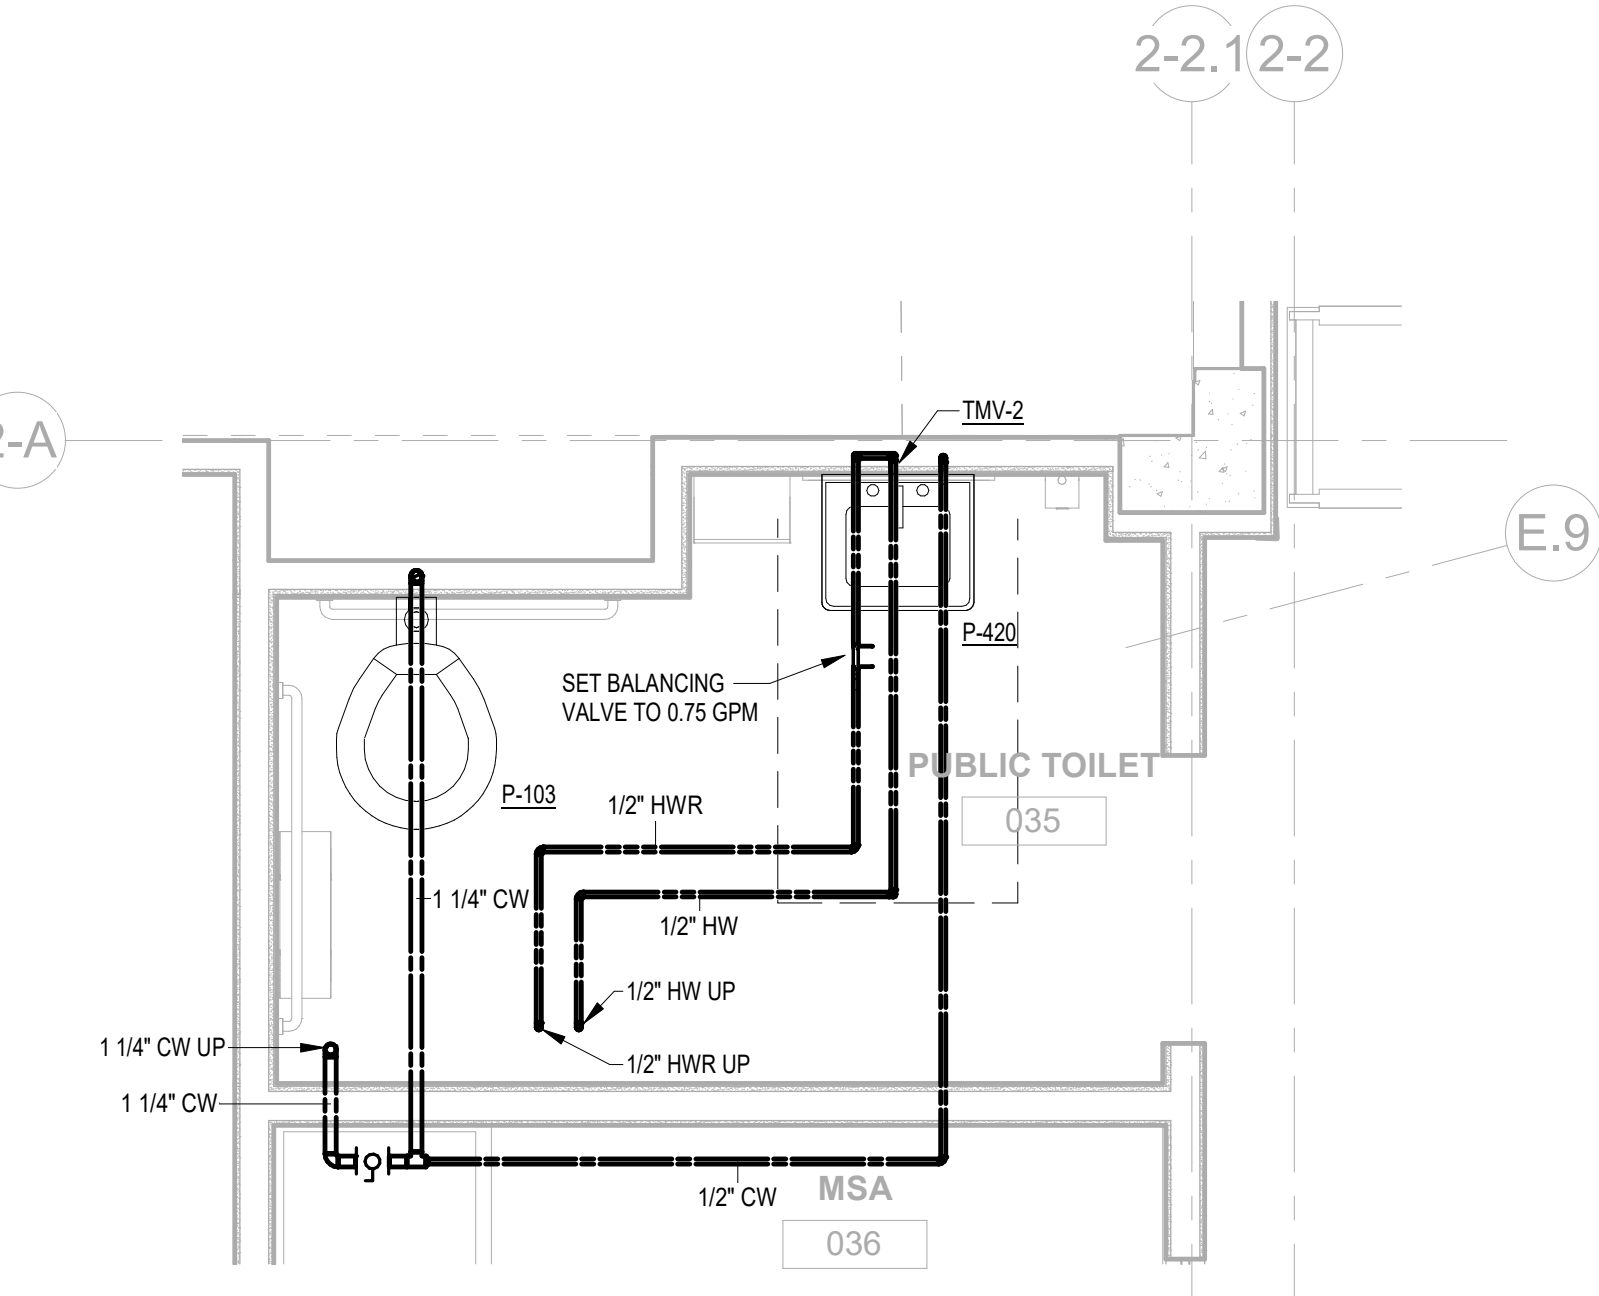

F1 LEVEL B ENLARGED PUBLIC TOILET 035
1/2" = 1'-0"

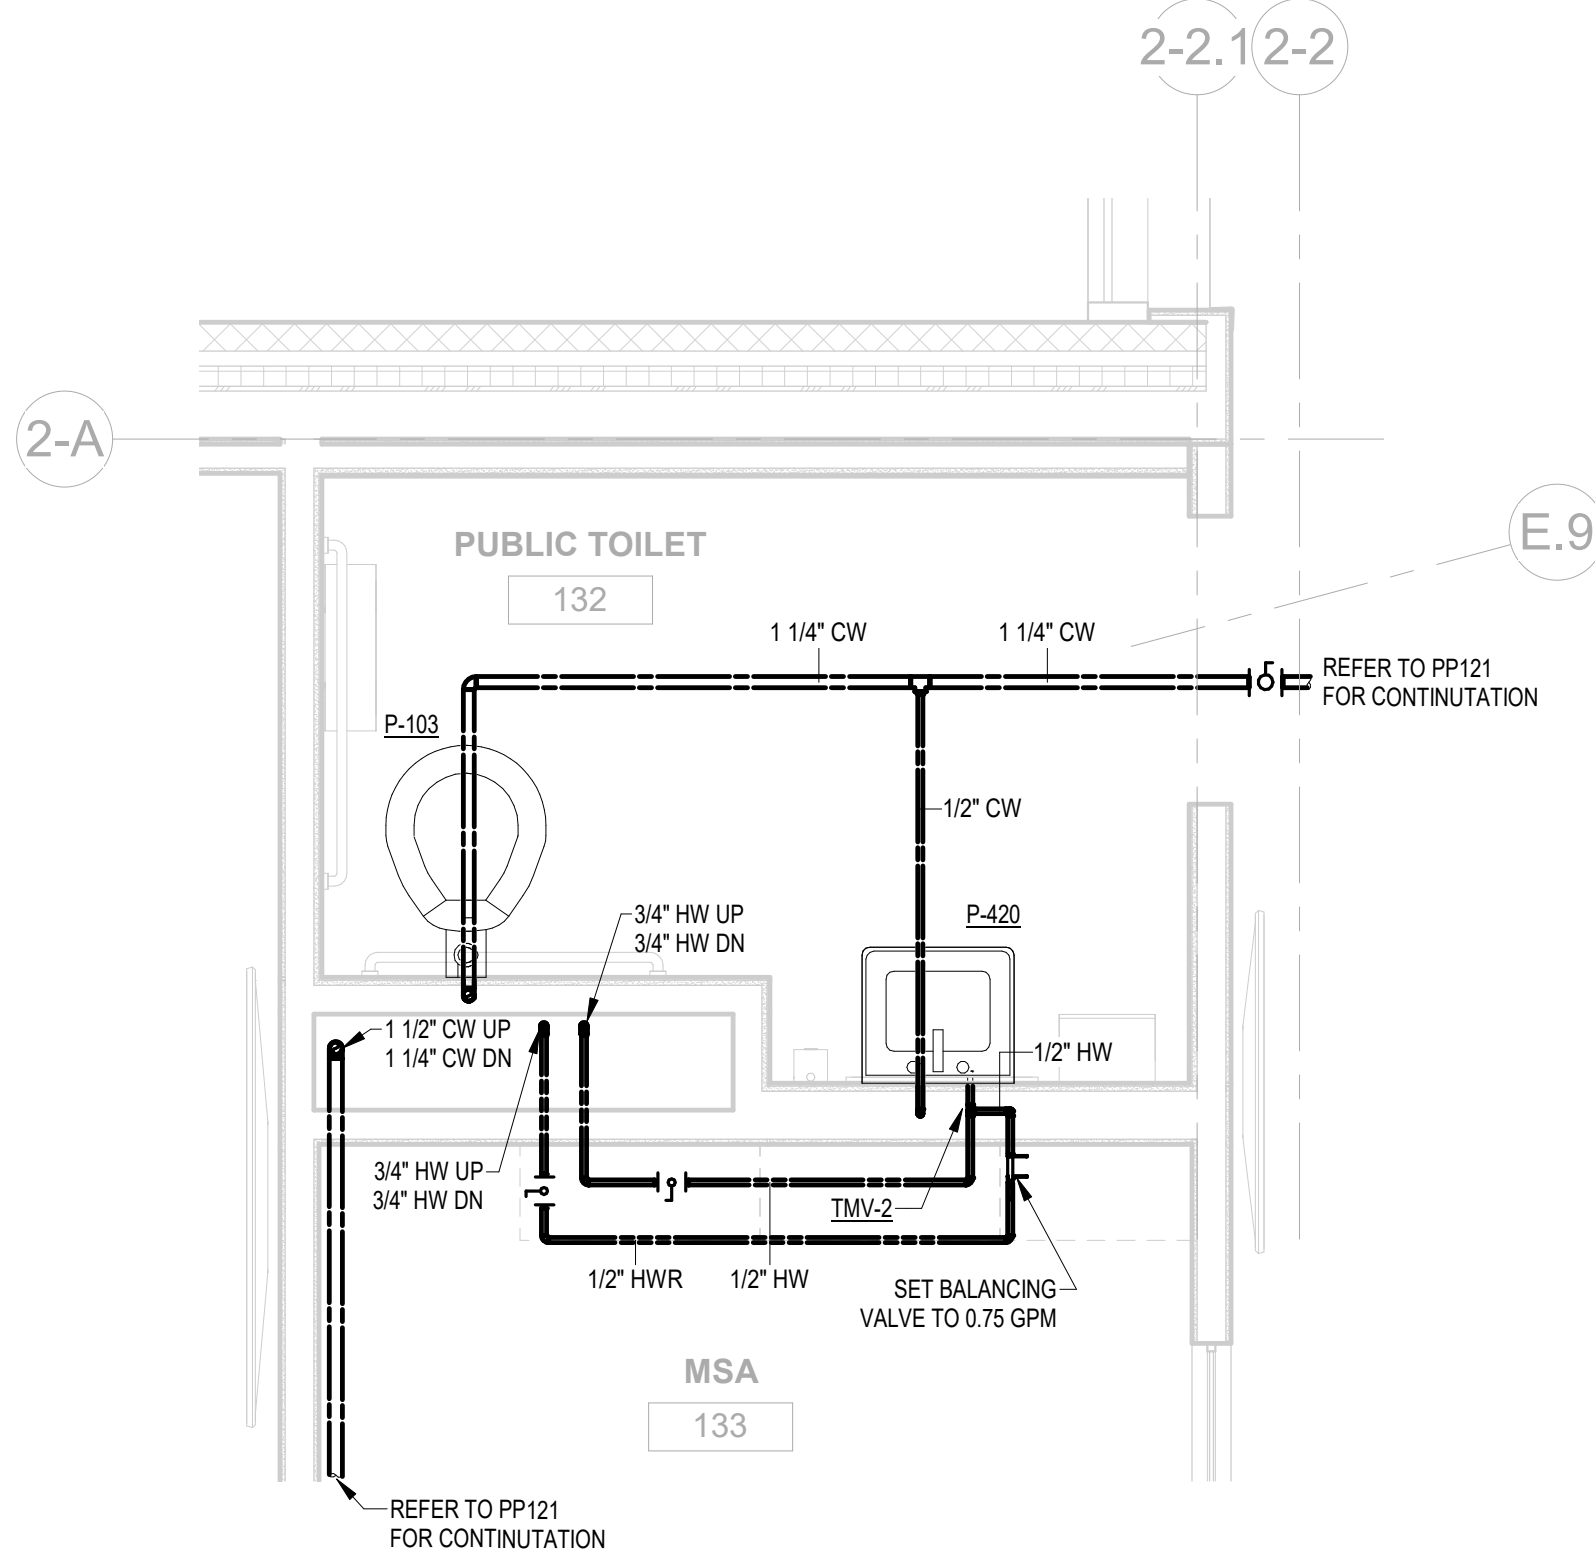


F4 LEVEL 1 ENLARGED PUBLIC TOILET 132
1/2" = 1'-0"

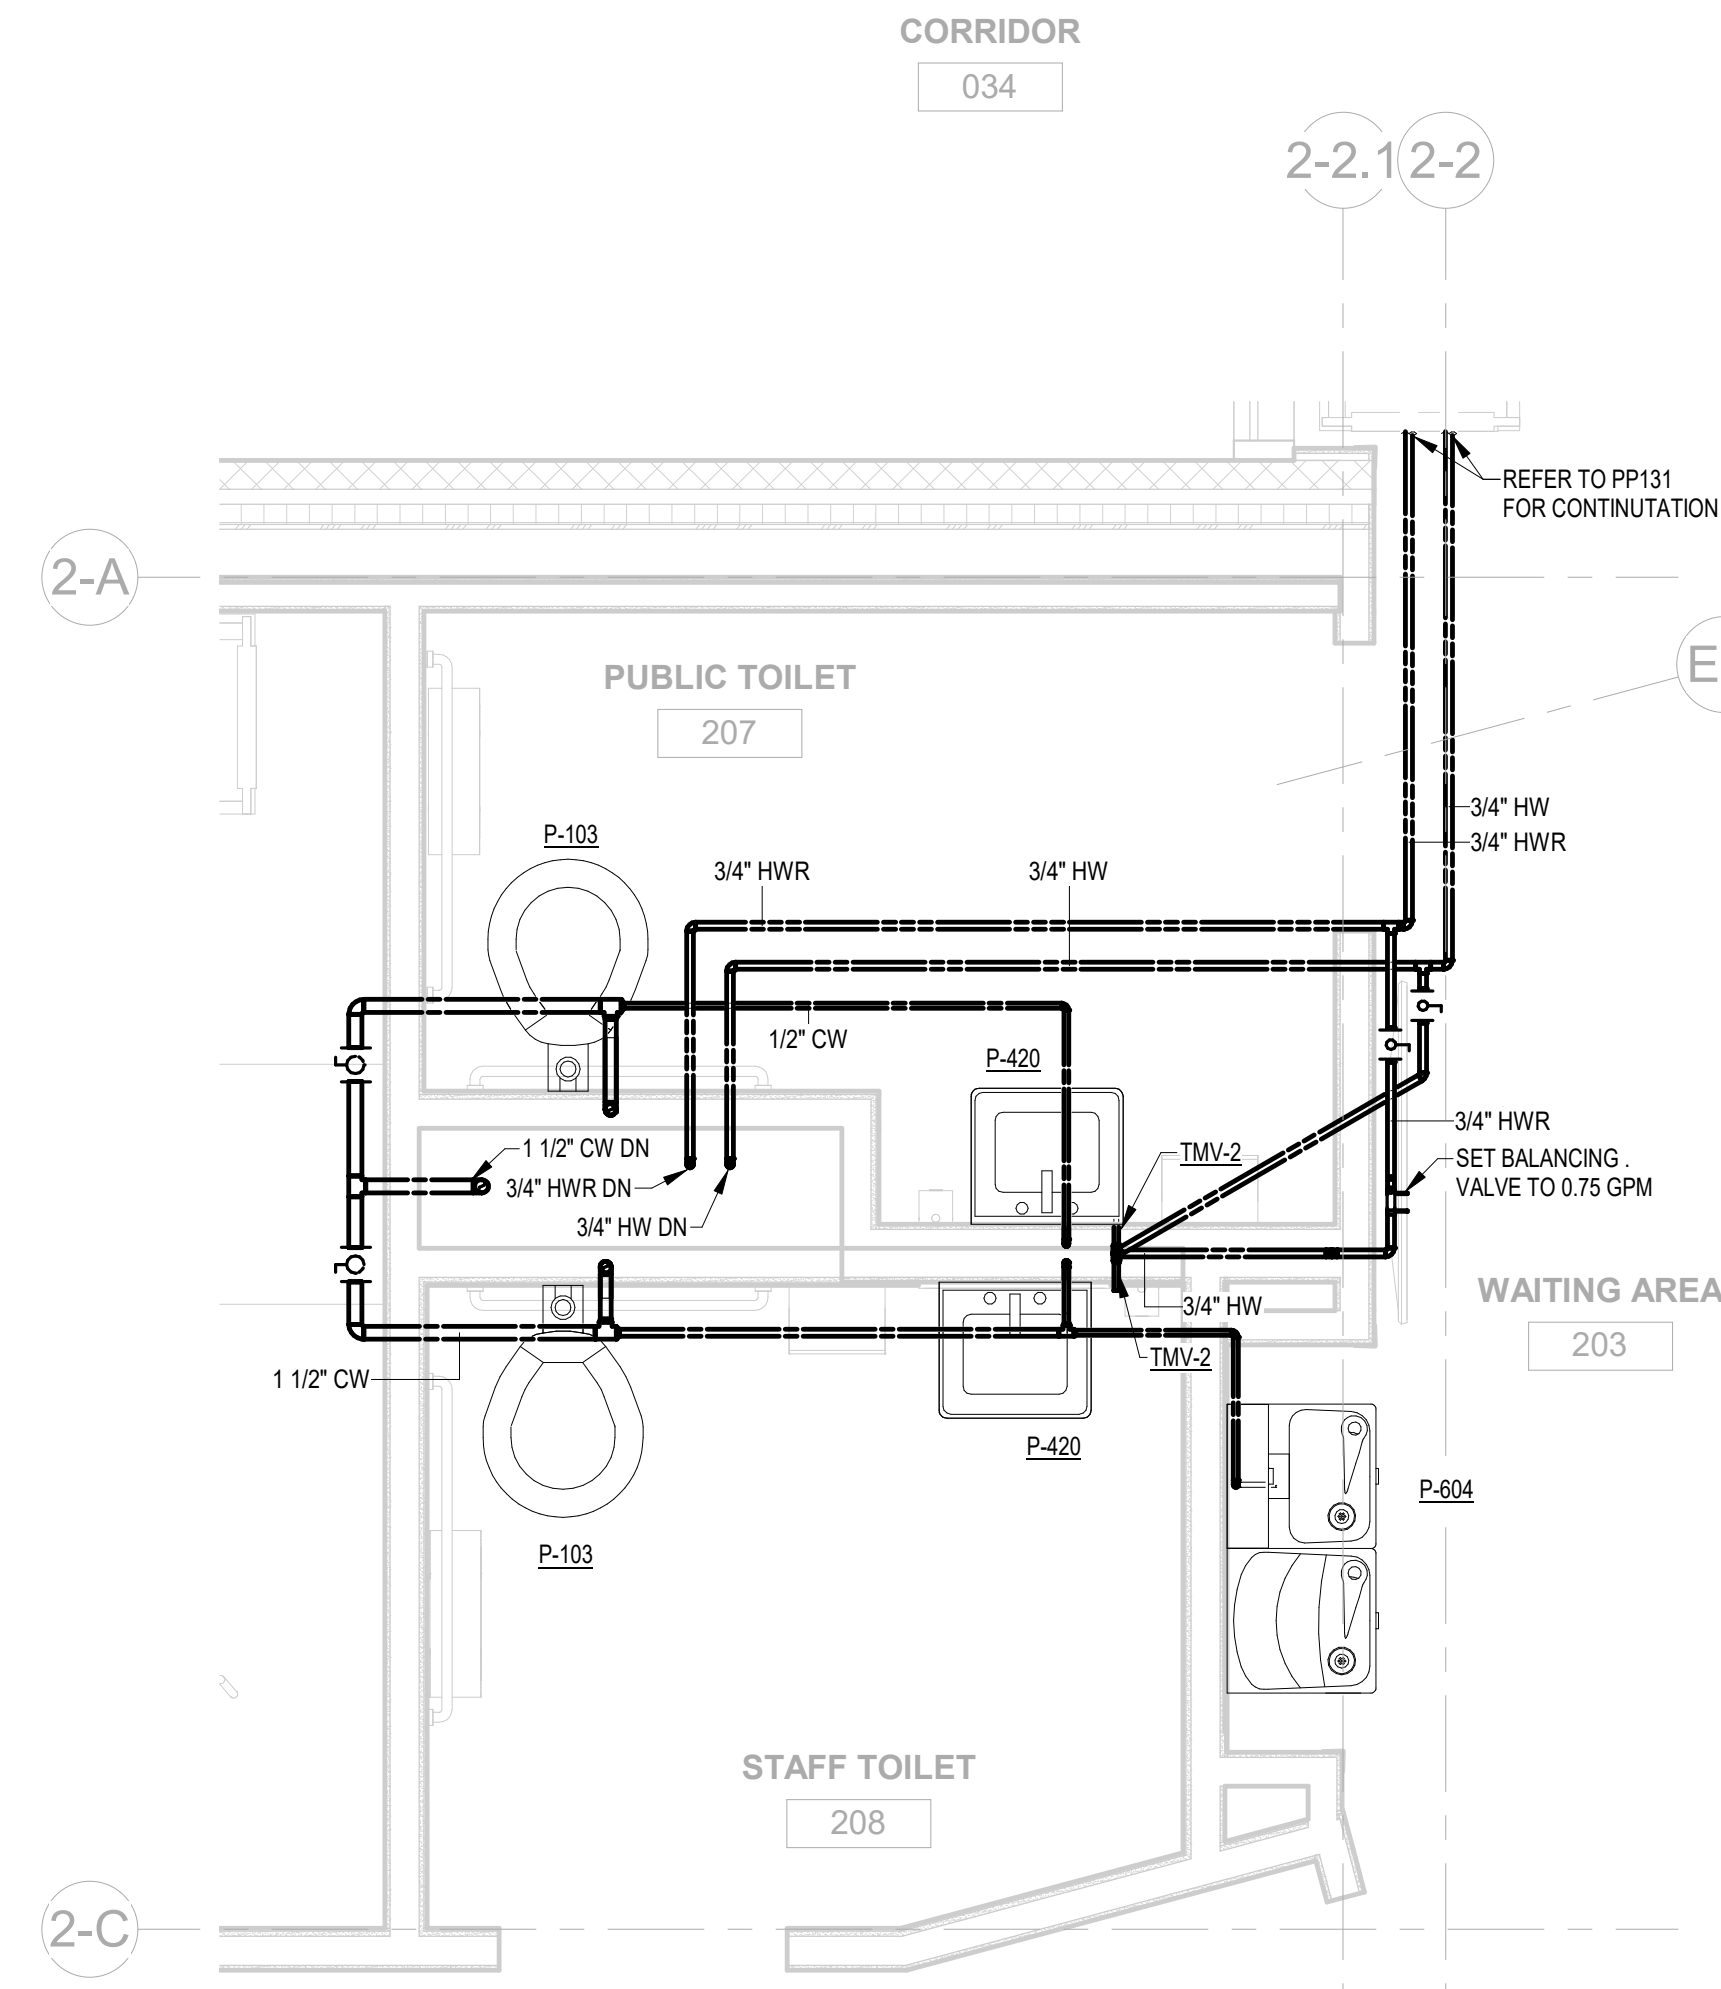

F7 LEVEL 2 ENLARGED PUBLIC TOILET 207 & STAFF TOILET 208
1/2" = 1'-0"

0 1' 2' 4' 6'
1/2" = 1'-0"

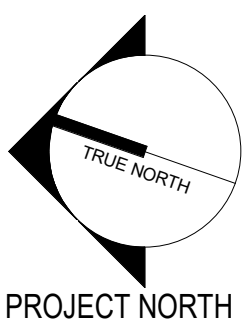

Revisions:	Revision Description	Date:

ENGINEER

above Group
ENGINEERING | DESIGN | CONSULTING

www.abovegroupinc.com
COA/CA Lic. No. 31120

305 East Dr., Suite H,
Melbourne, Florida 32904
PH: 321.345.9026

ARCHITECT/ENGINEER OF RECORD

WBRC
ARCHITECTS • ENGINEERS

www.wbrcae.com
BANGOR, MAINE 207-947-4511
PORTLAND, MAINE 207-838-4511
SARASOTA, FLORIDA 941-556-0757

STAMP

ALLEN D. LANTZ, P.E.
MD License #41513

**Office of
Construction
and Facilities
Management**

VA U.S. Department
of Veterans Affairs

Drawing Title
PLUMBING ENLARGED PLANS

Approved:

Phase
**CONSTRUCTION
DOCUMENTS**

FULLY SPRINKLERED

Project Title
PROVIDENCE VAMC MENTAL
HEALTH PHASE 2

Location
PROVIDENCE, RI

Issue Date
FEB 04 2022


Checked
ADL

Drawn
AJZ


Project Number
650-347

Building Number
39

Drawing Number
P-401

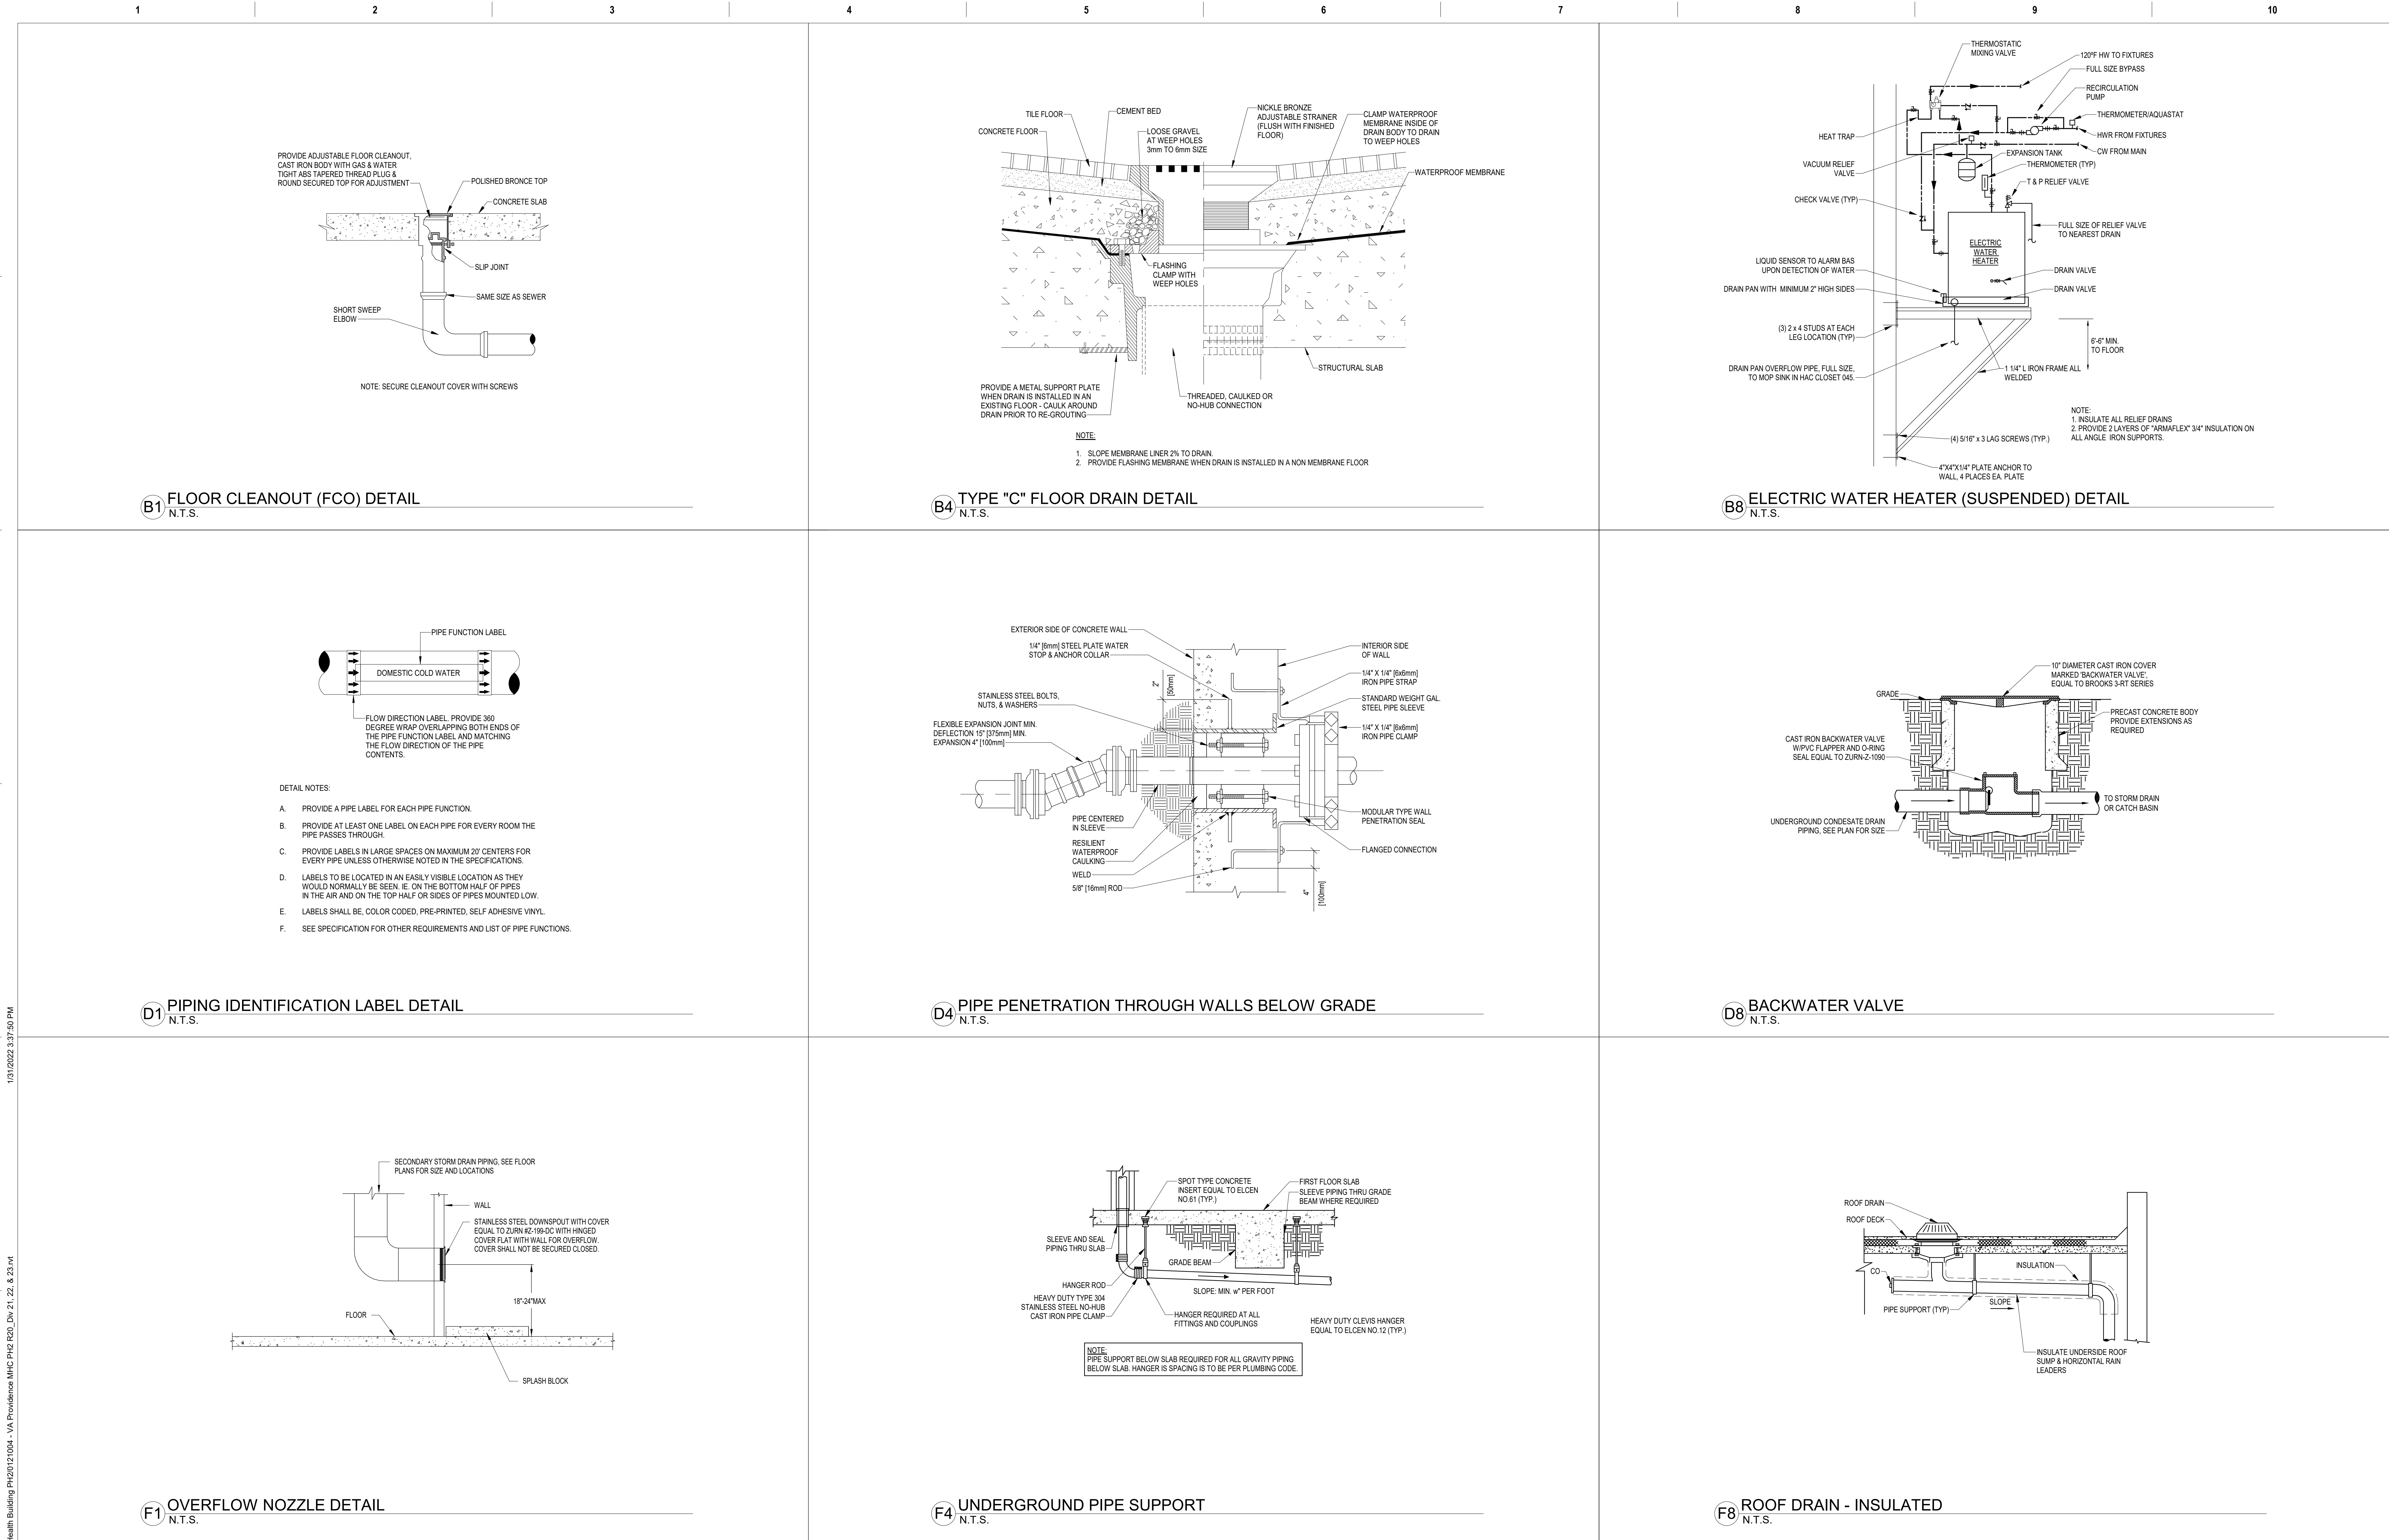


<div>Revisions:</div> <table><thead><tr><th>Revision Description</th><th>Date:</th></tr></thead><tbody><tr><td> </td><td> </td></tr><tr><td> </td><td> </td></tr><tr><td> </td><td> </td></tr><tr><td> </td><td> </td></tr><tr><td> </td><td> </td></tr><tr><td> </td><td> </td></tr><tr><td> </td><td> </td></tr><tr><td> </td><td> </td></tr><tr><td> </td><td> </td></tr></tbody></table>	Revision Description	Date:																			<div>ENGINEER</div> <div> Above Group</div> <div>ENGINEERING DESIGN CONSULTING</div> <div>www.abovegroupinc.com COA/CA Lic. No. 31120</div> <div>305 East Dr., Suite H, Melbourne, Florida 32904 PH: 321.345.9026</div>	<div>ARCHITECT/ENGINEER OF RECORD</div> <div> WBRC</div> <div>ARCHITECTS • ENGINEERS</div> <div>www.wbrcae.com BANGOR, MAINE 207-947-4511 PORTLAND, MAINE 207-838-4511 SARASOTA, FLORIDA 941-556-0757</div>	<div>STAMP</div> <div></div> <div>Allen D. Lantz, P.E. MD License #41513</div>	<div>Office of Construction and Facilities Management</div> <div> U.S. Department of Veterans Affairs</div>	<div>Drawing Title</div> <div>PLUMBING DETAILS</div> <div>Approved:</div>	<div>Phase</div> <div>CONSTRUCTION DOCUMENTS</div> <div>FULLY SPRINKLERED</div>	<div>Project Title</div> <div>PROVIDENCE VAMC MENTAL HEALTH PHASE 2</div> <div>Location PROVIDENCE, RI</div> <div>Issue Date FEB 04 2022</div> <div>Checked ADL</div> <div>Drawn AJZ</div>	<div>Project Number</div> <div>650-347</div> <div>Building Number</div> <div>39</div> <div>Drawing Number</div> <div>P-501</div>
	Revision Description	Date:																										

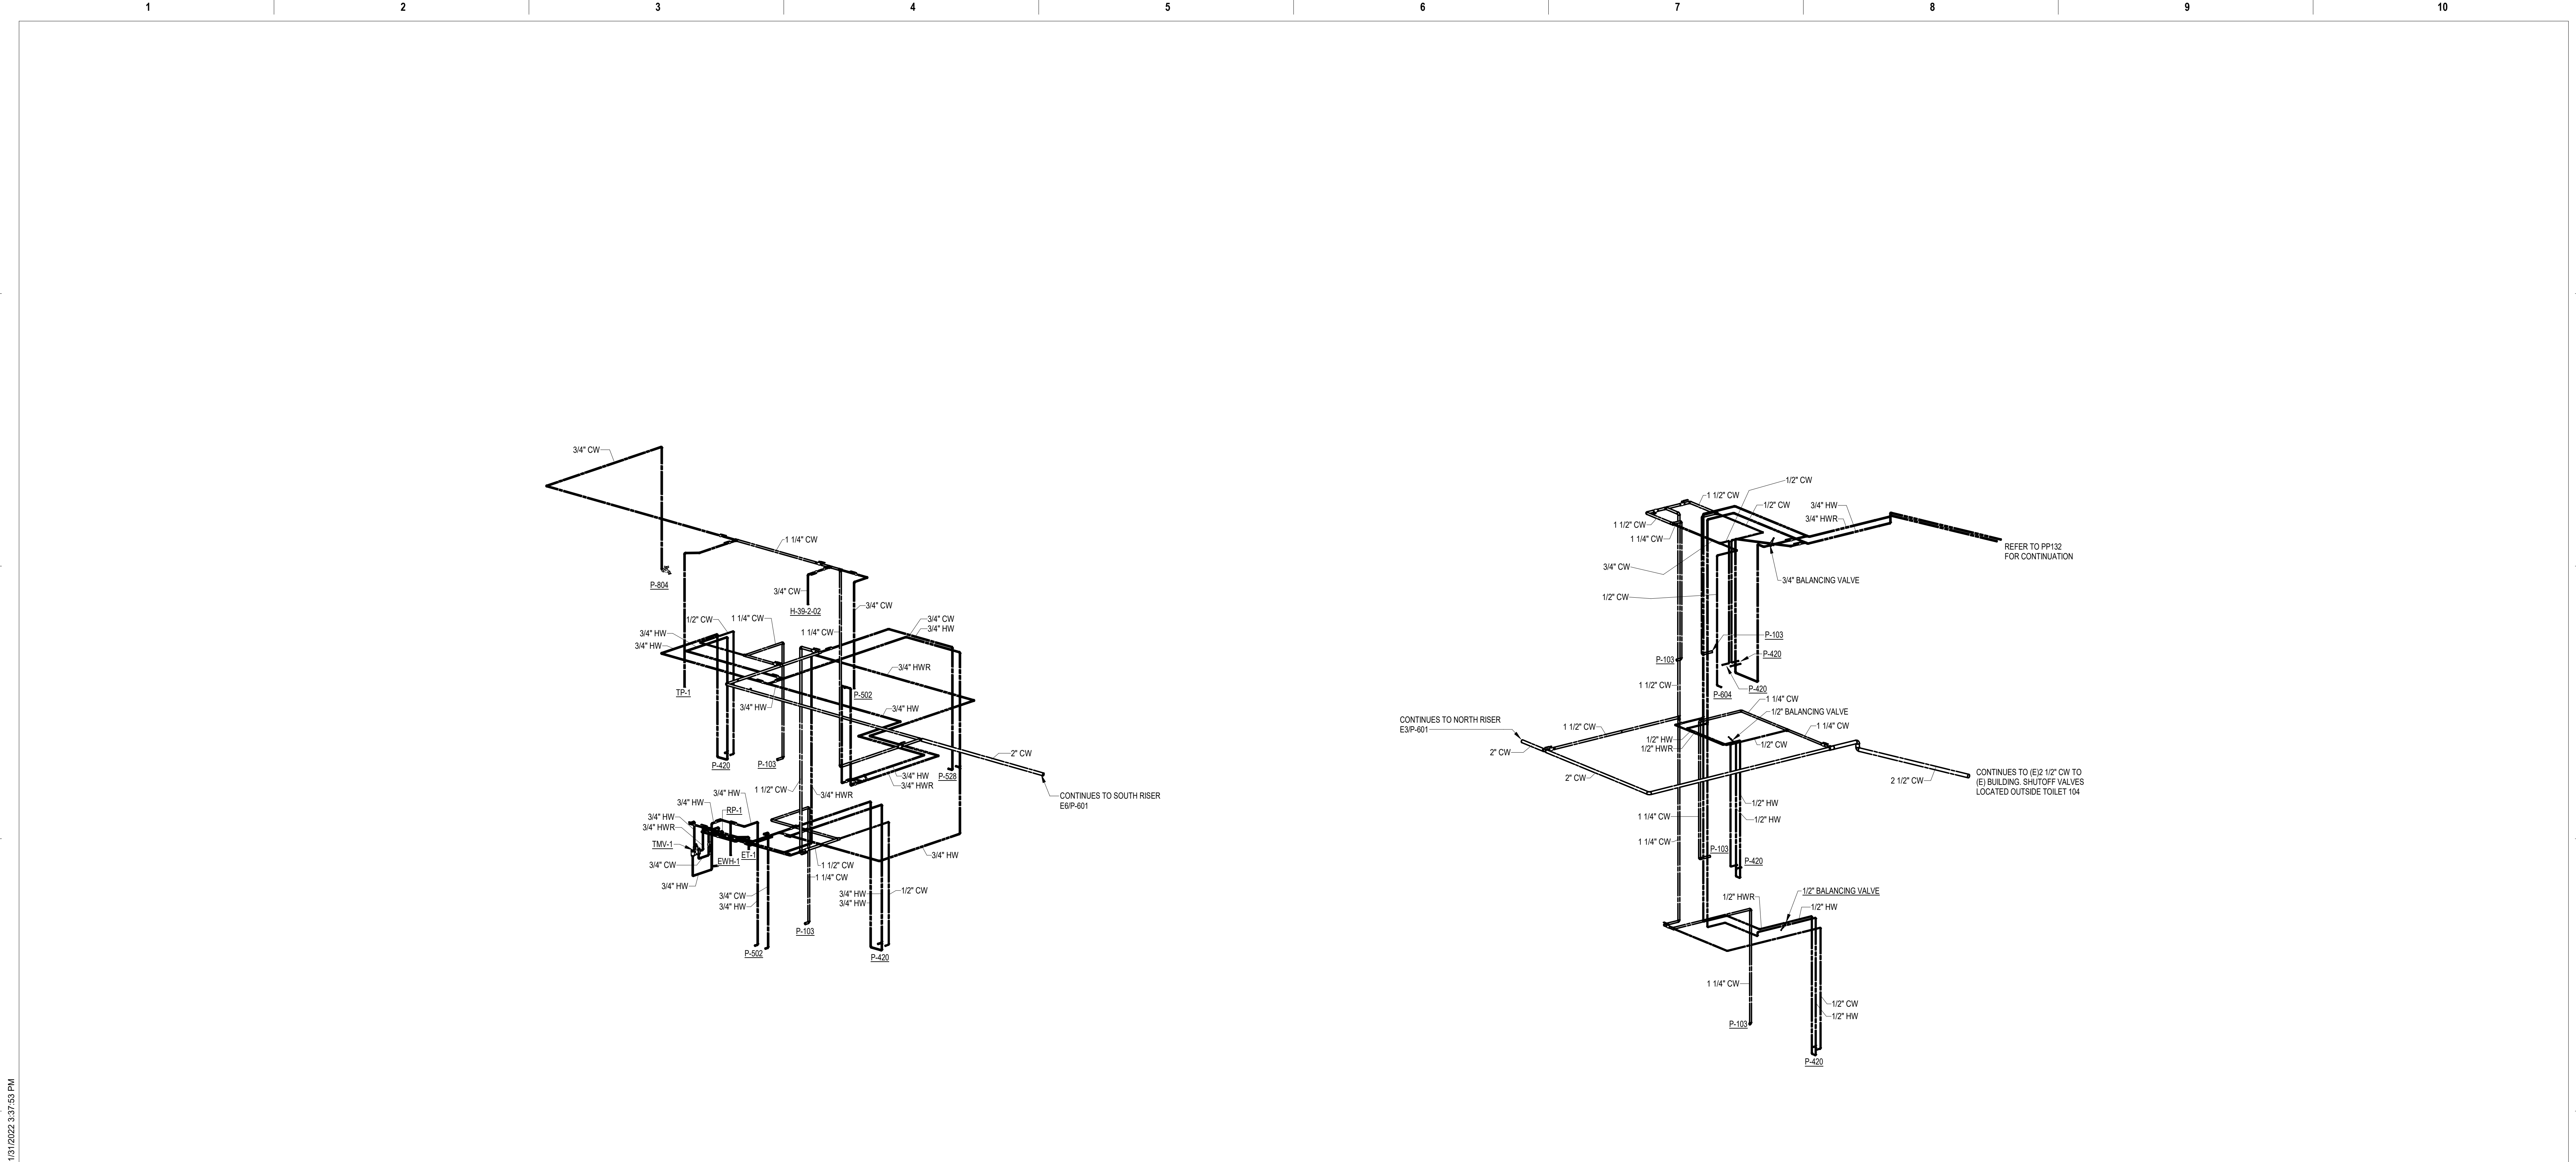



E2 PLUMBING PRESSURE ISOMETRIC - NORTH
N.T.S.

E6 PLUMBING PRESSURE ISOMETRIC - SOUTH
N.T.S.

	ENGINEER		ARCHITECT/ENGINEER OF RECORD		STAMP		Office of Construction and Facilities Management VA U.S. Department of Veterans Affairs	Drawing Title	Phase	Project Title	Project Number
	www.abovegroupinc.com COA/CA Lic. No. 31120		WBRC ARCHITECTS • ENGINEERS BANGOR, MAINE 207-947-4511 PORTLAND, MAINE 207-838-4511 SARASOTA, FLORIDA 941-556-0757		PLUMBING ISOMETRICS - PRESSURE			CONSTRUCTION DOCUMENTS	PROVIDENCE VAMC MENTAL HEALTH PHASE 2	650-347	
	305 East Dr., Suite H, Melbourne, Florida 32904 PH: 321.345.9026				Approved:			FULLY SPRINKLERED	Location PROVIDENCE, RI	Building Number 39	
									Issue Date FEB 04 2022	Checked ADL	Drawn AJZ

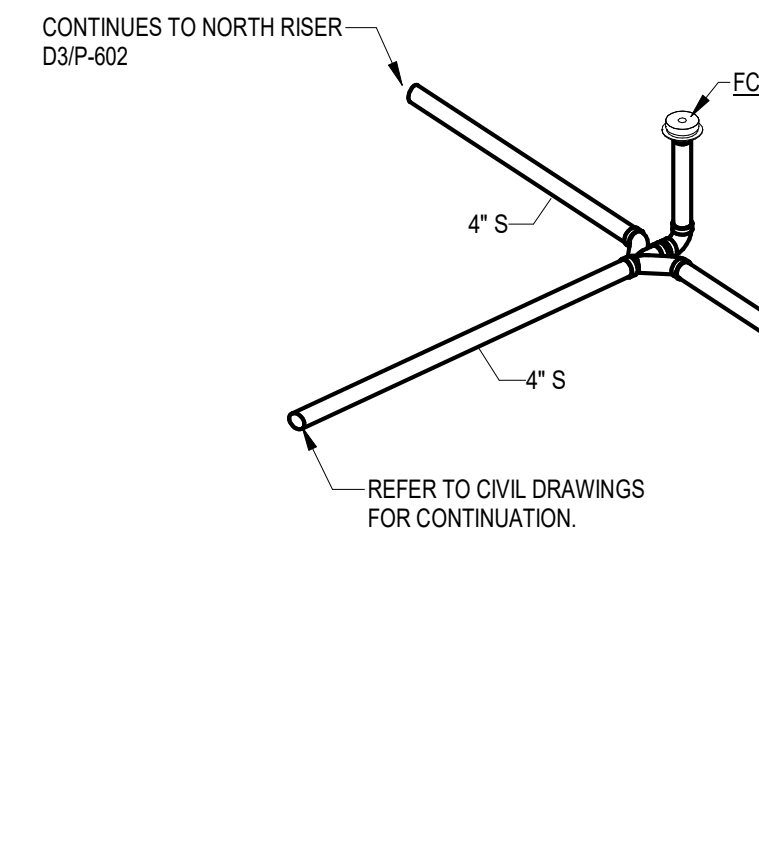

D6 PLUMBING GRAVITY ISOMETRIC - SANITARY - SOUTH
N.T.S.

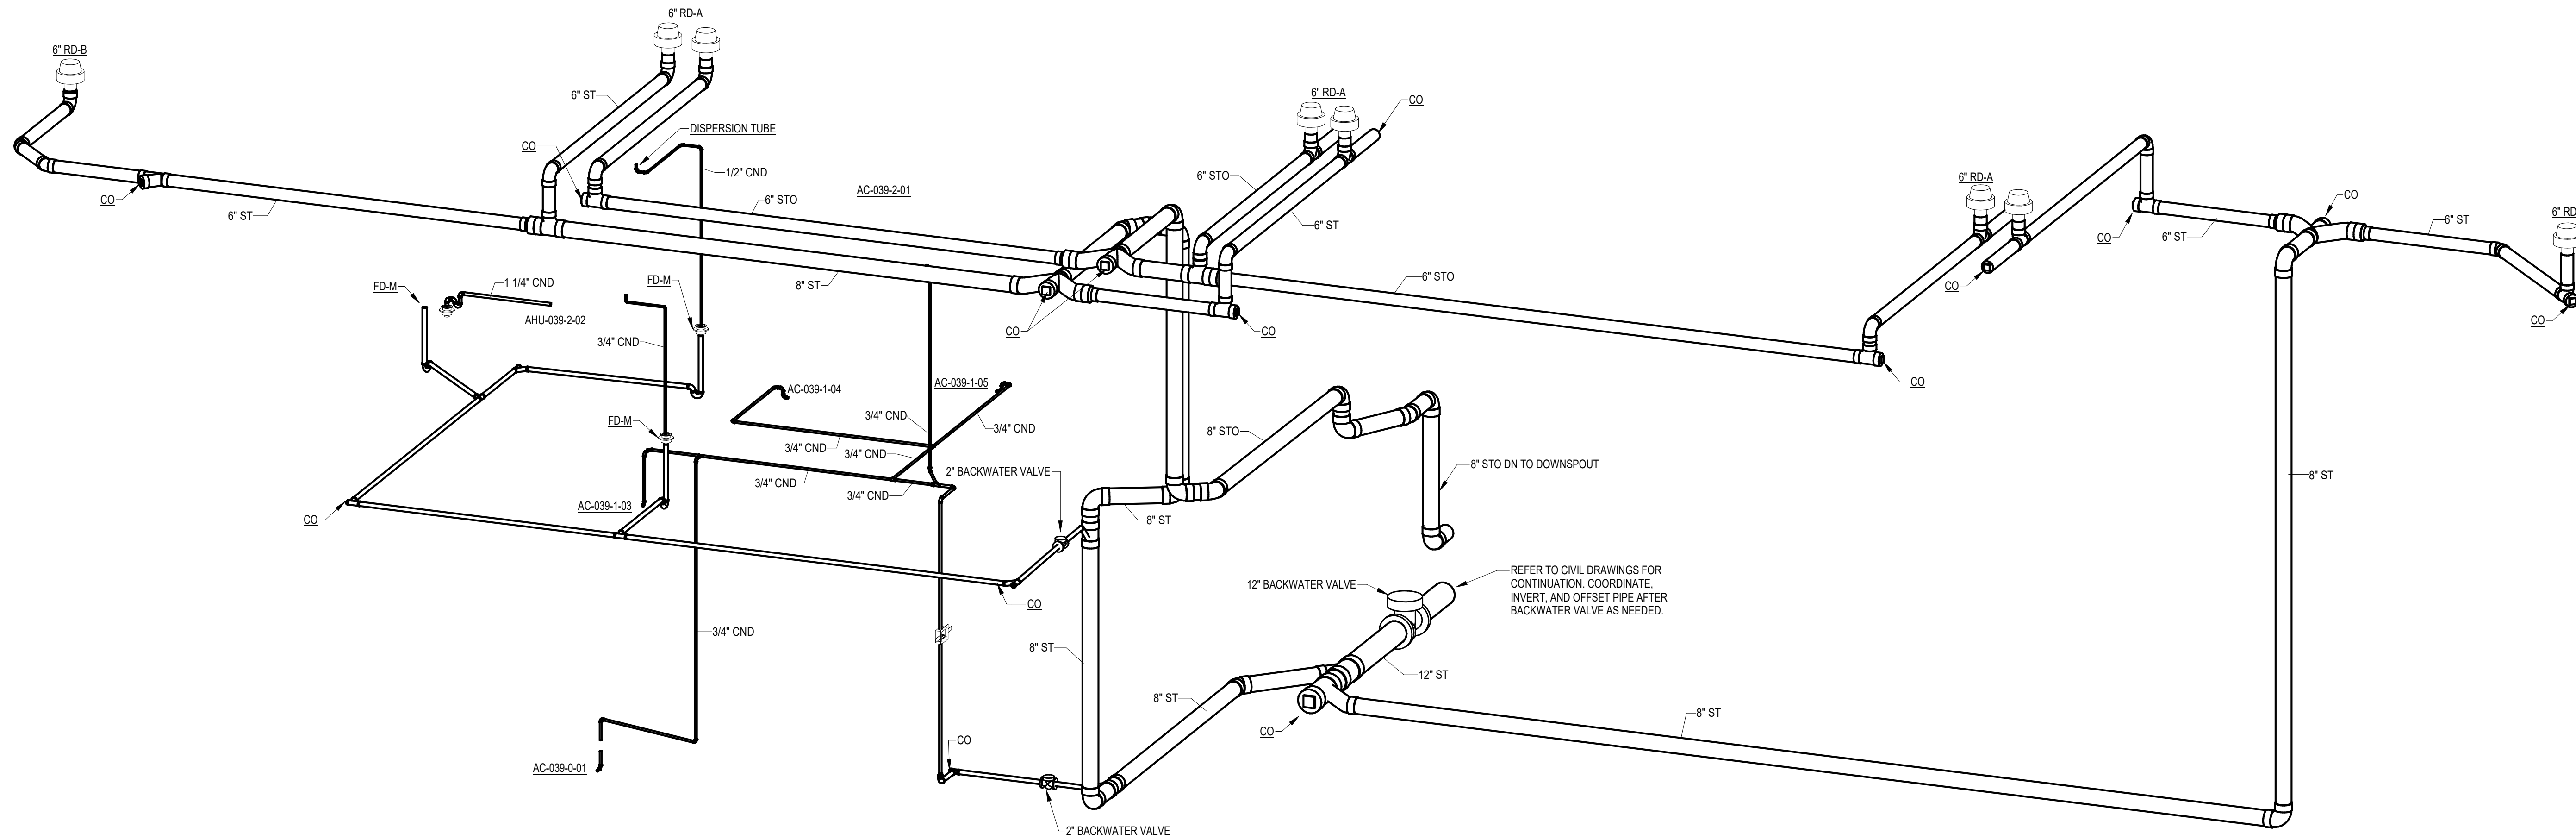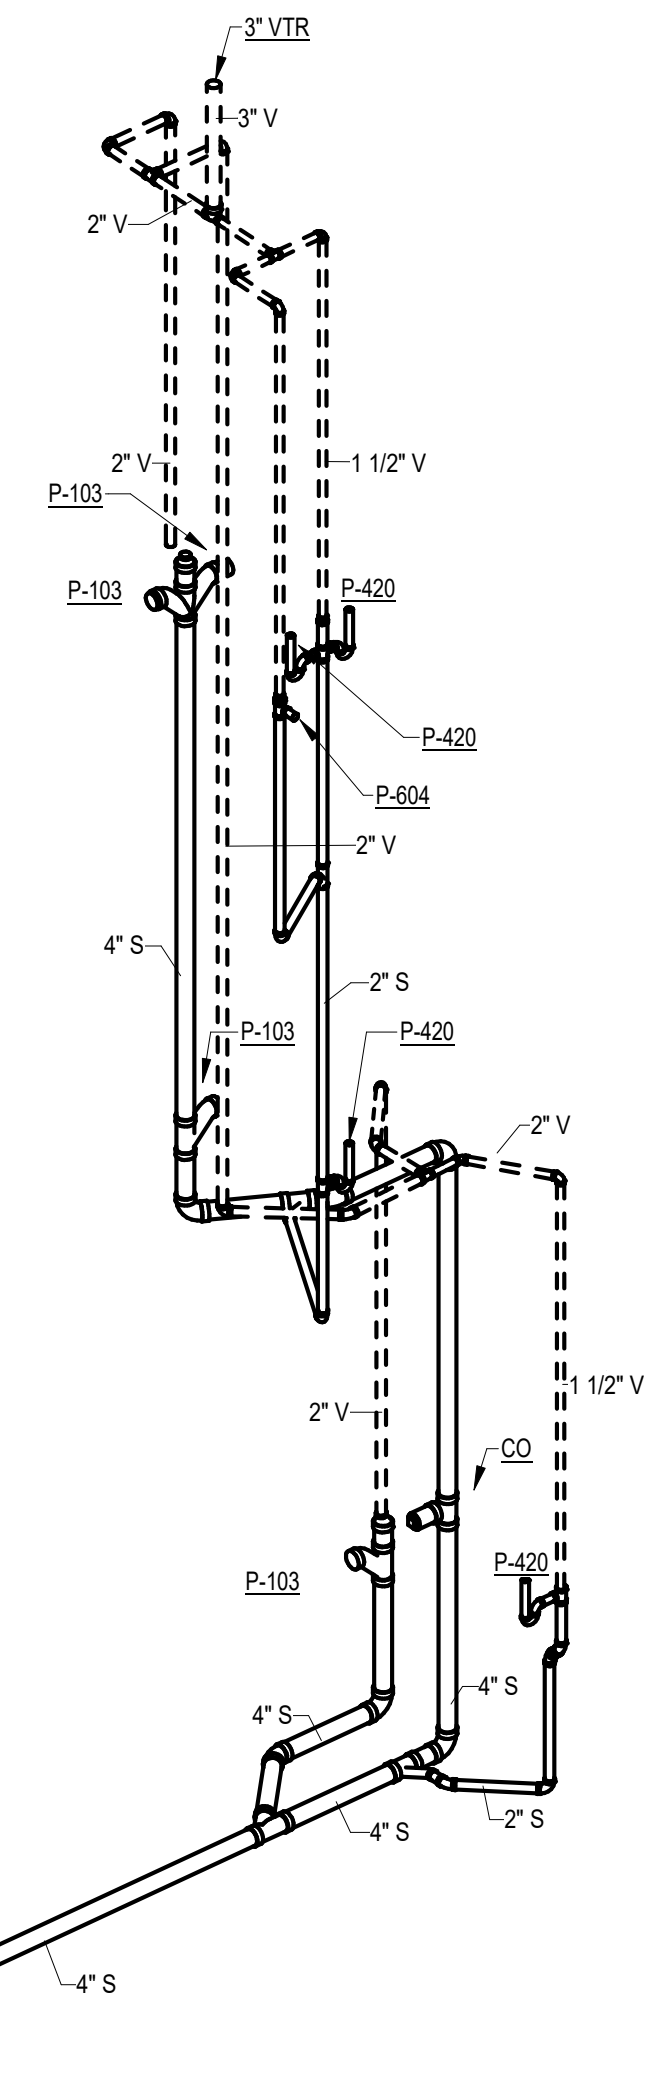

F2 PLUMBING GRAVITY ISOMETRIC - STORM
N.T.S.

Project Number	650-347
Building Number	39
Drawing Number	P-602

