


CHILLED WATER LINE REPLACEMENT TO BUILDING 500 FOR VETERANS ADMINISTRATION VAMC MARTINSBURG, WV


STATE MAP



VICINITY MAP

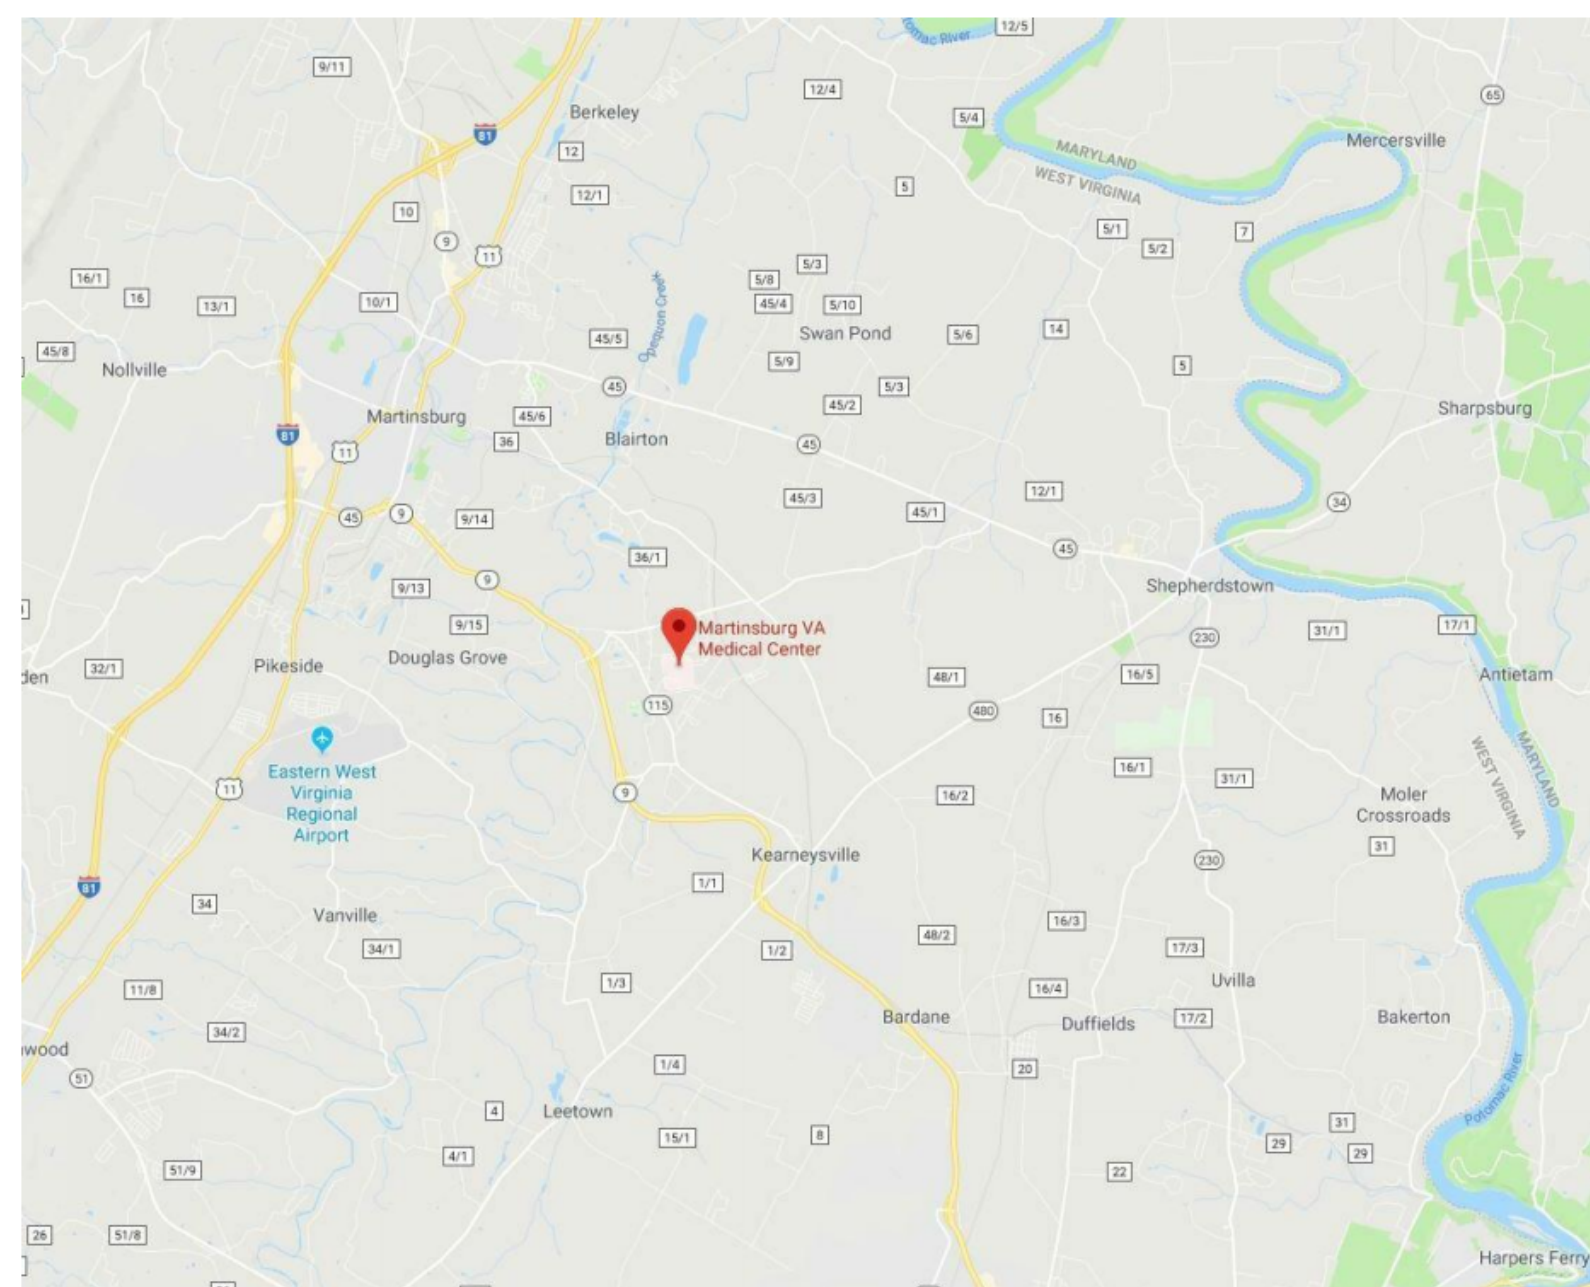

CAMPUS MAP

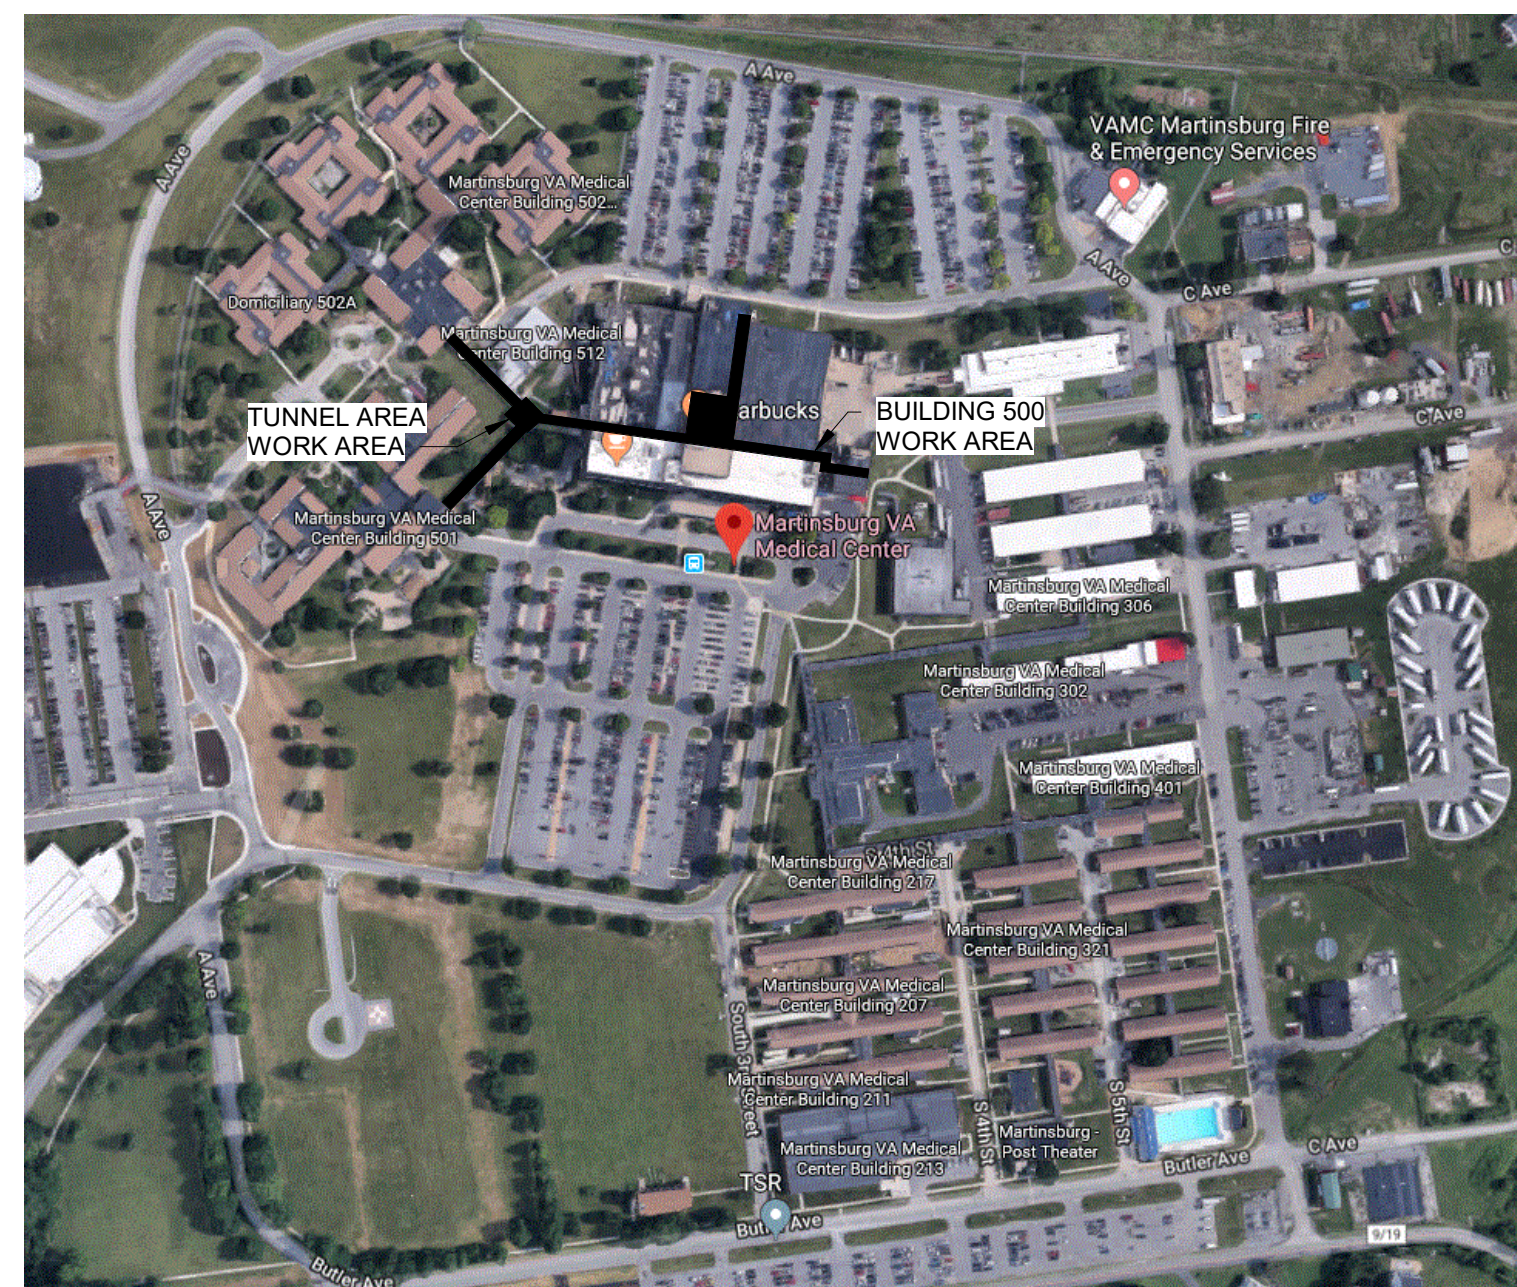

GENERAL

SHEET NUMBER	SHEET TITLE	30% SD TEAM SET 06/05/2019	60% DESIGN DEVELOPMENT 03/05/2020	95% CD SUBMISSION 11/15/2021	BID DOCUMENTS VA REVIEW 03/25/2022	BID DOCUMENTS SUBMISSION 04/22/2022
G0.01	COVER SHEET	X	X	X	X	X

STRUCTURAL

S0.01	STRUCTURAL NOTES				X	X
S2.01t	BASEMENT INTERSTITIAL FRAMING PLAN-TUNNEL				X	X
S2.01ta	BASEMENT INTERSTITIAL FRAMING PLAN-TUNNEL-AREA a				X	X
S2.01tb	BASEMENT INTERSTITIAL FRAMING PLAN-TUNNEL-AREA b				X	X
S2.01tc	BASEMENT INTERSTITIAL FRAMING PLAN-TUNNEL-AREA c				X	X
S2.02	FIRST FLOOR FRAMING PLAN (OVERALL)				X	X
S2.02a	FIRST FLOOR FRAMING PLAN-a				X	X
S2.02b	FIRST FLOOR FRAMING PLAN-b				X	X
S2.02d	FIRST FLOOR FRAMING PLAN-d				X	X
S2.02e	FIRST FLOOR FRAMING PLAN-e				X	X
S2.03	FIRST FLOOR INTERSTITIAL FRAMING PLAN (OVERALL)				X	X
S2.03a	FIRST FLOOR INTERSTITIAL FRAMING PLAN-a				X	X
S2.03d	FIRST FLOOR INTERSTITIAL FRAMING PLAN-d				X	X
S2.04	SECOND FLOOR FRAMING PLAN (OVERALL)				X	X
S2.04a	SECOND FLOOR FRAMING PLAN-a				X	X
S2.04b	SECOND FLOOR FRAMING PLAN-b				X	X
S2.04c	SECOND FLOOR FRAMING PLAN-c				X	X
S2.04d	SECOND FLOOR FRAMING PLAN-d				X	X
S2.04g	SECOND FLOOR FRAMING PLAN-g				X	X
S2.04h	SECOND FLOOR FRAMING PLAN-h				X	X
S4.01	PIPE SUPPORT DETAILS				X	X
S4.02	PIPE SUPPORT DETAILS				X	X

MECHANICAL

M0.01	MECHANICAL LEGENDS, ABBREVIATIONS, AND NOTES		X	X	X	X
M1.01e	MECHANICAL DEMOLITION PIPING - FIRST FLOOR PLAN-e		X	X	X	X
M2.01	MECHANICAL PIPING - BASEMENT INTERSTITIAL KEY PLAN		X	X	X	X
M2.01a	MECHANICAL PIPING - BASEMENT INTERSTITIAL PLAN-a		X	X	X	X
M2.01b	MECHANICAL PIPING - BASEMENT INTERSTITIAL PLAN-b		X	X	X	X
M2.01c	MECHANICAL PIPING - BASEMENT INTERSTITIAL PLAN-c		X	X	X	X
M2.01d	MECHANICAL PIPING - BASEMENT INTERSTITIAL PLAN-d		X	X	X	X
M2.01e	MECHANICAL PIPING - BASEMENT INTERSTITIAL PLAN-e		X	X	X	X
M2.01t	MECHANICAL PIPING - BASEMENT PLAN-TUNNEL		X	X	X	X
M2.01ta	MECHANICAL PIPING - BASEMENT PLAN-TUNNEL - AREA a					X
M2.01tb	MECHANICAL PIPING - BASEMENT PLAN-TUNNEL - AREA b					X
M2.01tc	MECHANICAL PIPING - BASEMENT PLAN-TUNNEL - AREA c					X
M2.02	MECHANICAL PIPING - FIRST FLOOR KEY PLAN		X	X	X	X
M2.02a	MECHANICAL PIPING - FIRST FLOOR PLAN-a		X	X	X	X
M2.02d	MECHANICAL PIPING PHASE-2 FIRST FLOOR PLAN-d		X	X	X	X
M2.03	MECHANICAL PIPING - FIRST FLOOR INTERSTITIAL KEY PLAN		X	X	X	X
M2.03a	MECHANICAL PIPING - FIRST FLOOR INTERSTITIAL PLAN-a		X	X	X	X
M2.03b	MECHANICAL PIPING - FIRST FLOOR INTERSTITIAL PLAN-b		X	X	X	X
M2.03c	MECHANICAL PIPING - FIRST FLOOR INTERSTITIAL PLAN-c		X	X	X	X
M2.03d	MECHANICAL PIPING - FIRST FLOOR INTERSTITIAL PLAN-d		X	X	X	X
M2.03g	MECHANICAL PIPING - FIRST FLOOR INTERSTITIAL PLAN-g		X	X	X	X
M2.03h	MECHANICAL PIPING - FIRST FLOOR INTERSTITIAL PLAN-h		X	X	X	X
M3.01	MECHANICAL PIPING - BASEMENT INTERSTITIAL DEMOLITION KEY PLAN		X	X	X	X
M3.01a	MECHANICAL PIPING - BASEMENT INTERSTITIAL DEMOLITION PLAN-a		X	X	X	X
M3.01b	MECHANICAL PIPING - BASEMENT INTERSTITIAL DEMOLITION PLAN-b		X	X	X	X
M3.01t	MECHANICAL PIPING - TUNNEL DEMOLITION PLAN		X	X	X	X
M4.01	PIPE RISERS		X	X	X	X
M4.02	PIPE SECTIONS AT TUNNEL		X	X	X	X
M4.03	PIPE SECTIONS AT TUNNEL		X	X	X	X
M5.01	MECHANICAL DETAILS		X	X	X	X
M5.02	SEISMIC DETAILS					X
M6.01	TUNNEL PHOTOS					X
M6.02	TUNNEL PHOTOS					X
M6.03	TUNNEL PHOTOS					X
M6.04	TUNNEL PHOTOS					X

ELECTRICAL

E0.01	ELECTRICAL LEGENDS, ABBREVIATIONS, AND NOTES				X	X
E1.01	ELECTRICAL POWER - BASEMENT INTERSTITIAL KEY PLAN				X	X
E1.01a	ELECTRICAL POWER - BASEMENT INTERSTITIAL PLAN-a				X	X
E1.01d	ELECTRICAL POWER - BASEMENT INTERSTITIAL PLAN-d				X	X
E1.01e	ELECTRICAL POWER - BASEMENT INTERSTITIAL PLAN-e				X	X
E1.01ta	ELECTRICAL POWER - BASEMENT PLAN-TUNNEL - AREA a				X	X
E1.03	ELECTRICAL POWER - FIRST FLOOR INTERSTITIAL KEY PLAN				X	X
E1.03a	ELECTRICAL POWER - FIRST FLOOR INTERSTITIAL PLAN-a				X	X
E1.03d	ELECTRICAL POWER - FIRST FLOOR INTERSTITIAL PLAN-d				X	X

BID DOCUMENTS SUBMISSION

Revisions:	Date	CONSULTANTS:	SEAL:	ARCHITECT/ENGINEERS:	Scale: AS NOTED	Drawing Title COVER SHEET	Project Title CHILLED WATER LINE REPLACEMENT BLDG 500	Project Number 613-16-302	Office of Construction and Facilities Management
						Approved: Project Director	Location VAMC - Martinsburg, WV	Building Number 500	Department of Veterans Affairs
						BID DOCUMENTS	Date 04/22/2022	Drawing Number G0.01	
							Checked BK	Drawn JCH	Dwg. 1 of 67