
 
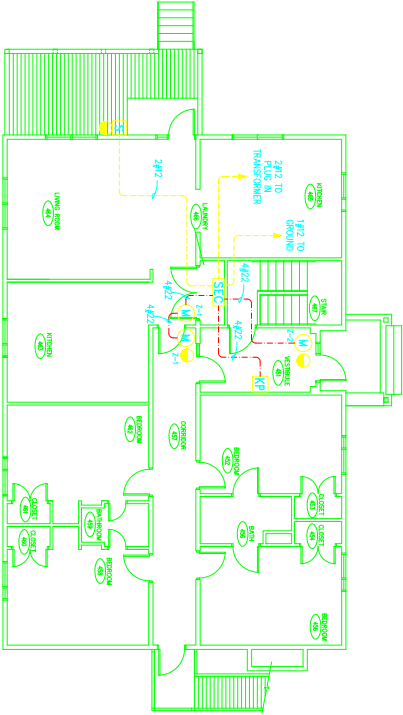

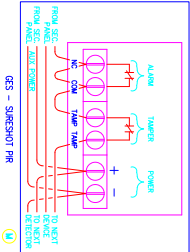


DORMITORY LOWER LEVEL FLOOR PLAN
SCALE: 1/8" = 1'-0"

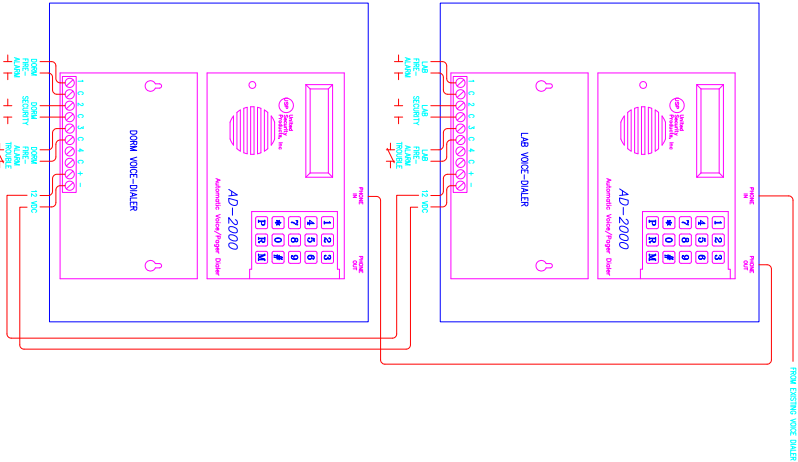

DORMITORY UPPER LEVEL FLOOR PLAN
SCALE: 1/8" = 1'-0"

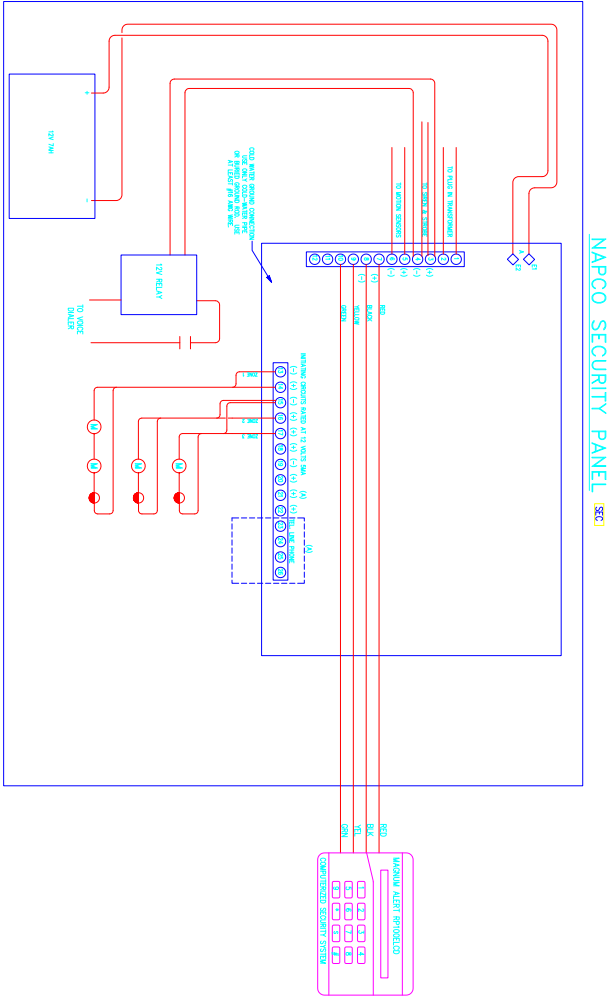

INSTALLATION NOTES:

1.) FIELD LOCATE EXACT LOCATION OF DIALER.

SimplexGrinnell
5430 FAIRBANKS ST., SUITE #7
ANCHORAGE, ALASKA 99518
(907) 561-1911 FAX (907) 561-4650

tyco Fire & Security

UL Underwriters Laboratories Inc.
Listed Alarm Service Company
Certificate Number S3253 ULUS

**NATIONAL INSTITUTE FOR CERTIFICATION
IN EMERGENCY TECHNOLOGIES**
CERTIFIED TECHNOLOGIST

CONTRACTOR/INSTALLER	
PUFFIN ELECTRIC HOMER, ALASKA	
AS-BUILT (05/26/05)	APPROVED
REVISION DESCRIPTION	
8	

KASITSNA BAY NOAA	
KASITSNA BAY, ALASKA	
PROJECT NAME:	
DORMITORY - LOWER & UPPER FLOOR PLAN	
SYSTEM:	
SECURITY DEVICE LAYOUT	
THIS DRAWING AND THE INFORMATION AND DESIGN APPLICATION HEREIN CONTAINED IS THE PROPERTY OF GRINNELL FIRE PROTECTION COMPANY, INC. AND IS TO BE KEPT IN CONFIDENTIALITY AND NOT TO BE REPRODUCED OR TRANSMITTED IN ANY FORM OR BY ANY MEANS, ELECTRONIC OR MECHANICAL, INCLUDING PHOTOCOPYING, RECORDING, OR BY ANY INFORMATION STORAGE AND RETRIEVAL SYSTEM, WITHOUT THE WRITTEN PERMISSION OF GRINNELL FIRE PROTECTION COMPANY, INC.	

DRAWN BY:	D-J-B
APPROVED BY:	D-J-B
DATE DESIGNED:	09/20/04
REvised DATE:	05/26/05
SCALE:	1/8" = 1'-0"
DWG NUMBER:	BD092901
CNO NUMBER:	04-116-04

CATEGORY:	OFFICE
SEC:	4-8
DATE:	2004
REVISION:	04