

A

A

B

B

C

C

D

D


E

E


F


F


three inches = one foot
one and one half inches = one foot
one inch = one foot
three quarters inch = one foot
one half inch = one foot
three eighths inch = one foot
one quarter inch = one foot
one eighth inch = one foot

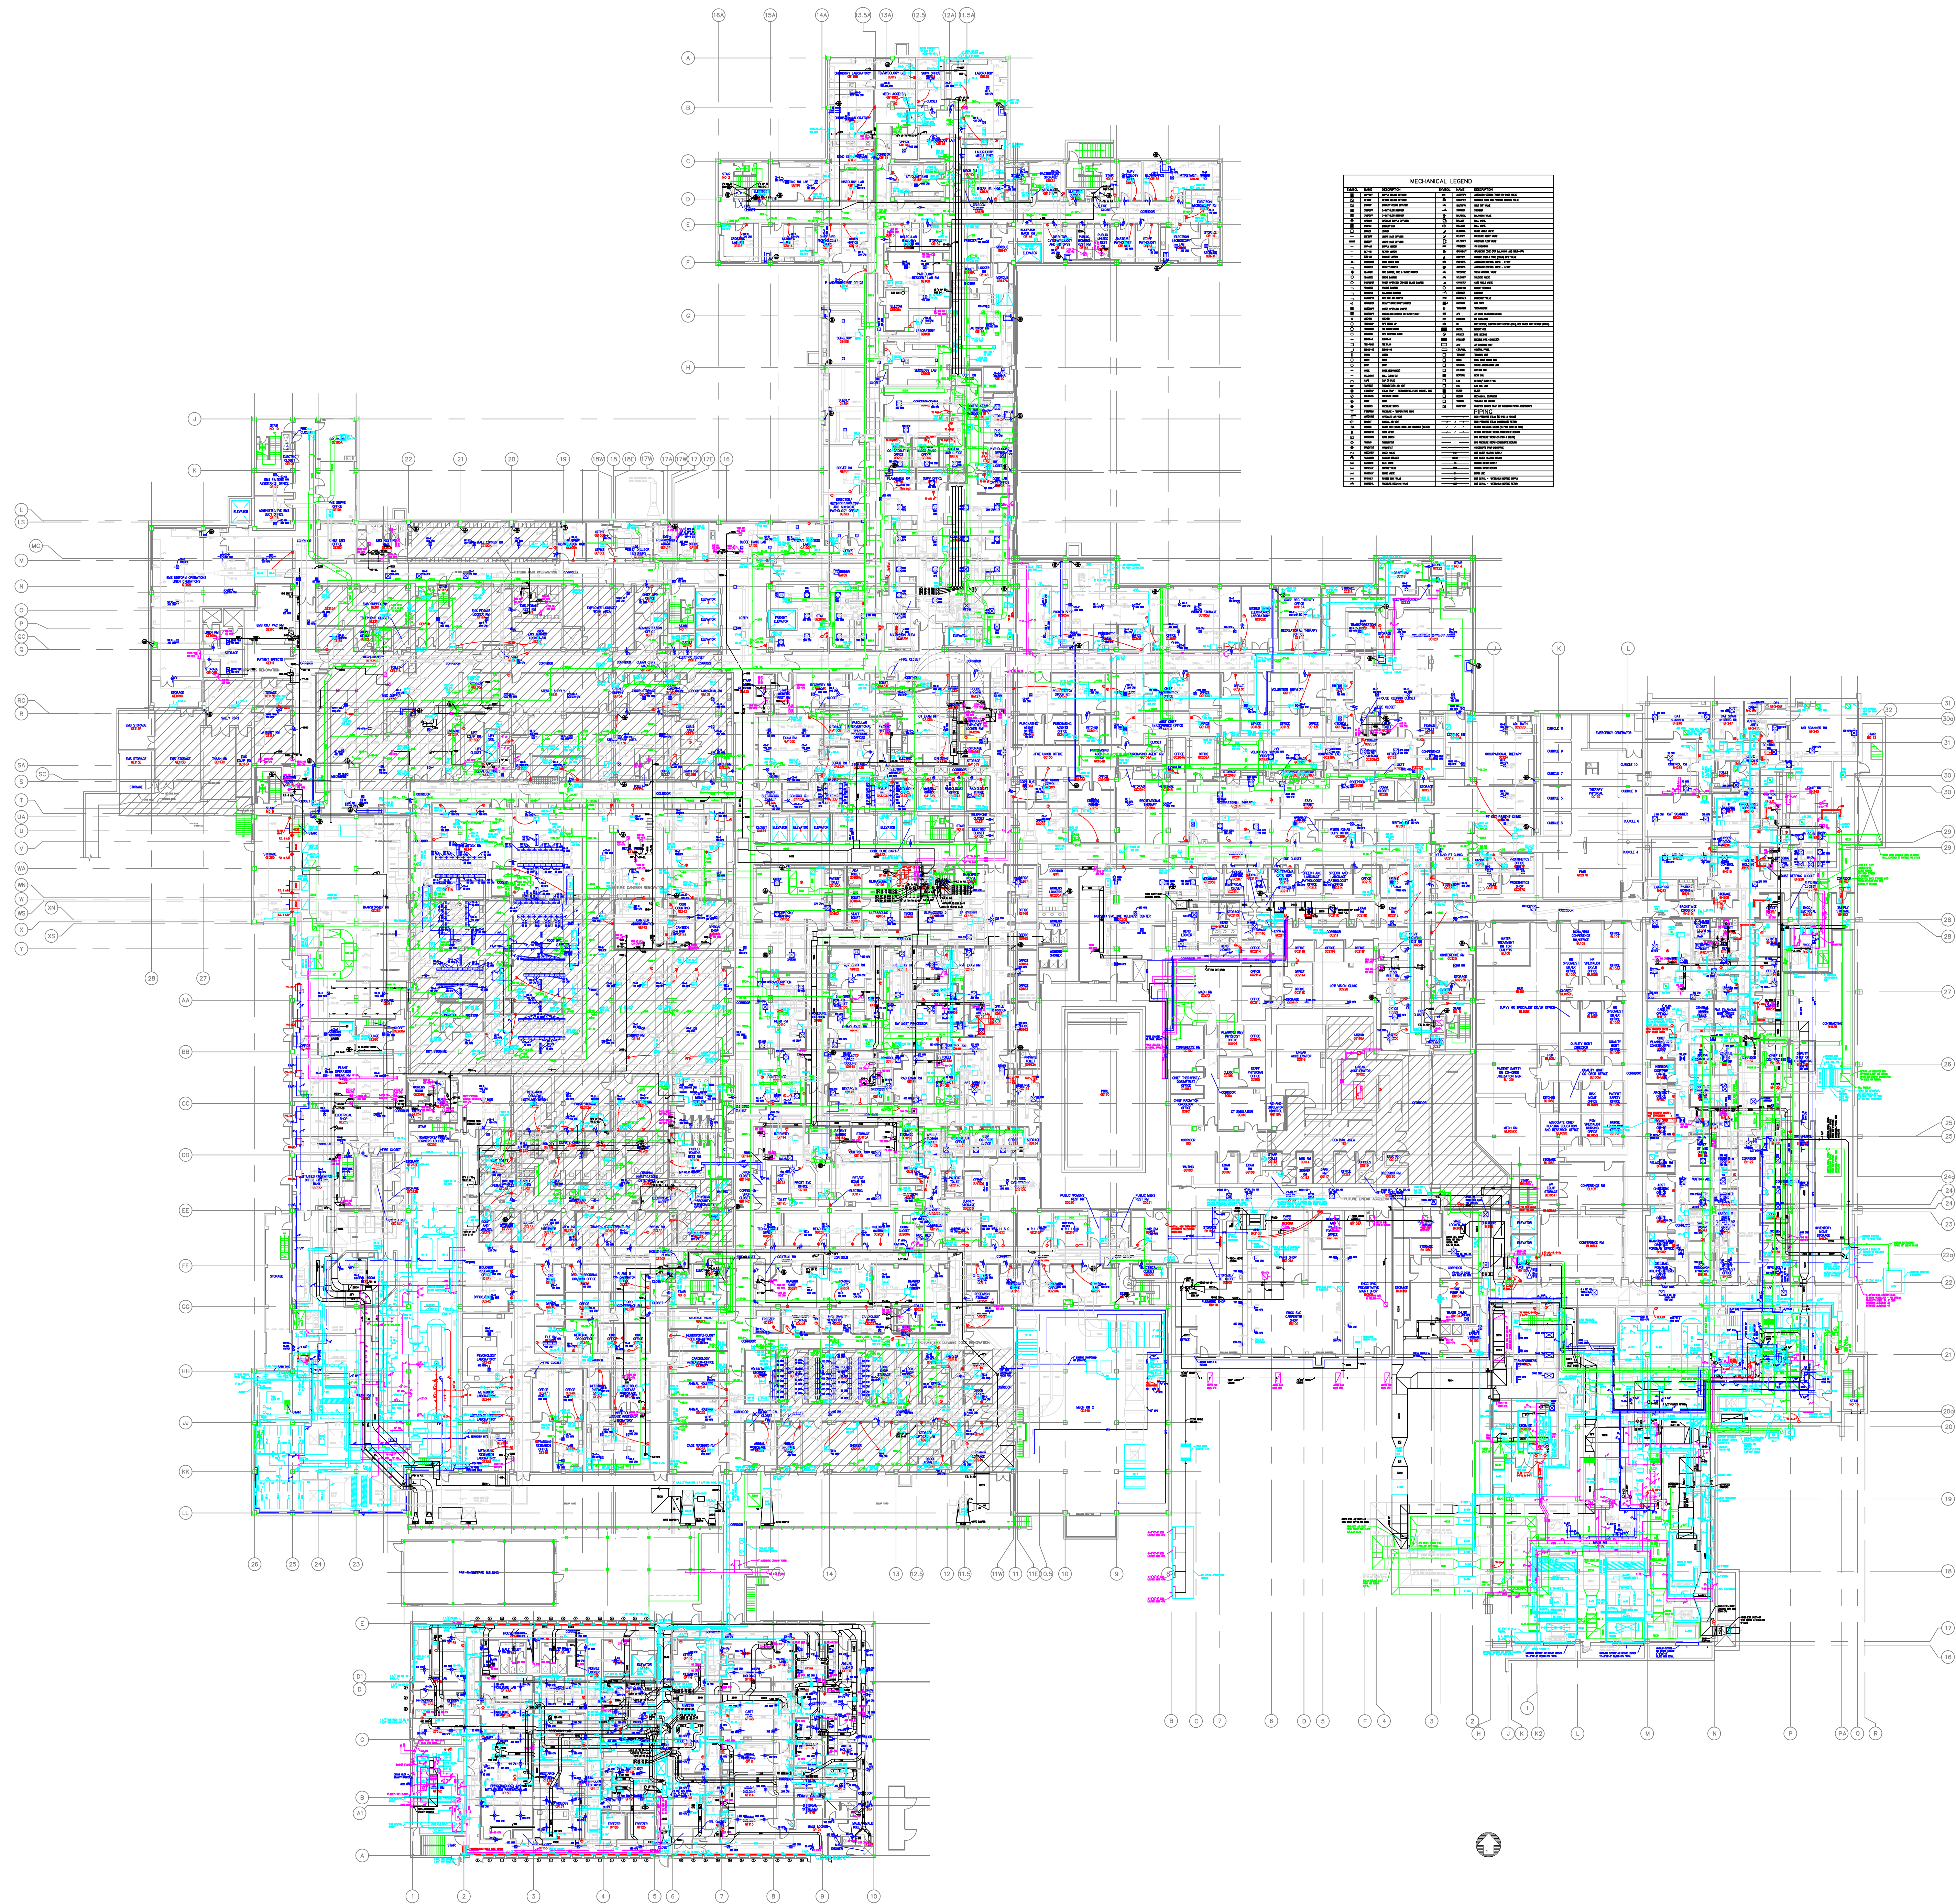

MECHANICAL LEGEND	
1. AIR HANDLING UNIT	1. AIR HANDLING UNIT
2. AIR FILTER	2. AIR FILTER
3. AIR COIL	3. AIR COIL
4. AIR COIL	4. AIR COIL
5. AIR COIL	5. AIR COIL
100. AIR COIL	100. AIR COIL

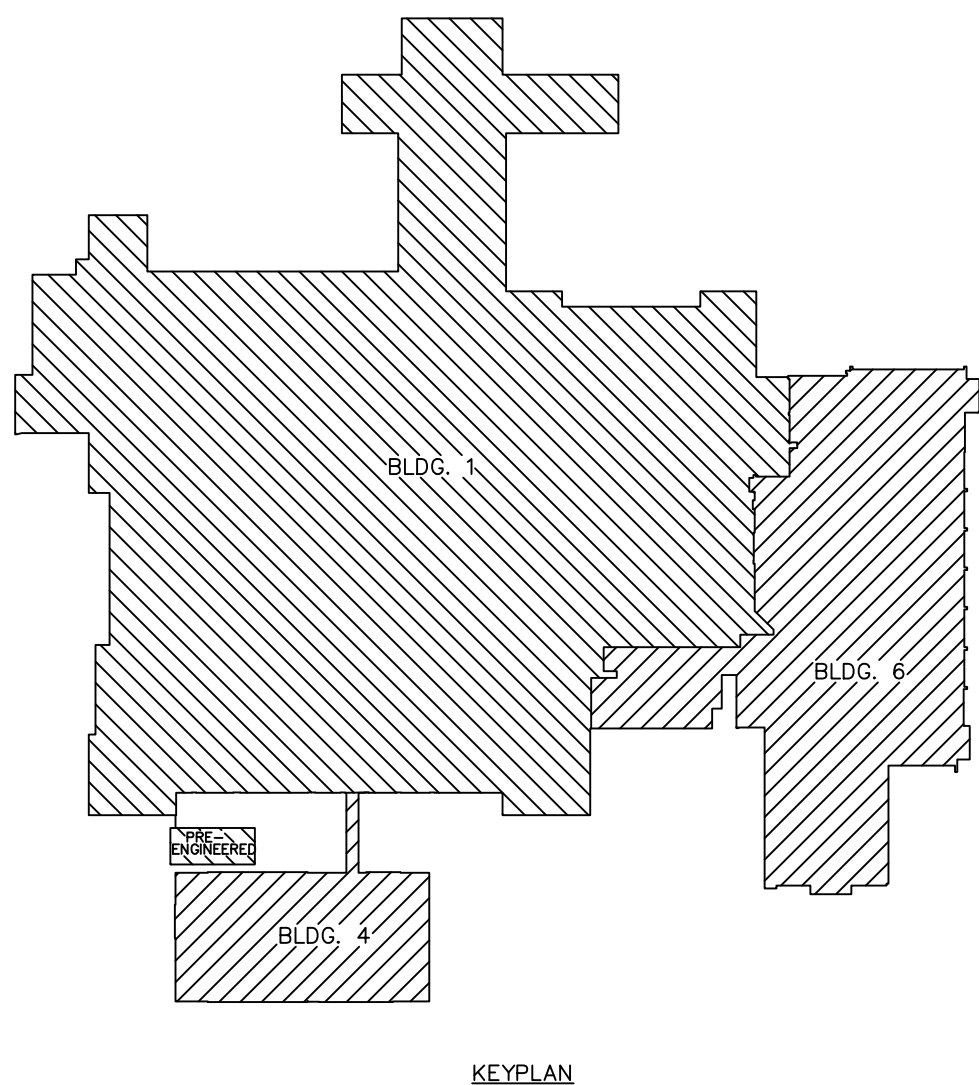


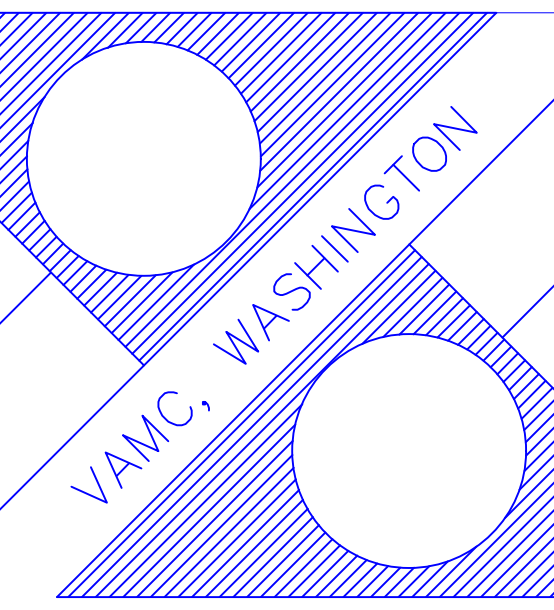
Revisions		Date	Professional Seal		Drawing Title BASEMENT FLOOR PLAN MECHANICAL	Project Title AS-BUILT Drawings	Date 05-12-2007			Department of Veterans Affairs	
Approved:			Approved:			Building Number 01, 04, 06	Checked	Drawn	Project No.		
Approved:			Approved:			Location VAMC, WASHINGTON WASHINGTON D.C.	Drawing No.				

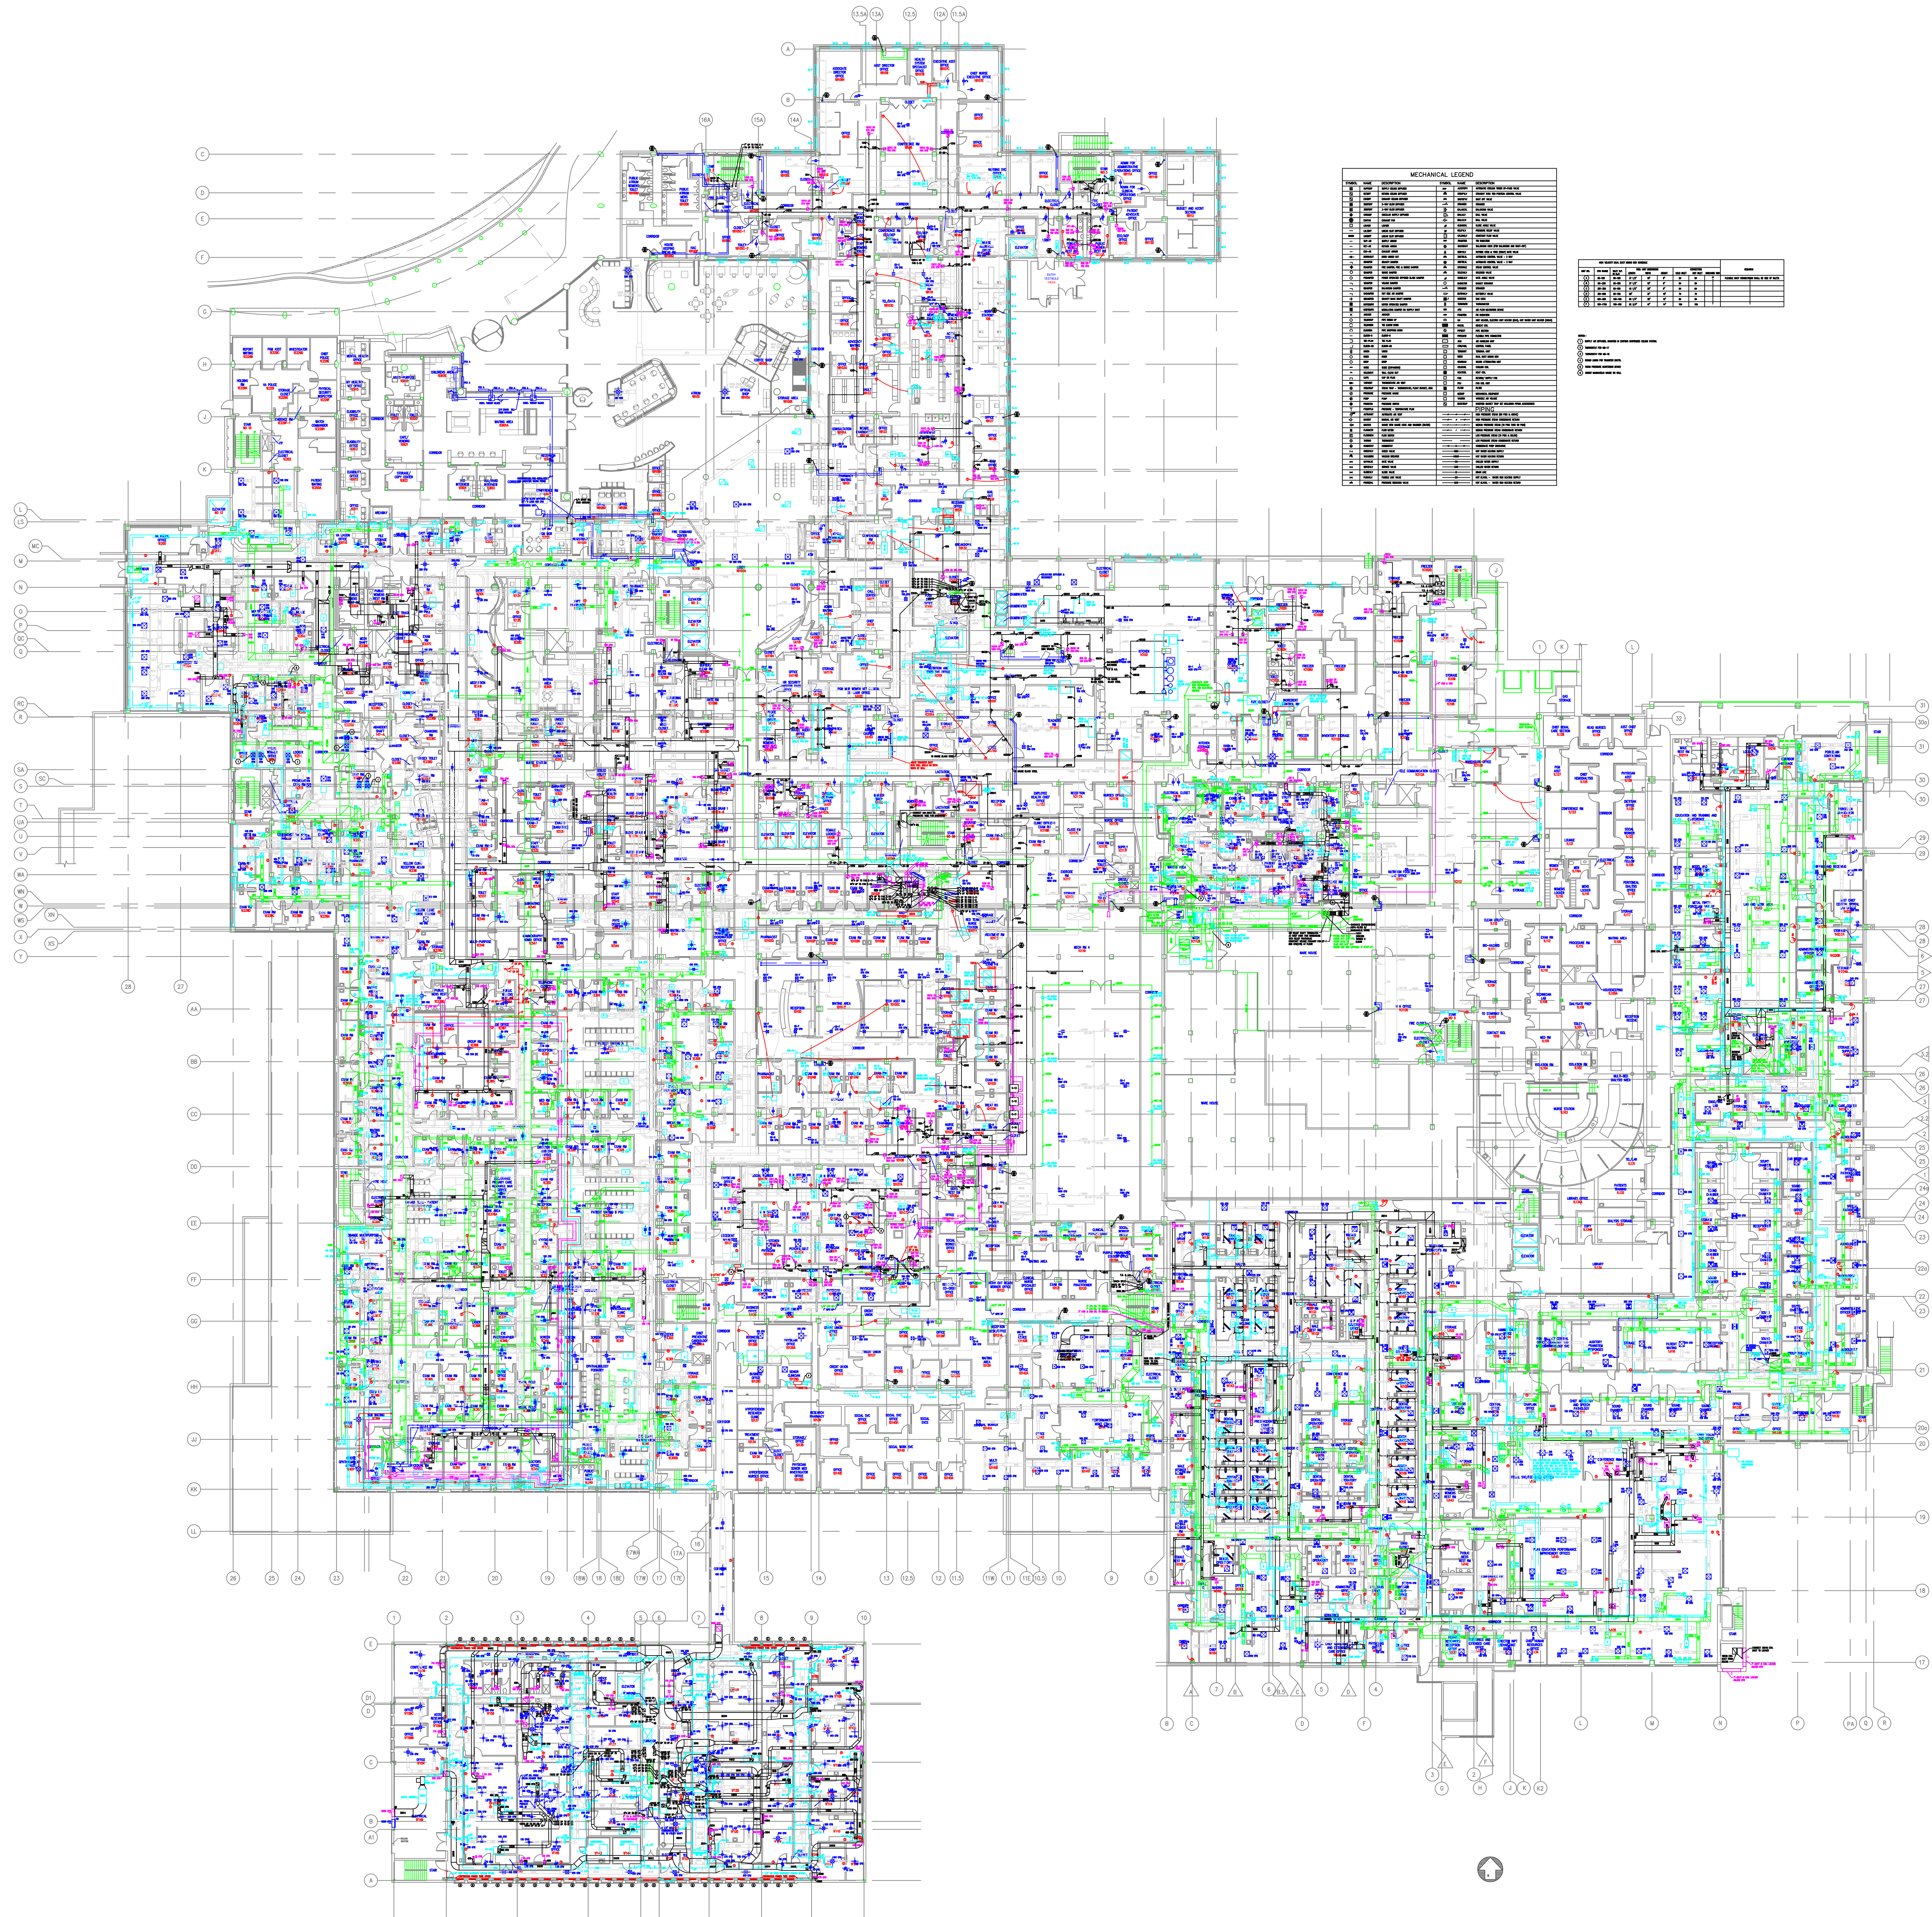

MECHANICAL LEGEND	
1. 1" DIA. STEEL PIPE	1. 1" DIA. STEEL PIPE
2. 1 1/2" DIA. STEEL PIPE	2. 1 1/2" DIA. STEEL PIPE
3. 2" DIA. STEEL PIPE	3. 2" DIA. STEEL PIPE
4. 2 1/2" DIA. STEEL PIPE	4. 2 1/2" DIA. STEEL PIPE
5. 3" DIA. STEEL PIPE	5. 3" DIA. STEEL PIPE
6. 3 1/2" DIA. STEEL PIPE	6. 3 1/2" DIA. STEEL PIPE
7. 4" DIA. STEEL PIPE	7. 4" DIA. STEEL PIPE
8. 4 1/2" DIA. STEEL PIPE	8. 4 1/2" DIA. STEEL PIPE
9. 5" DIA. STEEL PIPE	9. 5" DIA. STEEL PIPE
10. 5 1/2" DIA. STEEL PIPE	10. 5 1/2" DIA. STEEL PIPE
11. 6" DIA. STEEL PIPE	11. 6" DIA. STEEL PIPE
12. 6 1/2" DIA. STEEL PIPE	12. 6 1/2" DIA. STEEL PIPE
13. 8" DIA. STEEL PIPE	13. 8" DIA. STEEL PIPE
14. 10" DIA. STEEL PIPE	14. 10" DIA. STEEL PIPE
15. 12" DIA. STEEL PIPE	15. 12" DIA. STEEL PIPE
16. 14" DIA. STEEL PIPE	16. 14" DIA. STEEL PIPE
17. 16" DIA. STEEL PIPE	17. 16" DIA. STEEL PIPE
18. 18" DIA. STEEL PIPE	18. 18" DIA. STEEL PIPE
19. 20" DIA. STEEL PIPE	19. 20" DIA. STEEL PIPE
20. 22" DIA. STEEL PIPE	20. 22" DIA. STEEL PIPE
21. 24" DIA. STEEL PIPE	21. 24" DIA. STEEL PIPE
22. 26" DIA. STEEL PIPE	22. 26" DIA. STEEL PIPE
23. 28" DIA. STEEL PIPE	23. 28" DIA. STEEL PIPE
24. 30" DIA. STEEL PIPE	24. 30" DIA. STEEL PIPE
25. 32" DIA. STEEL PIPE	25. 32" DIA. STEEL PIPE
26. 34" DIA. STEEL PIPE	26. 34" DIA. STEEL PIPE
27. 36" DIA. STEEL PIPE	27. 36" DIA. STEEL PIPE
28. 38" DIA. STEEL PIPE	28. 38" DIA. STEEL PIPE
29. 40" DIA. STEEL PIPE	29. 40" DIA. STEEL PIPE
30. 42" DIA. STEEL PIPE	30. 42" DIA. STEEL PIPE
31. 44" DIA. STEEL PIPE	31. 44" DIA. STEEL PIPE
32. 46" DIA. STEEL PIPE	32. 46" DIA. STEEL PIPE
33. 48" DIA. STEEL PIPE	33. 48" DIA. STEEL PIPE
34. 50" DIA. STEEL PIPE	34. 50" DIA. STEEL PIPE

SYMBOL	DESCRIPTION
1	1" DIA. STEEL PIPE
2	1 1/2" DIA. STEEL PIPE
3	2" DIA. STEEL PIPE
4	2 1/2" DIA. STEEL PIPE
5	3" DIA. STEEL PIPE
6	3 1/2" DIA. STEEL PIPE
7	4" DIA. STEEL PIPE
8	4 1/2" DIA. STEEL PIPE
9	5" DIA. STEEL PIPE
10	5 1/2" DIA. STEEL PIPE
11	6" DIA. STEEL PIPE
12	6 1/2" DIA. STEEL PIPE
13	8" DIA. STEEL PIPE
14	10" DIA. STEEL PIPE
15	12" DIA. STEEL PIPE
16	14" DIA. STEEL PIPE
17	16" DIA. STEEL PIPE
18	18" DIA. STEEL PIPE
19	20" DIA. STEEL PIPE
20	22" DIA. STEEL PIPE
21	24" DIA. STEEL PIPE
22	26" DIA. STEEL PIPE
23	28" DIA. STEEL PIPE
24	30" DIA. STEEL PIPE
25	32" DIA. STEEL PIPE
26	34" DIA. STEEL PIPE
27	36" DIA. STEEL PIPE
28	38" DIA. STEEL PIPE
29	40" DIA. STEEL PIPE
30	42" DIA. STEEL PIPE
31	44" DIA. STEEL PIPE
32	46" DIA. STEEL PIPE
33	48" DIA. STEEL PIPE
34	50" DIA. STEEL PIPE

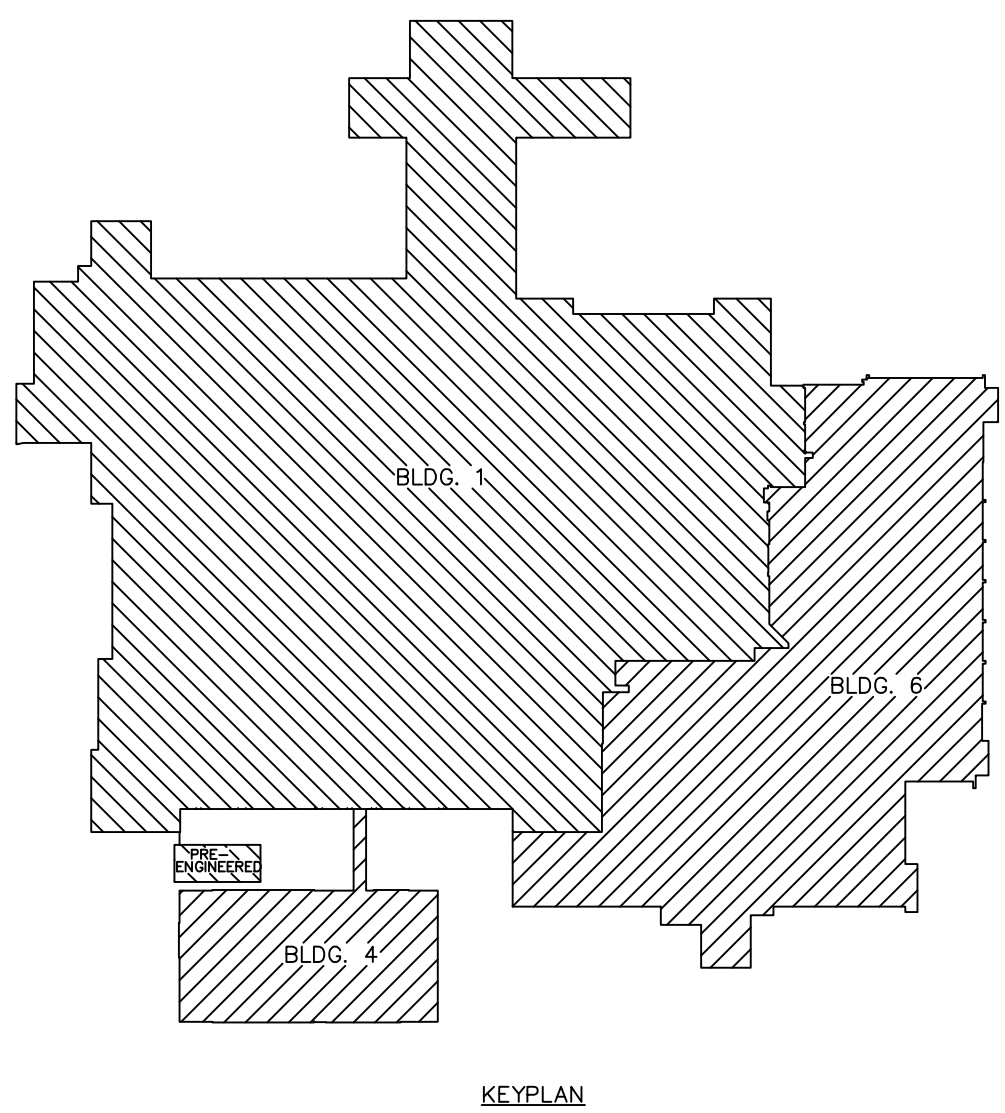

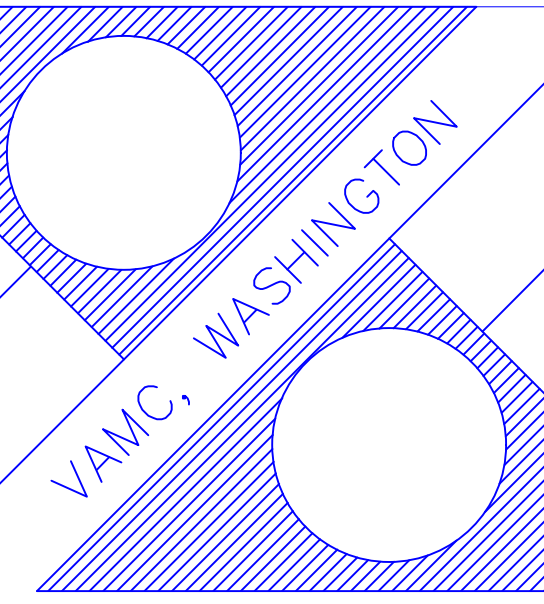Revisions		Date	Professional Seal		Drawing Title FIRST FLOOR PLAN MECHANICAL	Project Title AS-BUILT Drawings	Date 05-12-2007			Department of Veterans Affairs	
Approved:			Approved:			Building Number 01, 04, 06	Checked Drawn				
Approved:			Approved:			Location VAMC, WASHINGTON WASHINGTON D.C.					

A

B

C

D

E

F

A

B

C

D

E

F

three inches = one foot

one and one half inches = one foot

one inch = one foot


three quarters inch = one foot

one half inch = one foot

three eighths inch = one foot


one quarter inch = one foot


one eighth inch = one foot

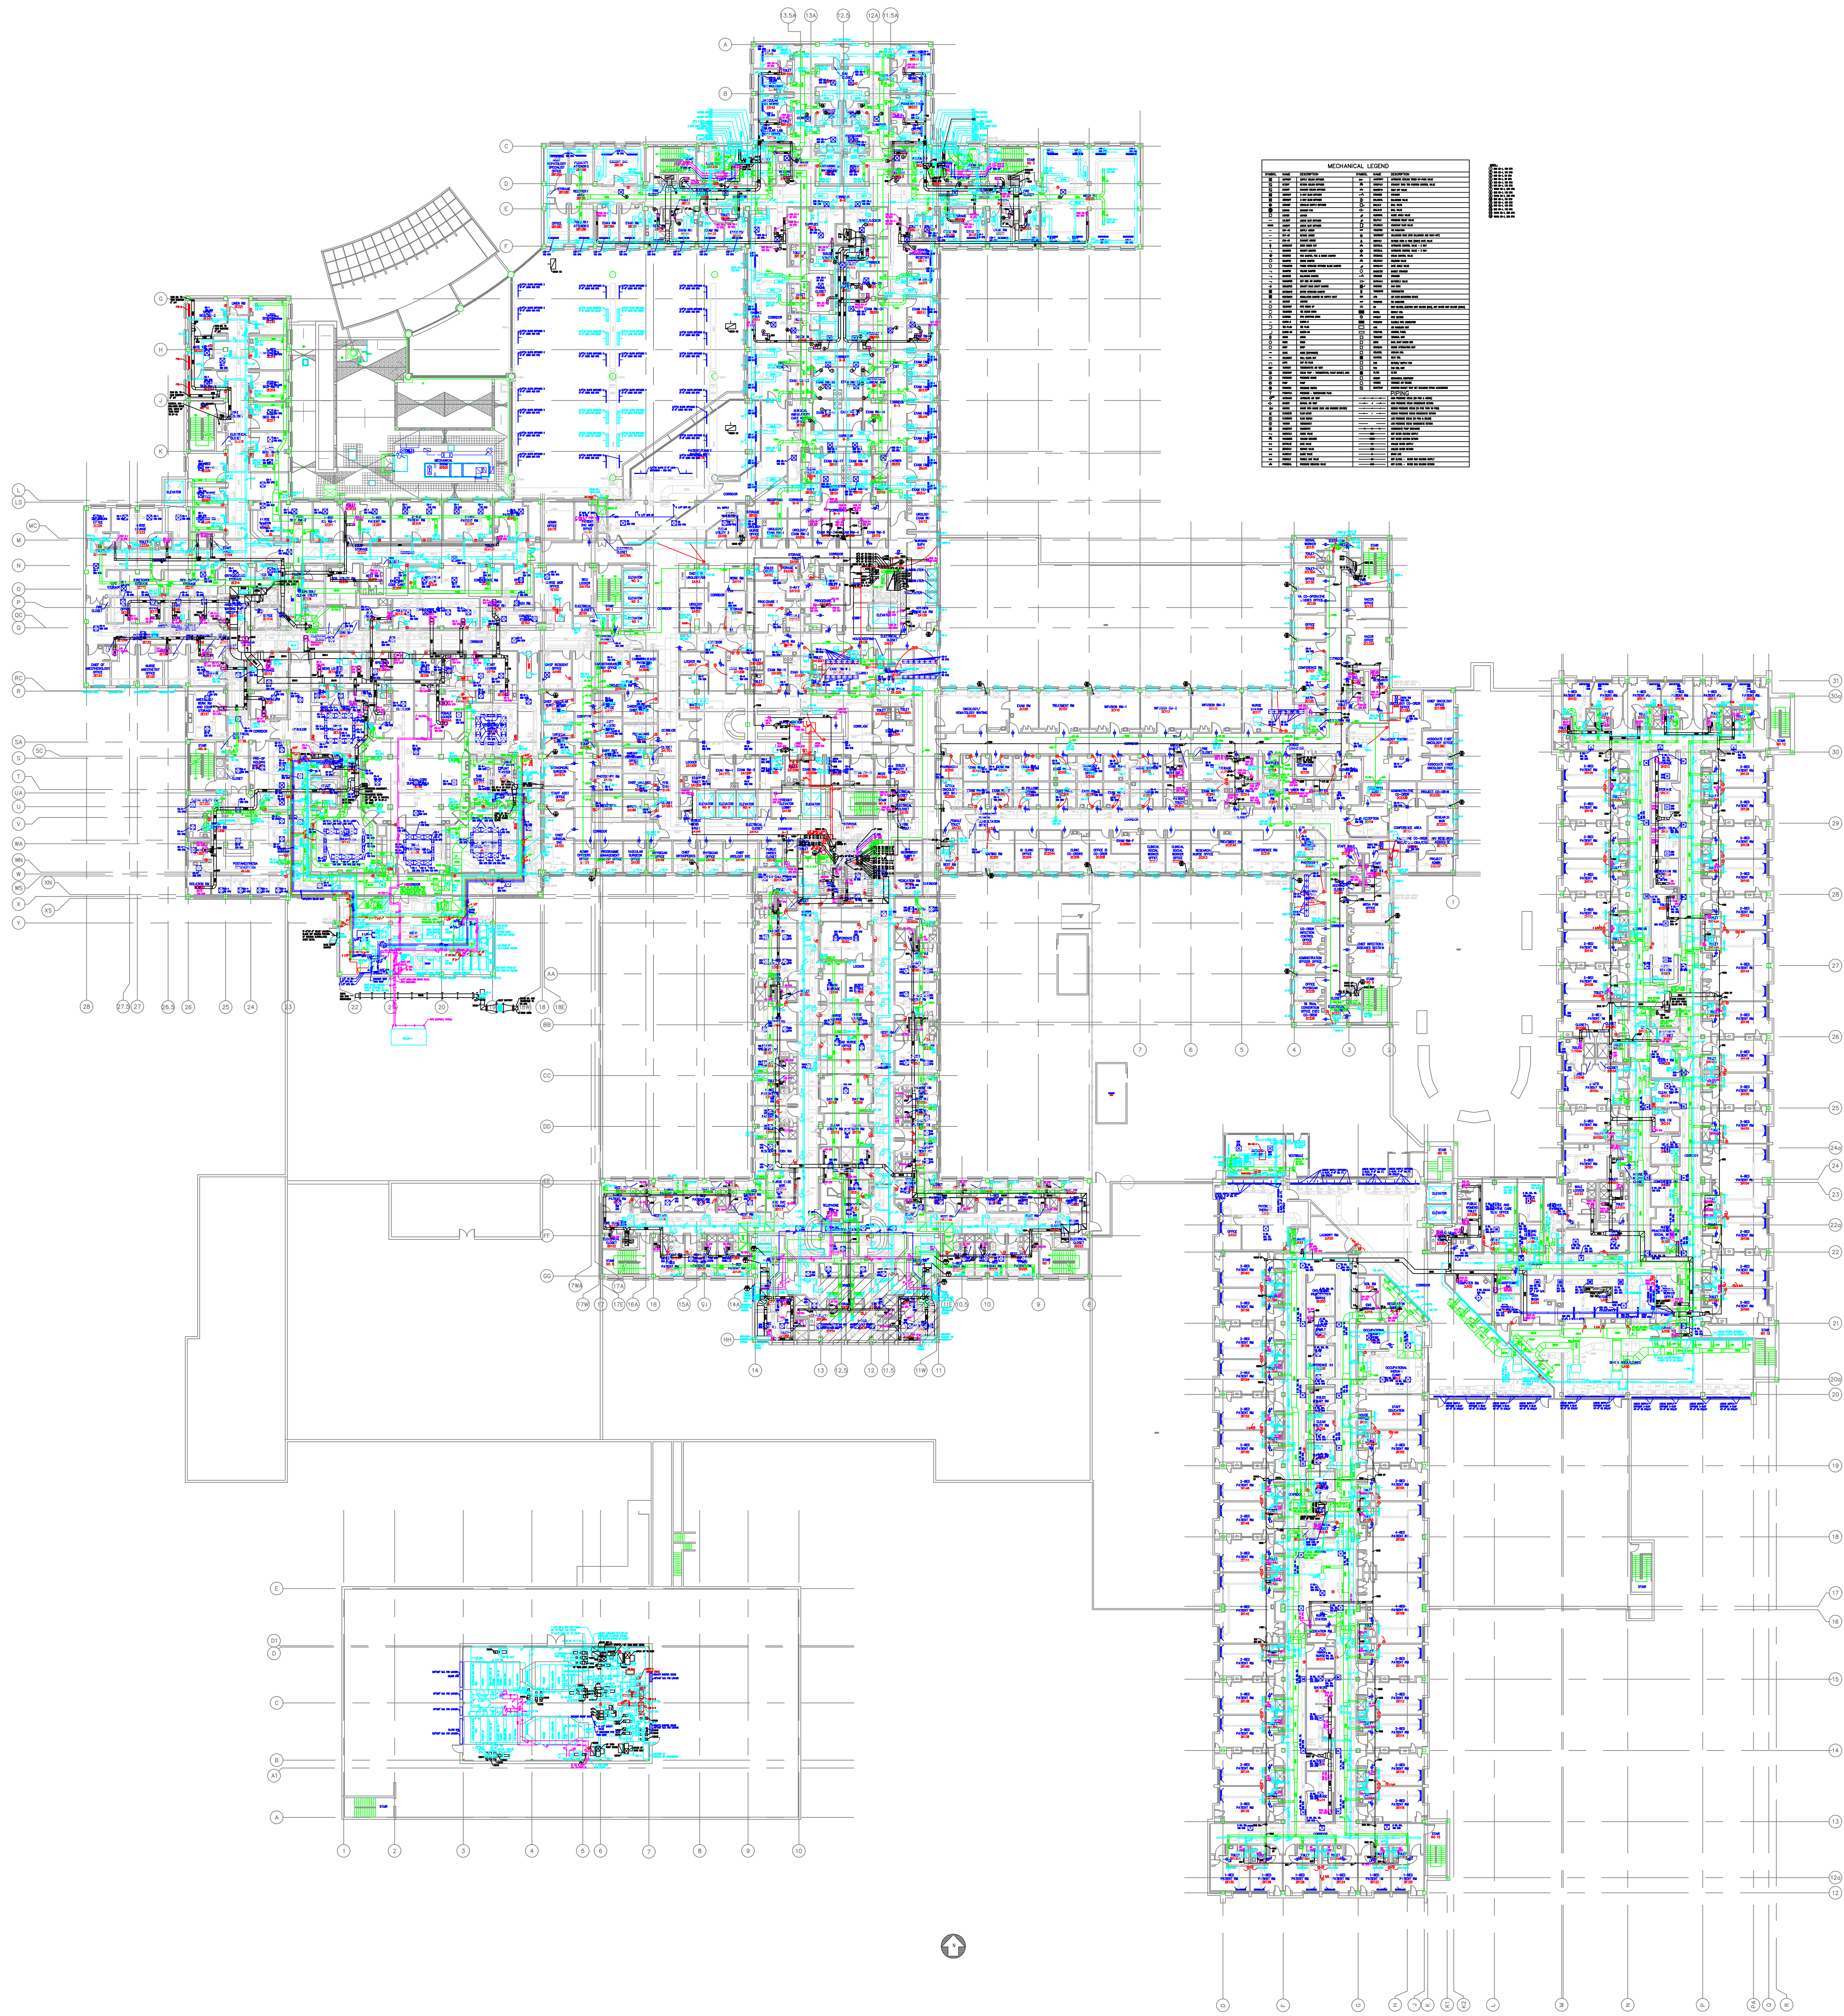

MECHANICAL LEGEND	
1	2
3	4
5	6
7	8
9	10
11	12
13	14
15	16
17	18
19	20
21	22
23	24
25	26
27	28
29	30
31	32
33	34
35	36
37	38
39	40
41	42
43	44
45	46
47	48
49	50
51	52
53	54
55	56
57	58
59	60
61	62
63	64
65	66
67	68
69	70
71	72
73	74
75	76
77	78
79	80
81	82
83	84
85	86
87	88
89	90
91	92
93	94
95	96
97	98
99	100

MECHANICAL LEGEND

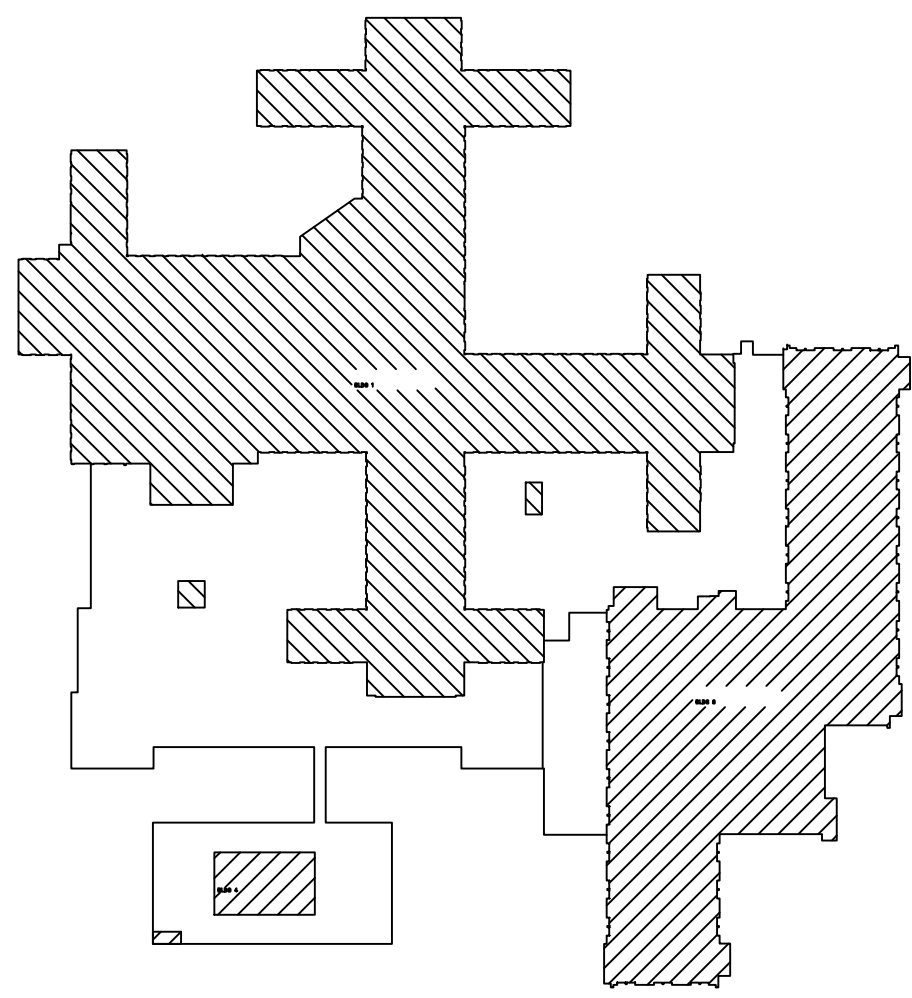

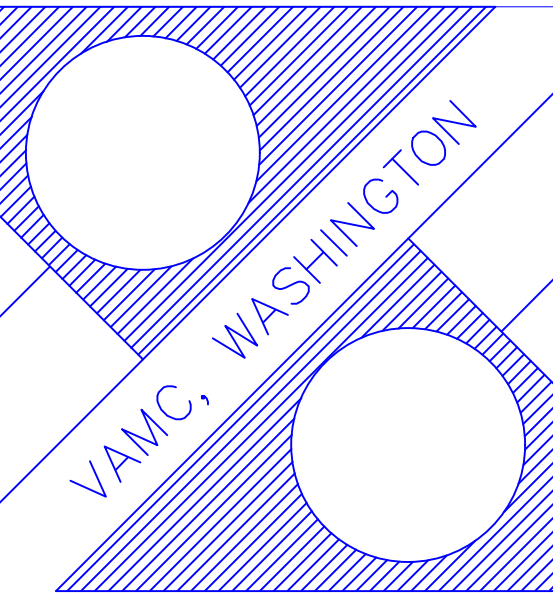Revisions		Date	Professional Seal		Drawing Title SECOND FLOOR PLAN MECHANICAL	Project Title AS-BUILT Drawings		Date 05-12-2007		Department of Veterans Affairs	
					Approved:	Building Number 01, 04, 06	Checked	Drawn			Project No.
					Approved:	Location VAMC, WASHINGTON WASHINGTON D.C.		Drawing No.			

A

B

C

D

E

F

A

B

C

D

E

F

three inches = one foot

one and one half inches = one foot

one inch = one foot


three quarters inch = one foot

one half inch = one foot

three eighths inch = one foot

one quarter inch = one foot

one eighth inch = one foot

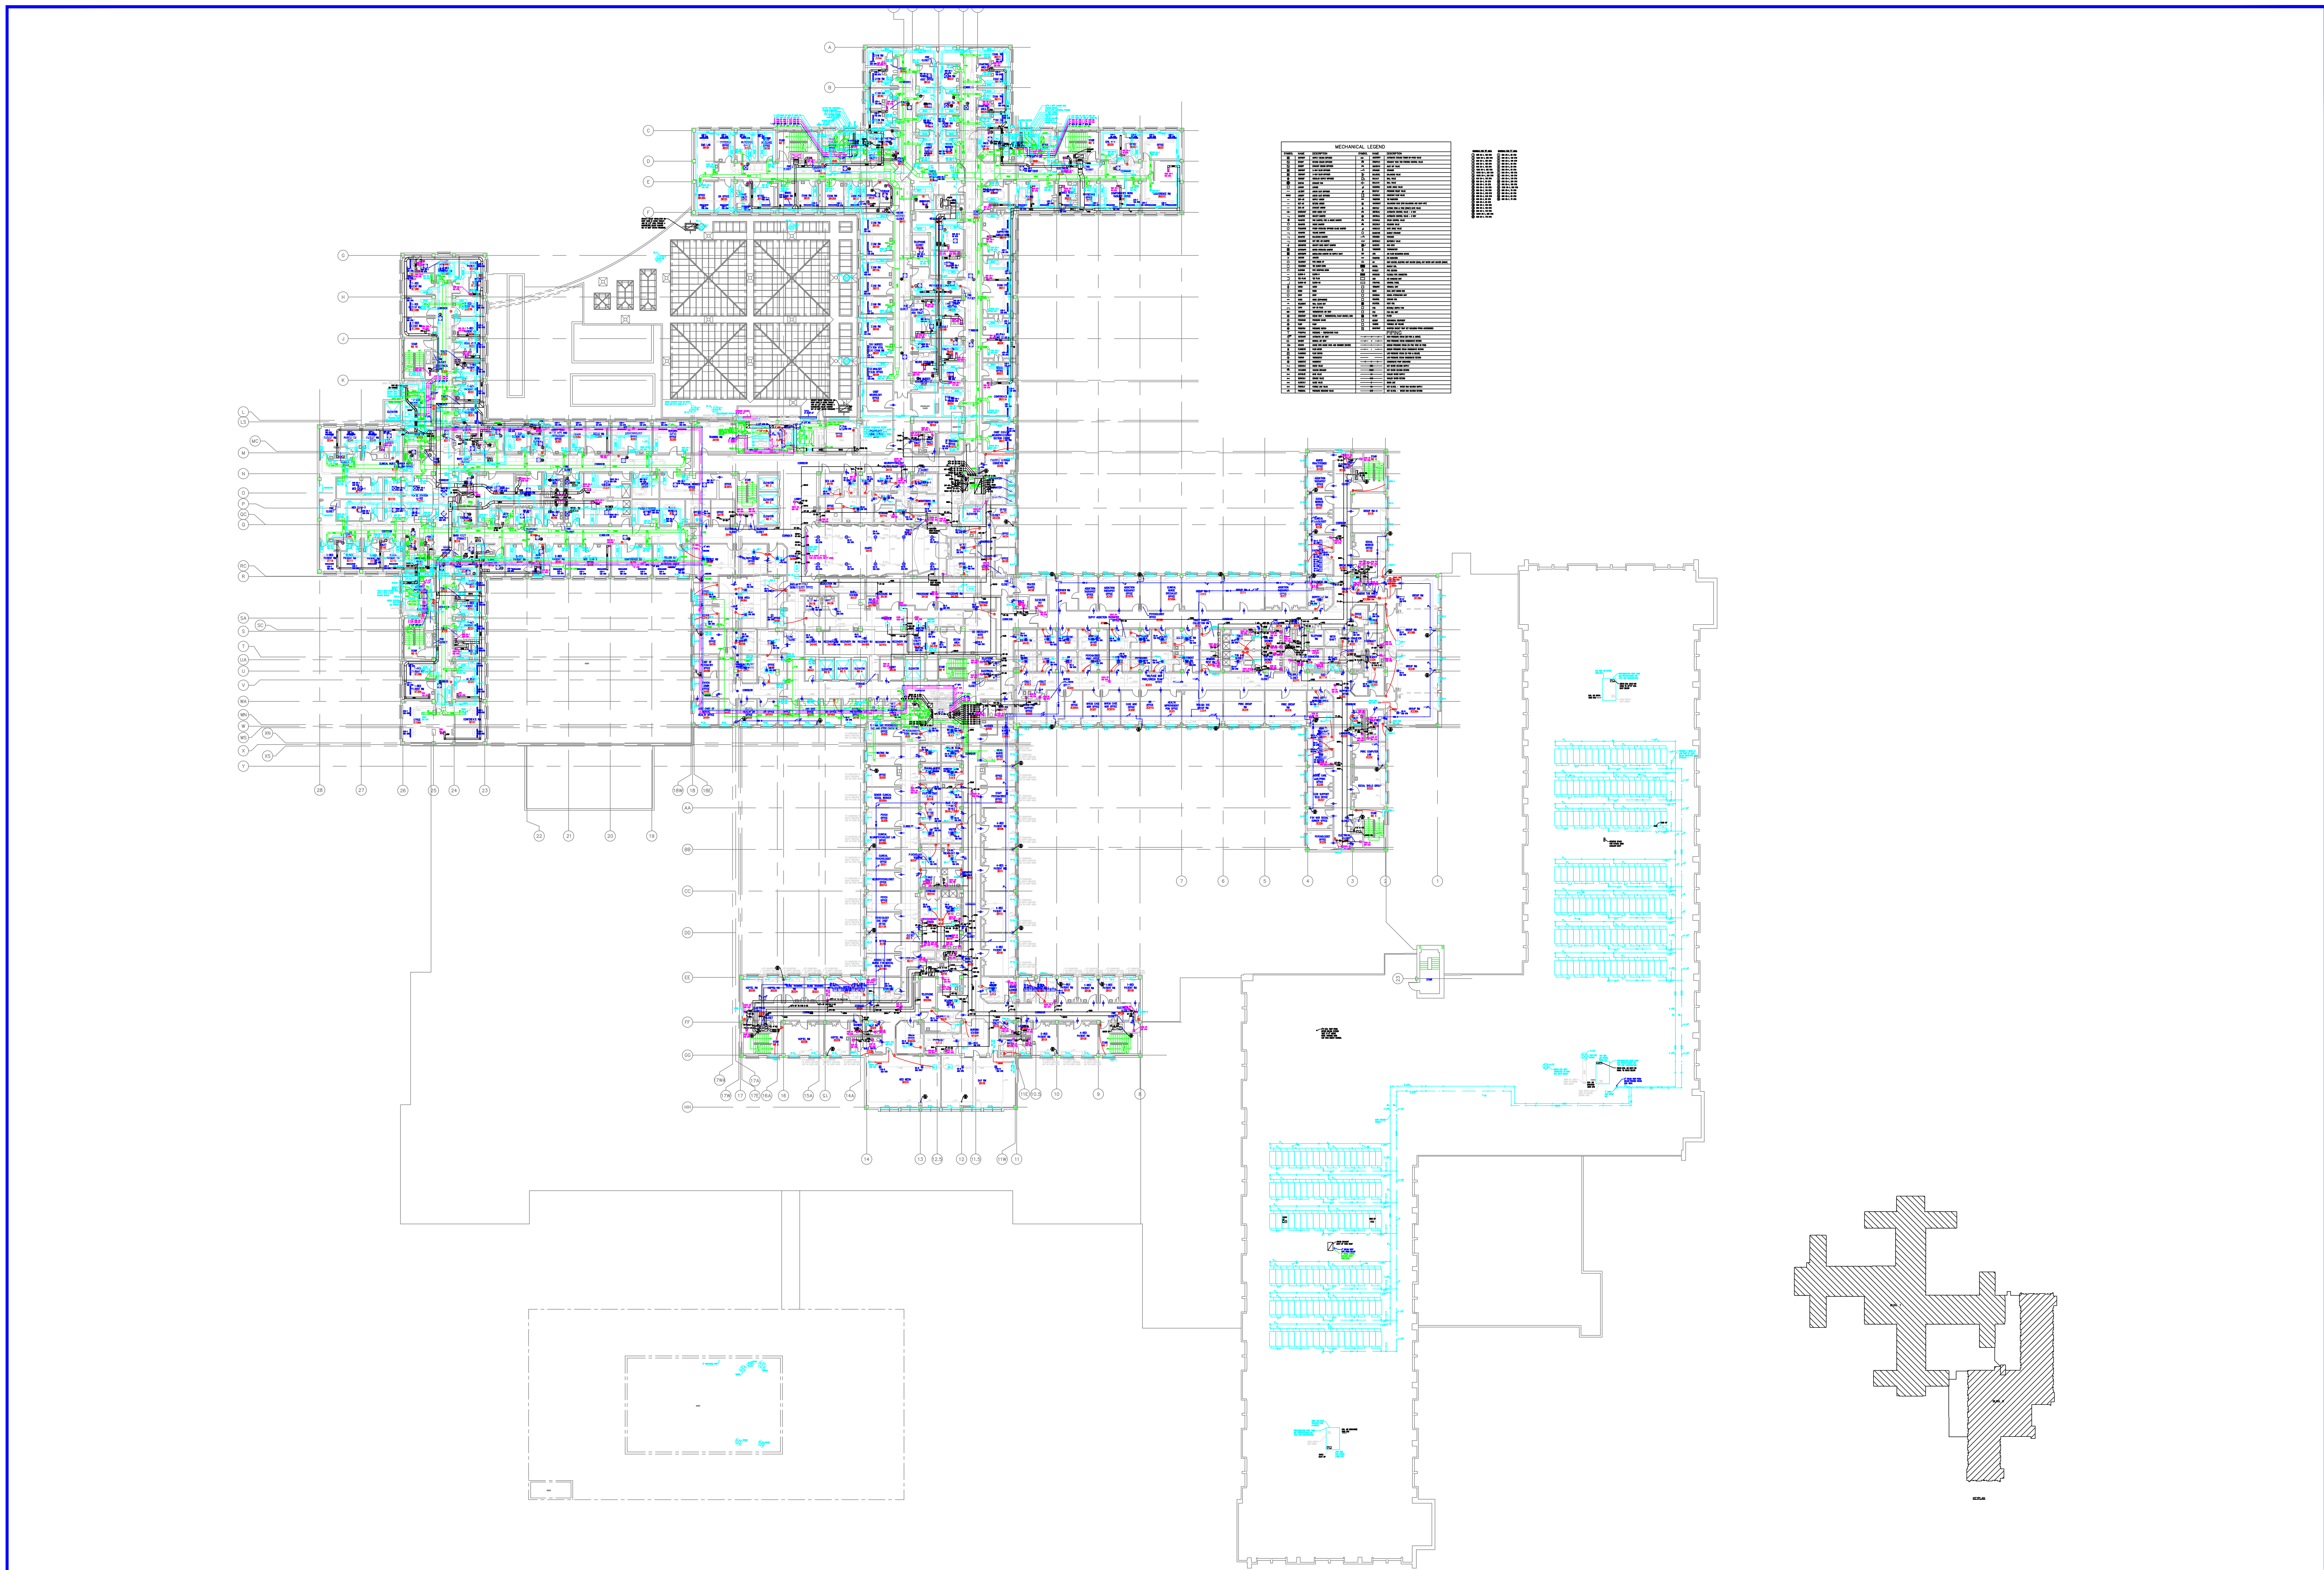

Revisions		Date	Professional Seal	Drawing Title		Project Title		Date	
				THIRD FLOOR PLAN MECHANICAL		AS-BUILT Drawings		05-12-2007	
				Approved:		Building Number		Project No.	
Approved:		Location		VAMC, WASHINGTON WASHINGTON D.C.		Drawing No.		Checked	
Approved:		Location		VAMC, WASHINGTON WASHINGTON D.C.		Drawing No.		Drawn	

three inches = one foot

one and one half inches = one foot

one inch = one foot


three quarters inch = one foot

one half inch = one foot


three eighths inch = one foot

one quarter inch = one foot


one eighth inch = one foot

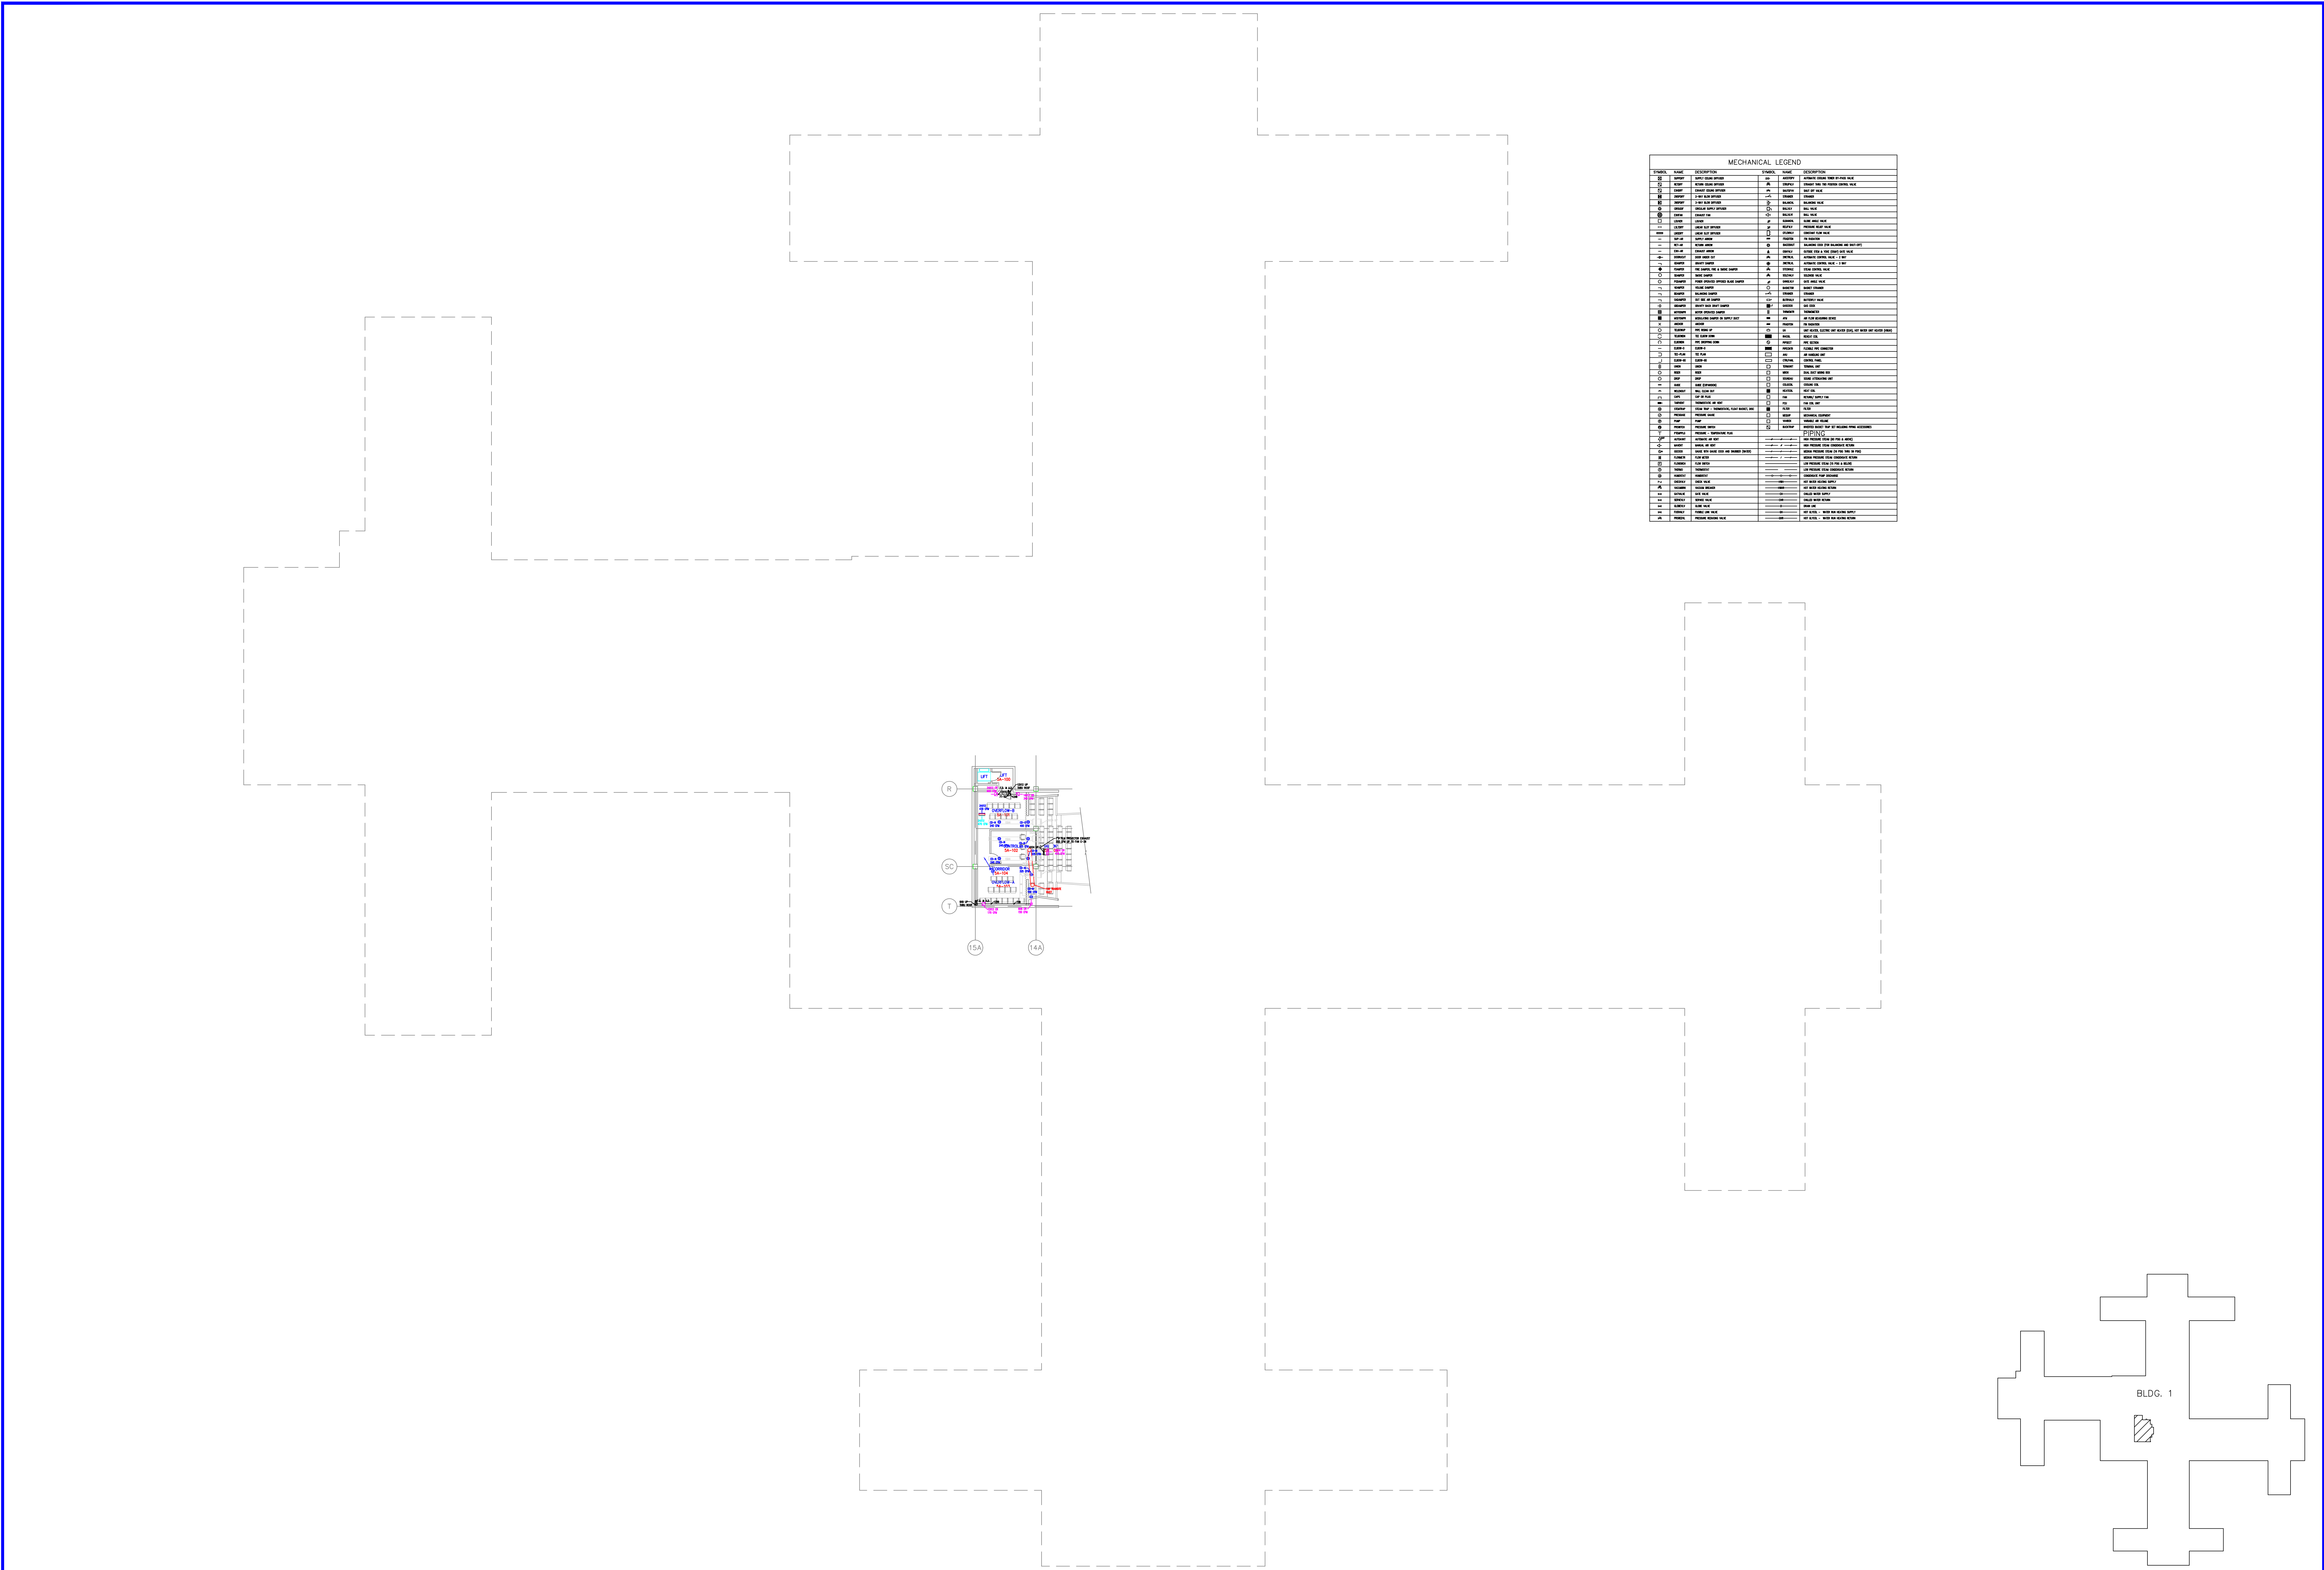


MECHANICAL LEGEND					
SYMBOL	NAME	DESCRIPTION	SYMBOL	NAME	DESCRIPTION
1	1	1	1	1	1
2	2	2	2	2	2
3	3	3	3	3	3
100	100	100	100	100	100

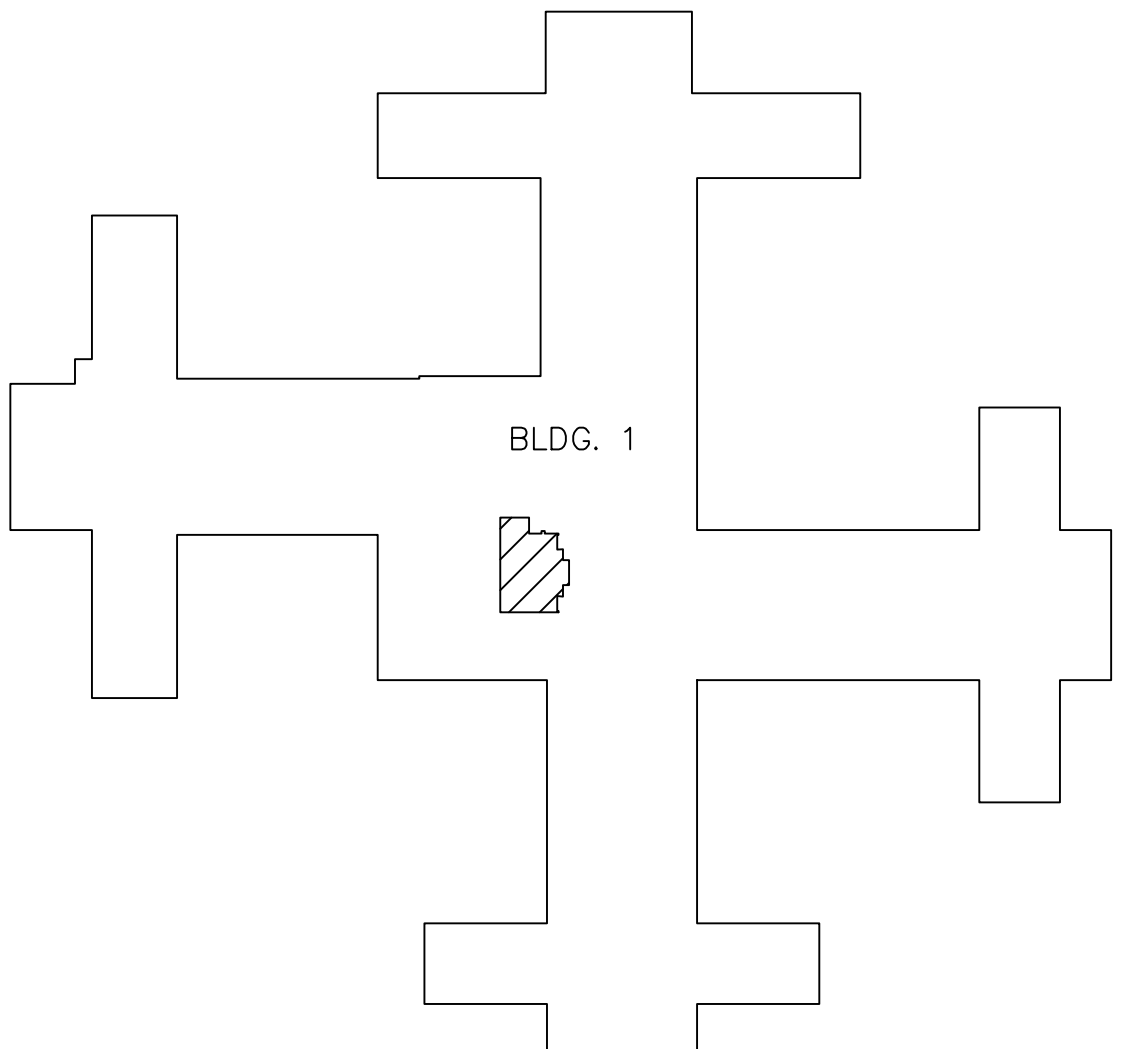

Revisions		Date	Professional Seal	Drawing Title		Project Title		Date	
				MEZZANINE FLOOR PLAN MECHANICAL		AS-BUILT Drawings		05-12-2007	
				Approved:		Building Number		Checked	
						01		Drawn	
				Approved:		Location		Drawing No.	
						VAMC, WASHINGTON WASHINGTON D.C.			

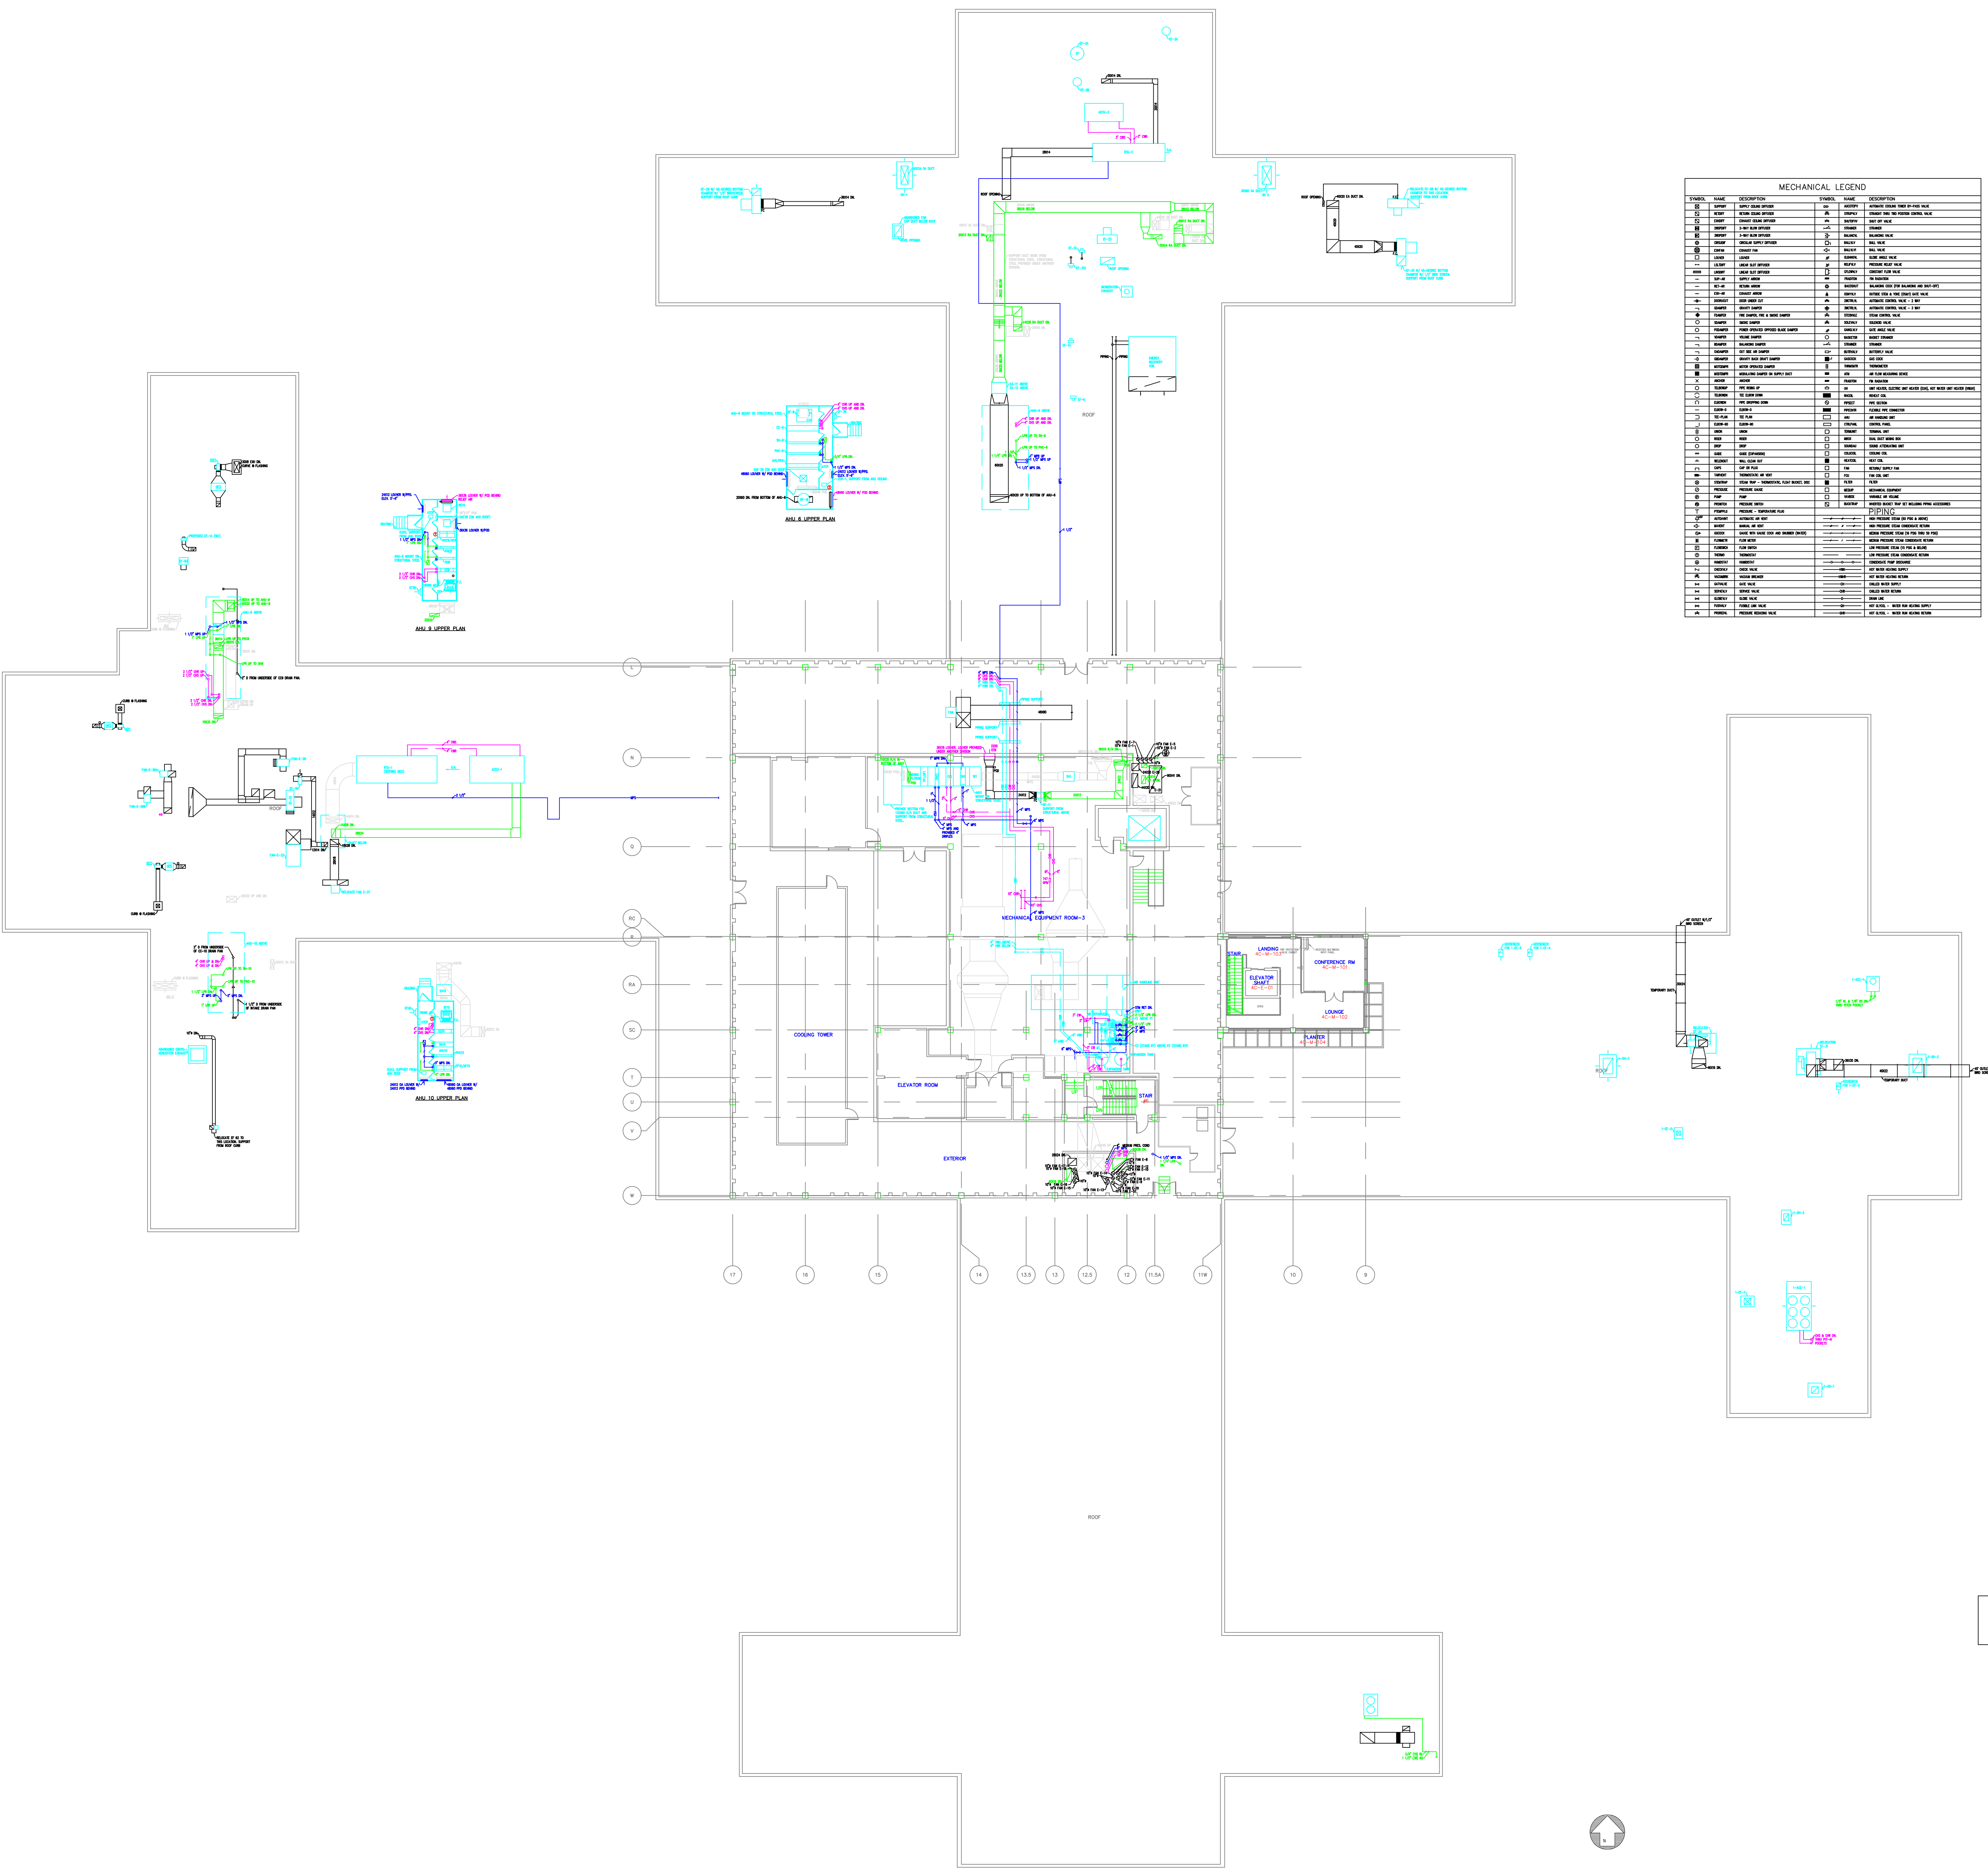

MECHANICAL LEGEND			
SYMBOL	DESCRIPTION	SYMBOL	DESCRIPTION
ASH-1	ASH-1 AIR HANDLING UNIT	ASH-2	ASH-2 AIR HANDLING UNIT
ASH-3	ASH-3 AIR HANDLING UNIT	ASH-4	ASH-4 AIR HANDLING UNIT
ASH-5	ASH-5 AIR HANDLING UNIT	ASH-6	ASH-6 AIR HANDLING UNIT
ASH-7	ASH-7 AIR HANDLING UNIT	ASH-8	ASH-8 AIR HANDLING UNIT
ASH-9	ASH-9 AIR HANDLING UNIT	ASH-10	ASH-10 AIR HANDLING UNIT
ASH-11	ASH-11 AIR HANDLING UNIT	ASH-12	ASH-12 AIR HANDLING UNIT
ASH-13	ASH-13 AIR HANDLING UNIT	ASH-14	ASH-14 AIR HANDLING UNIT
ASH-15	ASH-15 AIR HANDLING UNIT	ASH-16	ASH-16 AIR HANDLING UNIT
ASH-17	ASH-17 AIR HANDLING UNIT	ASH-18	ASH-18 AIR HANDLING UNIT
ASH-19	ASH-19 AIR HANDLING UNIT	ASH-20	ASH-20 AIR HANDLING UNIT
ASH-21	ASH-21 AIR HANDLING UNIT	ASH-22	ASH-22 AIR HANDLING UNIT
ASH-23	ASH-23 AIR HANDLING UNIT	ASH-24	ASH-24 AIR HANDLING UNIT
ASH-25	ASH-25 AIR HANDLING UNIT	ASH-26	ASH-26 AIR HANDLING UNIT
ASH-27	ASH-27 AIR HANDLING UNIT	ASH-28	ASH-28 AIR HANDLING UNIT
ASH-29	ASH-29 AIR HANDLING UNIT	ASH-30	ASH-30 AIR HANDLING UNIT
ASH-31	ASH-31 AIR HANDLING UNIT	ASH-32	ASH-32 AIR HANDLING UNIT
ASH-33	ASH-33 AIR HANDLING UNIT	ASH-34	ASH-34 AIR HANDLING UNIT
ASH-35	ASH-35 AIR HANDLING UNIT	ASH-36	ASH-36 AIR HANDLING UNIT
ASH-37	ASH-37 AIR HANDLING UNIT	ASH-38	ASH-38 AIR HANDLING UNIT
ASH-39	ASH-39 AIR HANDLING UNIT	ASH-40	ASH-40 AIR HANDLING UNIT
ASH-41	ASH-41 AIR HANDLING UNIT	ASH-42	ASH-42 AIR HANDLING UNIT
ASH-43	ASH-43 AIR HANDLING UNIT	ASH-44	ASH-44 AIR HANDLING UNIT
ASH-45	ASH-45 AIR HANDLING UNIT	ASH-46	ASH-46 AIR HANDLING UNIT
ASH-47	ASH-47 AIR HANDLING UNIT	ASH-48	ASH-48 AIR HANDLING UNIT
ASH-49	ASH-49 AIR HANDLING UNIT	ASH-50	ASH-50 AIR HANDLING UNIT
ASH-51	ASH-51 AIR HANDLING UNIT	ASH-52	ASH-52 AIR HANDLING UNIT
ASH-53	ASH-53 AIR HANDLING UNIT	ASH-54	ASH-54 AIR HANDLING UNIT
ASH-55	ASH-55 AIR HANDLING UNIT	ASH-56	ASH-56 AIR HANDLING UNIT
ASH-57	ASH-57 AIR HANDLING UNIT	ASH-58	ASH-58 AIR HANDLING UNIT
ASH-59	ASH-59 AIR HANDLING UNIT	ASH-60	ASH-60 AIR HANDLING UNIT
ASH-61	ASH-61 AIR HANDLING UNIT	ASH-62	ASH-62 AIR HANDLING UNIT
ASH-63	ASH-63 AIR HANDLING UNIT	ASH-64	ASH-64 AIR HANDLING UNIT
ASH-65	ASH-65 AIR HANDLING UNIT	ASH-66	ASH-66 AIR HANDLING UNIT
ASH-67	ASH-67 AIR HANDLING UNIT	ASH-68	ASH-68 AIR HANDLING UNIT
ASH-69	ASH-69 AIR HANDLING UNIT	ASH-70	ASH-70 AIR HANDLING UNIT
ASH-71	ASH-71 AIR HANDLING UNIT	ASH-72	ASH-72 AIR HANDLING UNIT
ASH-73	ASH-73 AIR HANDLING UNIT	ASH-74	ASH-74 AIR HANDLING UNIT
ASH-75	ASH-75 AIR HANDLING UNIT	ASH-76	ASH-76 AIR HANDLING UNIT
ASH-77	ASH-77 AIR HANDLING UNIT	ASH-78	ASH-78 AIR HANDLING UNIT
ASH-79	ASH-79 AIR HANDLING UNIT	ASH-80	ASH-80 AIR HANDLING UNIT
ASH-81	ASH-81 AIR HANDLING UNIT	ASH-82	ASH-82 AIR HANDLING UNIT
ASH-83	ASH-83 AIR HANDLING UNIT	ASH-84	ASH-84 AIR HANDLING UNIT
ASH-85	ASH-85 AIR HANDLING UNIT	ASH-86	ASH-86 AIR HANDLING UNIT
ASH-87	ASH-87 AIR HANDLING UNIT	ASH-88	ASH-88 AIR HANDLING UNIT
ASH-89	ASH-89 AIR HANDLING UNIT	ASH-90	ASH-90 AIR HANDLING UNIT
ASH-91	ASH-91 AIR HANDLING UNIT	ASH-92	ASH-92 AIR HANDLING UNIT
ASH-93	ASH-93 AIR HANDLING UNIT	ASH-94	ASH-94 AIR HANDLING UNIT
ASH-95	ASH-95 AIR HANDLING UNIT	ASH-96	ASH-96 AIR HANDLING UNIT
ASH-97	ASH-97 AIR HANDLING UNIT	ASH-98	ASH-98 AIR HANDLING UNIT
ASH-99	ASH-99 AIR HANDLING UNIT	ASH-100	ASH-100 AIR HANDLING UNIT

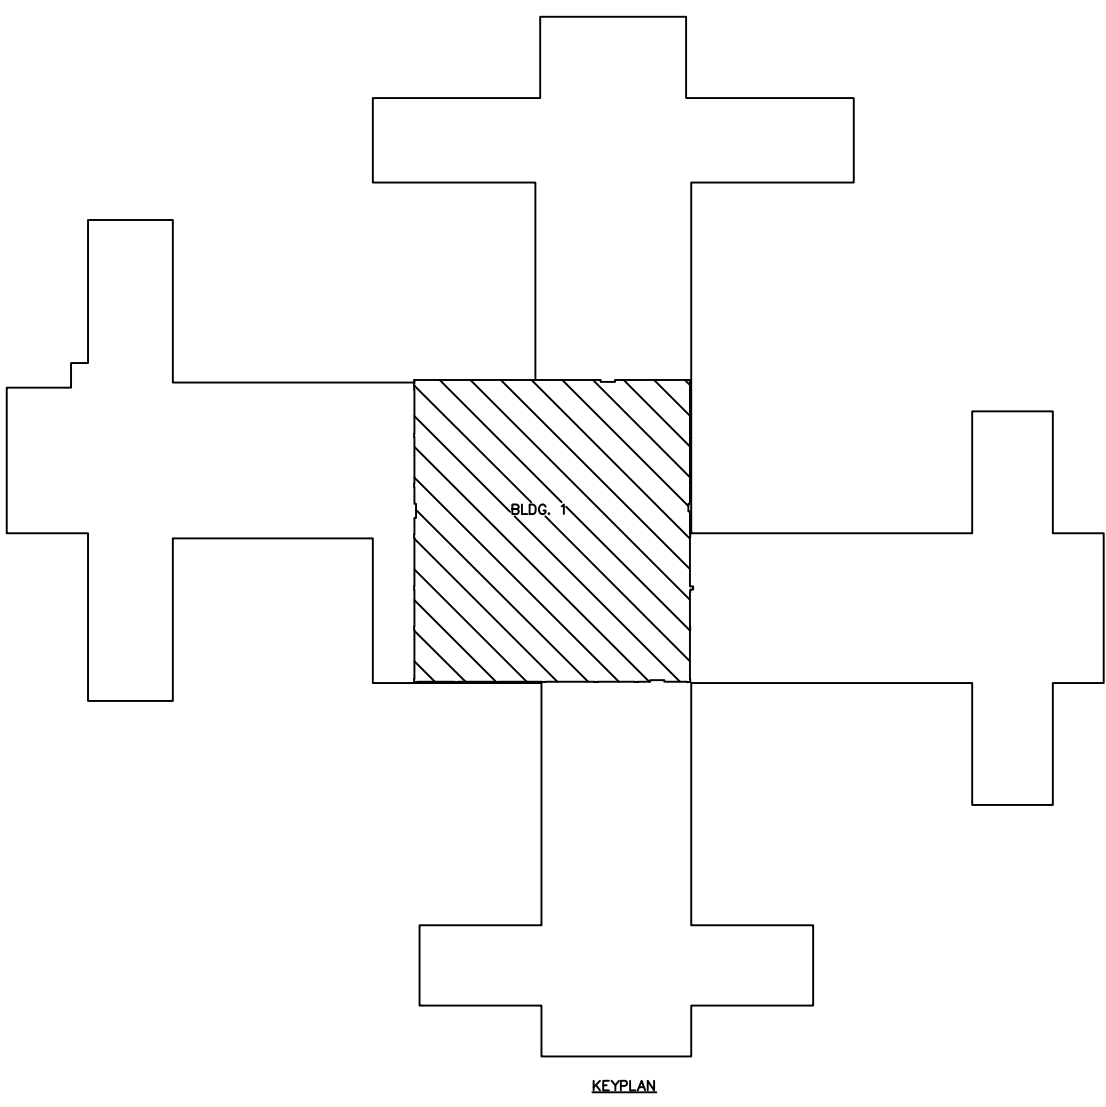

Revisions		Date	Professional Seal		Drawing Title PENTHOUSE FLOOR PLAN MECHANICAL	Project Title AS-BUILT Drawings		Date 05-12-2007		Department of Veterans Affairs	
					Approved:	Building Number 01	Checked	Drawn			Project No.
					Approved:	Location VAMC, WASHINGTON WASHINGTON D.C.					Drawing No.

A

A

B

B

C

C

D










D

E

E

F

F

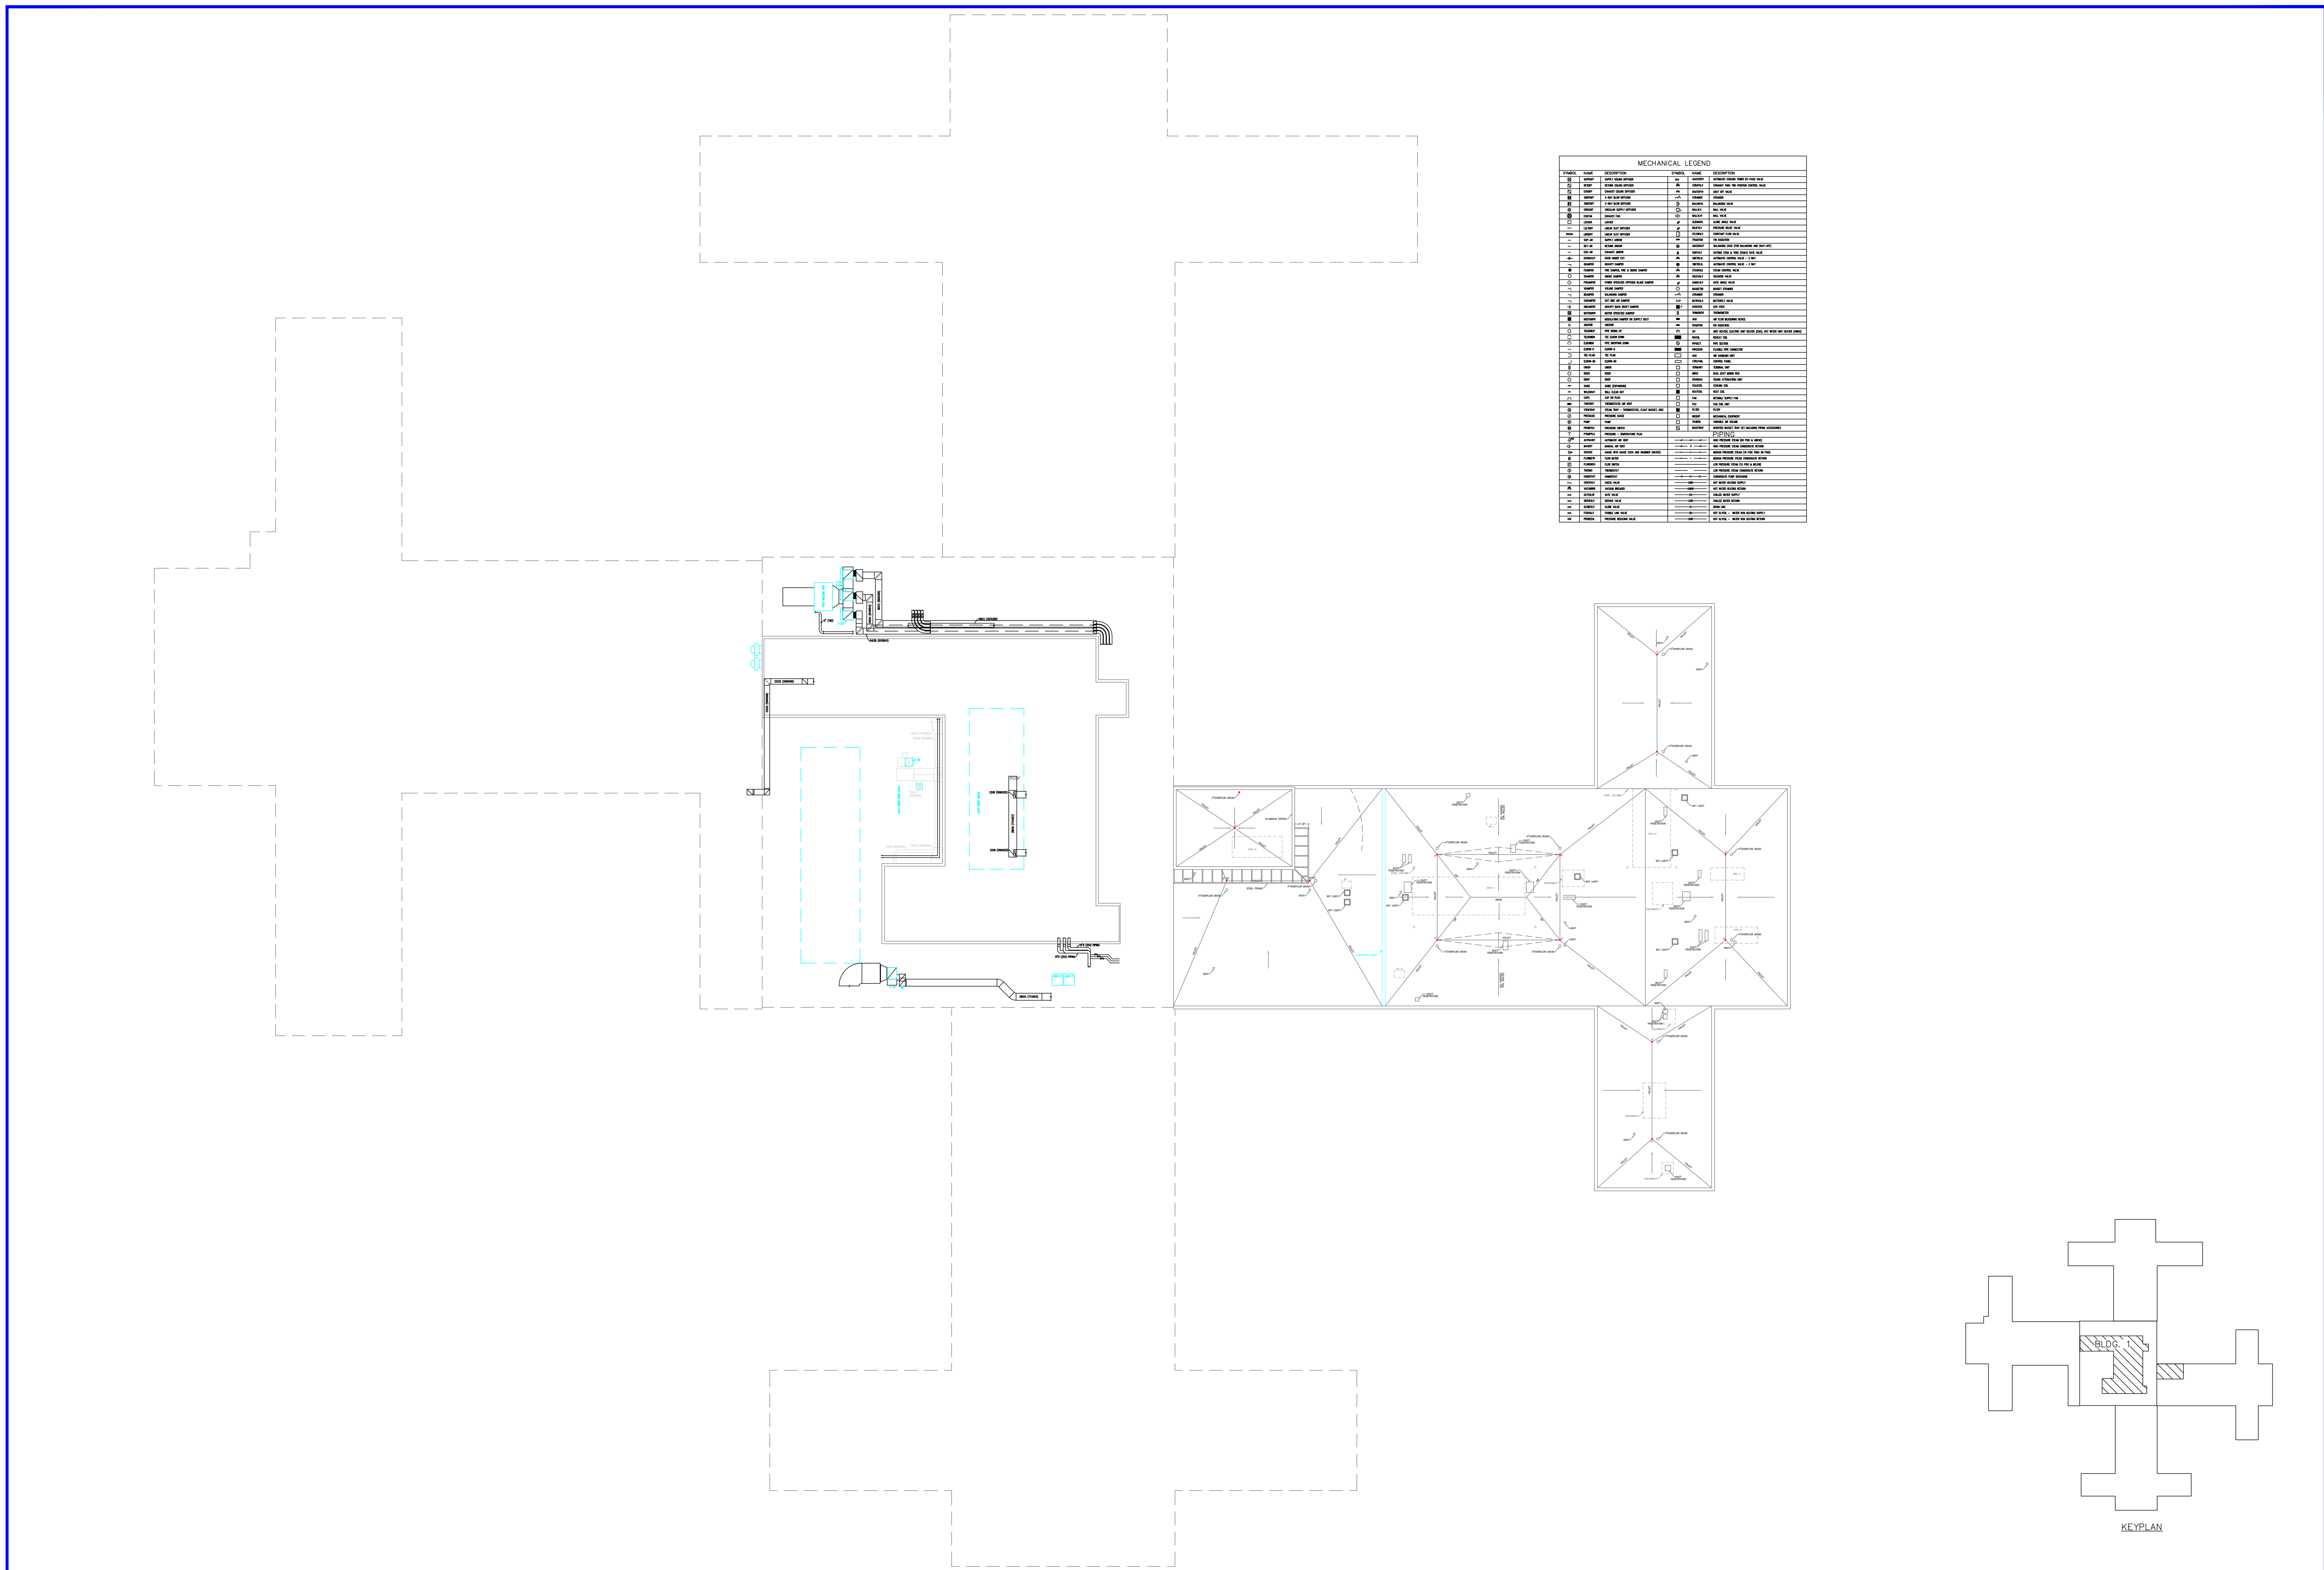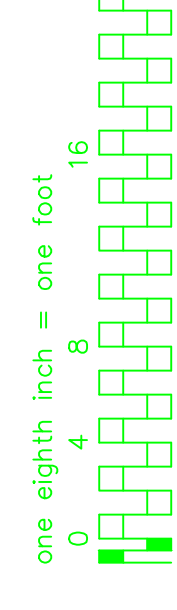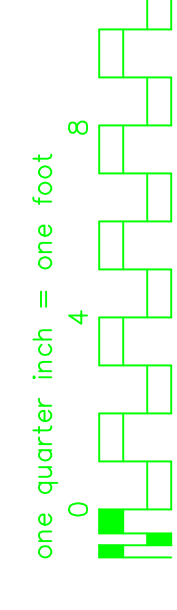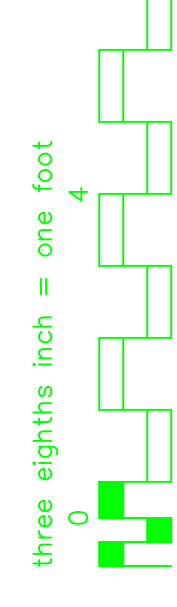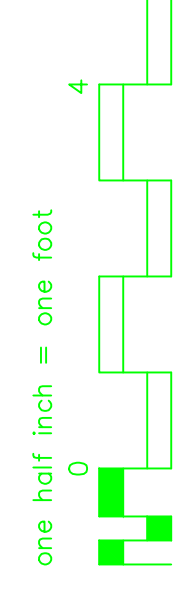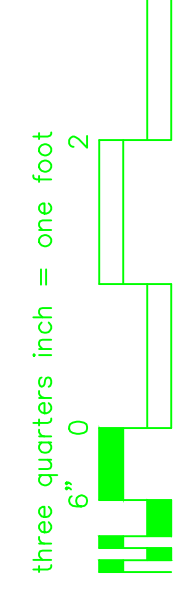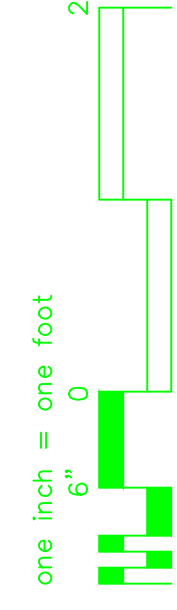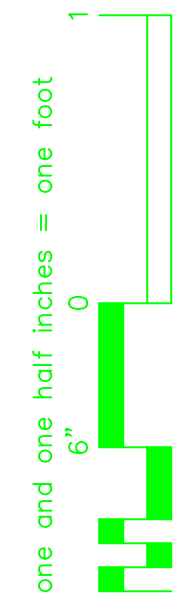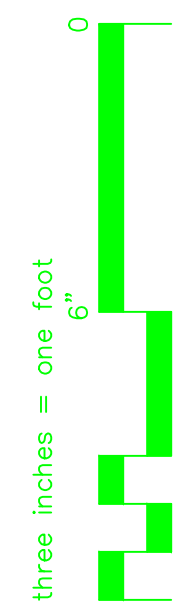

MECHANICAL LEGEND			
SYMBOL	NAME	DESCRIPTION	NOTES
1	ROOF	ROOF FLOOR PLAN	
2	ROOF	ROOF FLOOR PLAN	
3	ROOF	ROOF FLOOR PLAN	
100	ROOF	ROOF FLOOR PLAN	

Revisions		Date	Professional Seal		Drawing Title ROOF FLOOR PLAN MECHANICAL		Project Title AS-BUILT Drawings		Date 05-12-2007				Department of Veterans Affairs			
					Approved:		Building Number 01		Checked						Drawn	
					Approved:		Location VAMC, WASHINGTON WASHINGTON D.C.		Drawing No.							